


JERRY'S HOMES, INC. - 10430 NEW YORK AVENUE, SUITE C, - URBANDALE, IOWA 50322
ATTN: CHIP CLASSON PHONE: 515-278-5992

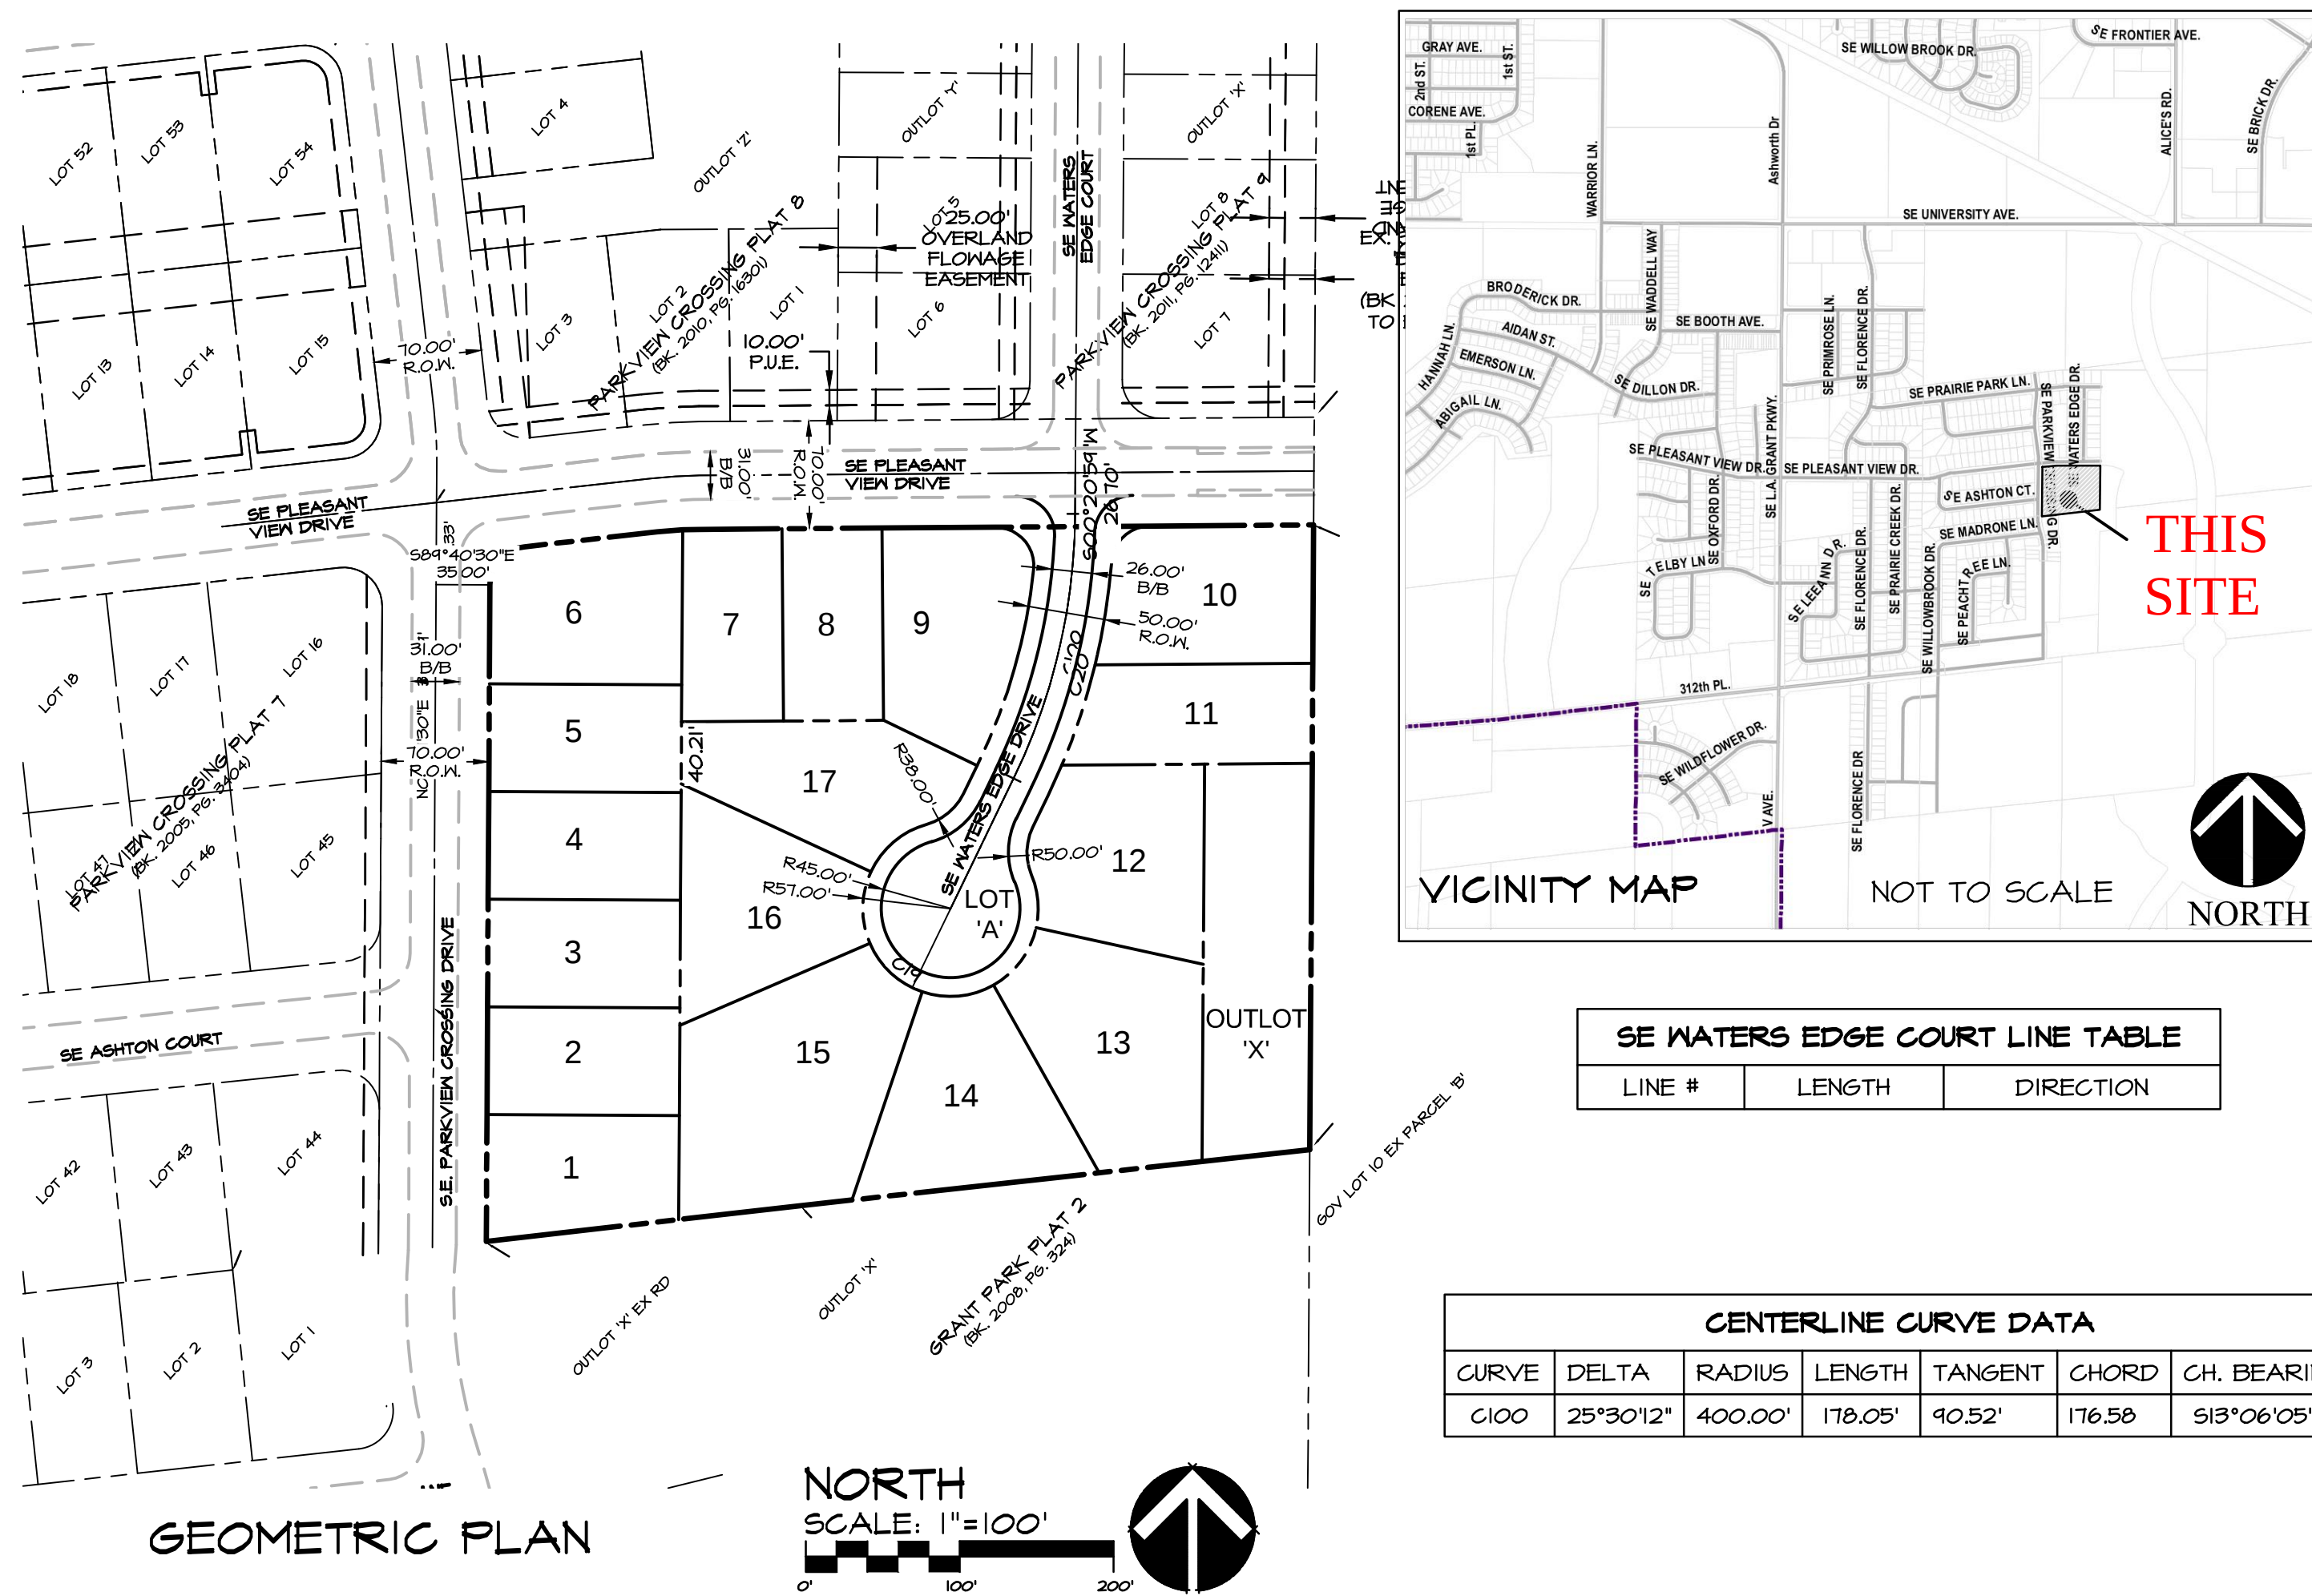

ELEVATION = 1025.46







I HEREBY CERTIFY THAT THIS ENGINEERING DOCUMENT
 WAS PREPARED BY ME OR UNDER MY DIRECT PERSONAL
 SUPERVISION AND THAT I AM A DULY LICENSED
 PROFESSIONAL ENGINEER UNDER THE LAWS OF THE STATE
 OF IOWA.

MELISSA M. HILLS, IOWA REG. NO. 16023 DATE _____
 MY LICENSE RENEWAL DATE IS DECEMBER 31, 2015

PAGES OR SHEETS COVERED BY THIS SEAL: _____

1. ALL STORM WATER MANAGEMENT FACILITIES ON SITE WERE CONSTRUCTED AS DESIGNED
2. ALL RAMPS MEET ADA AND PROWAG REQUIREMENTS

CIVIL ENGINEERING CONSULTANTS, INC. 2400 86TH STREET, #12, DES MOINES, IOWA 50322

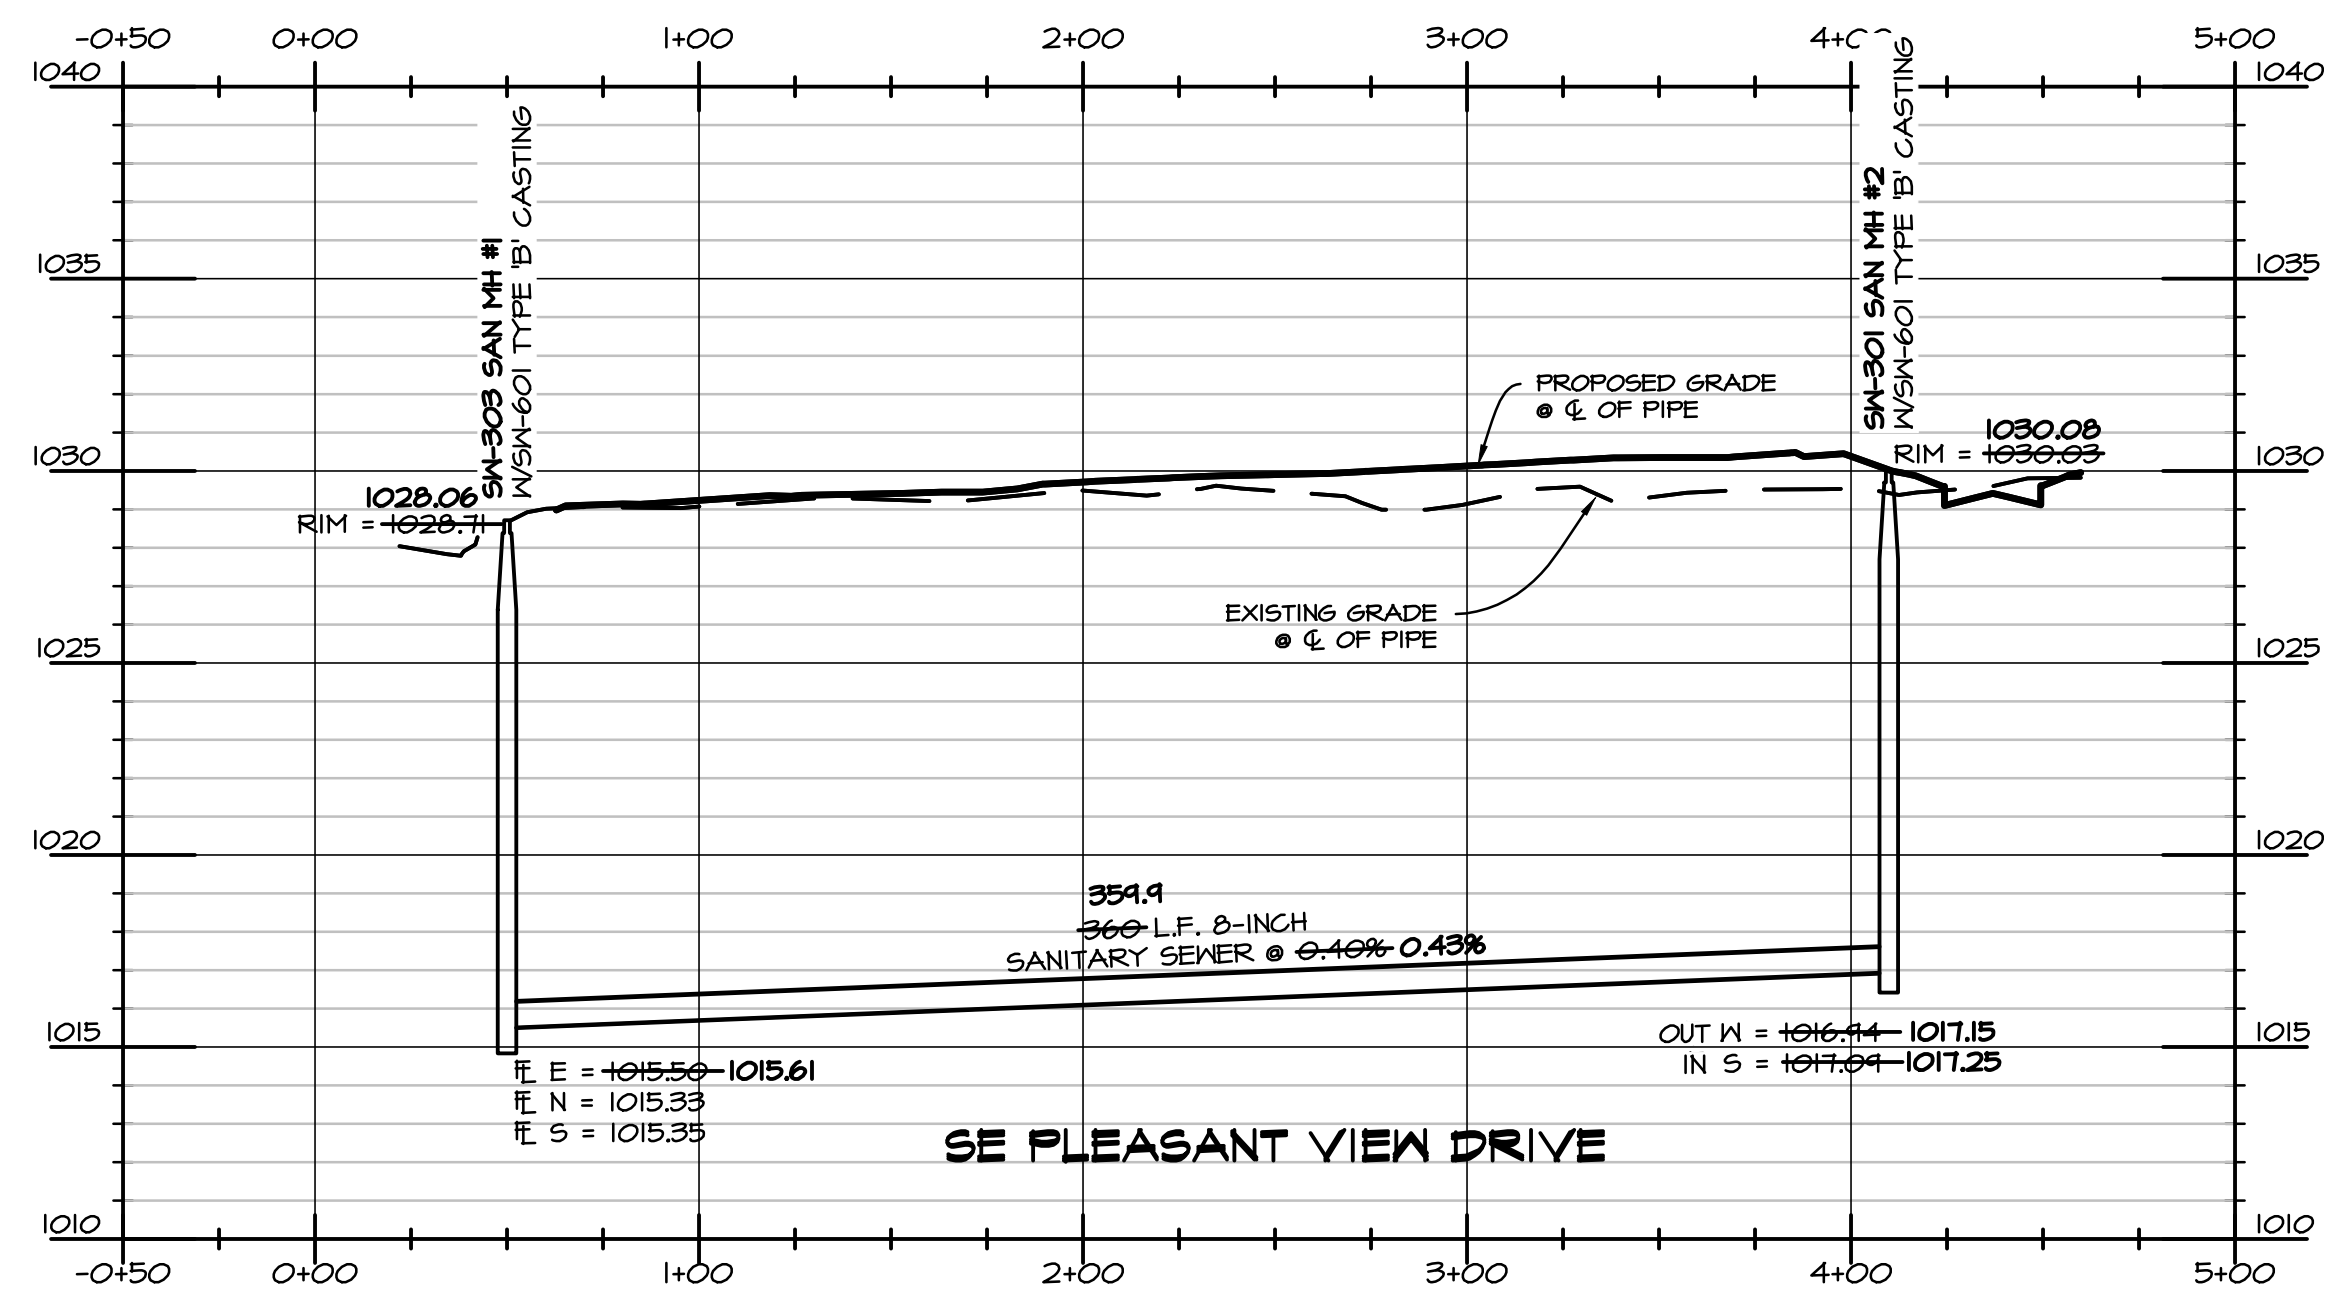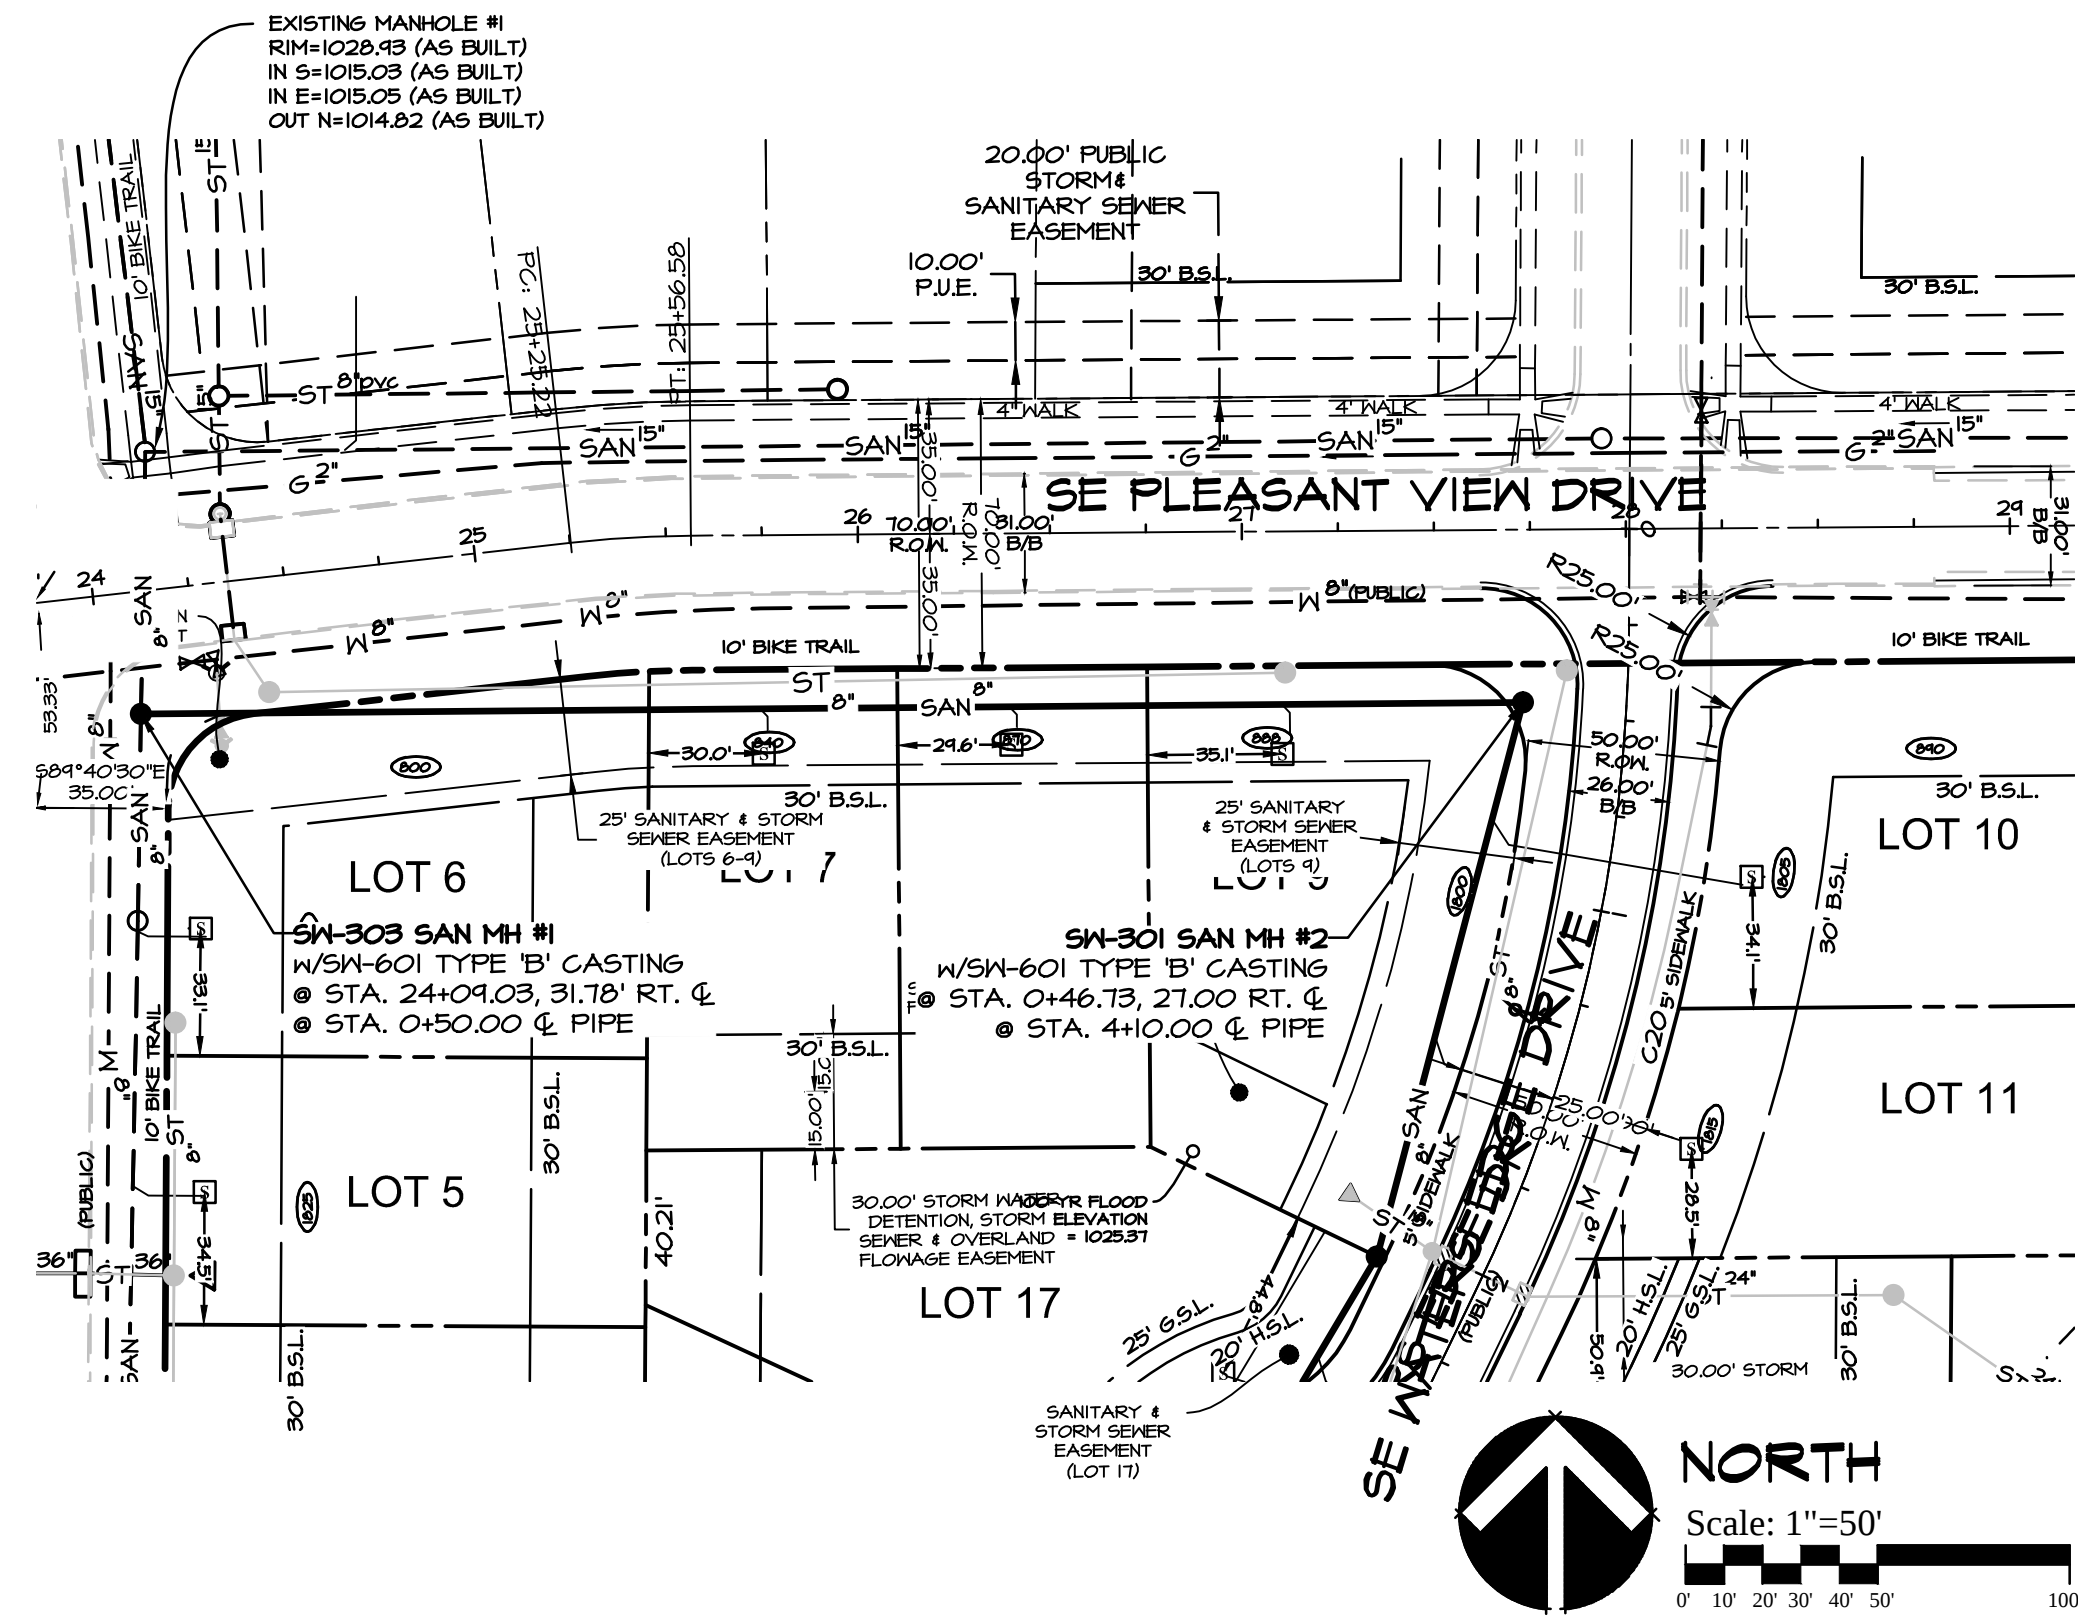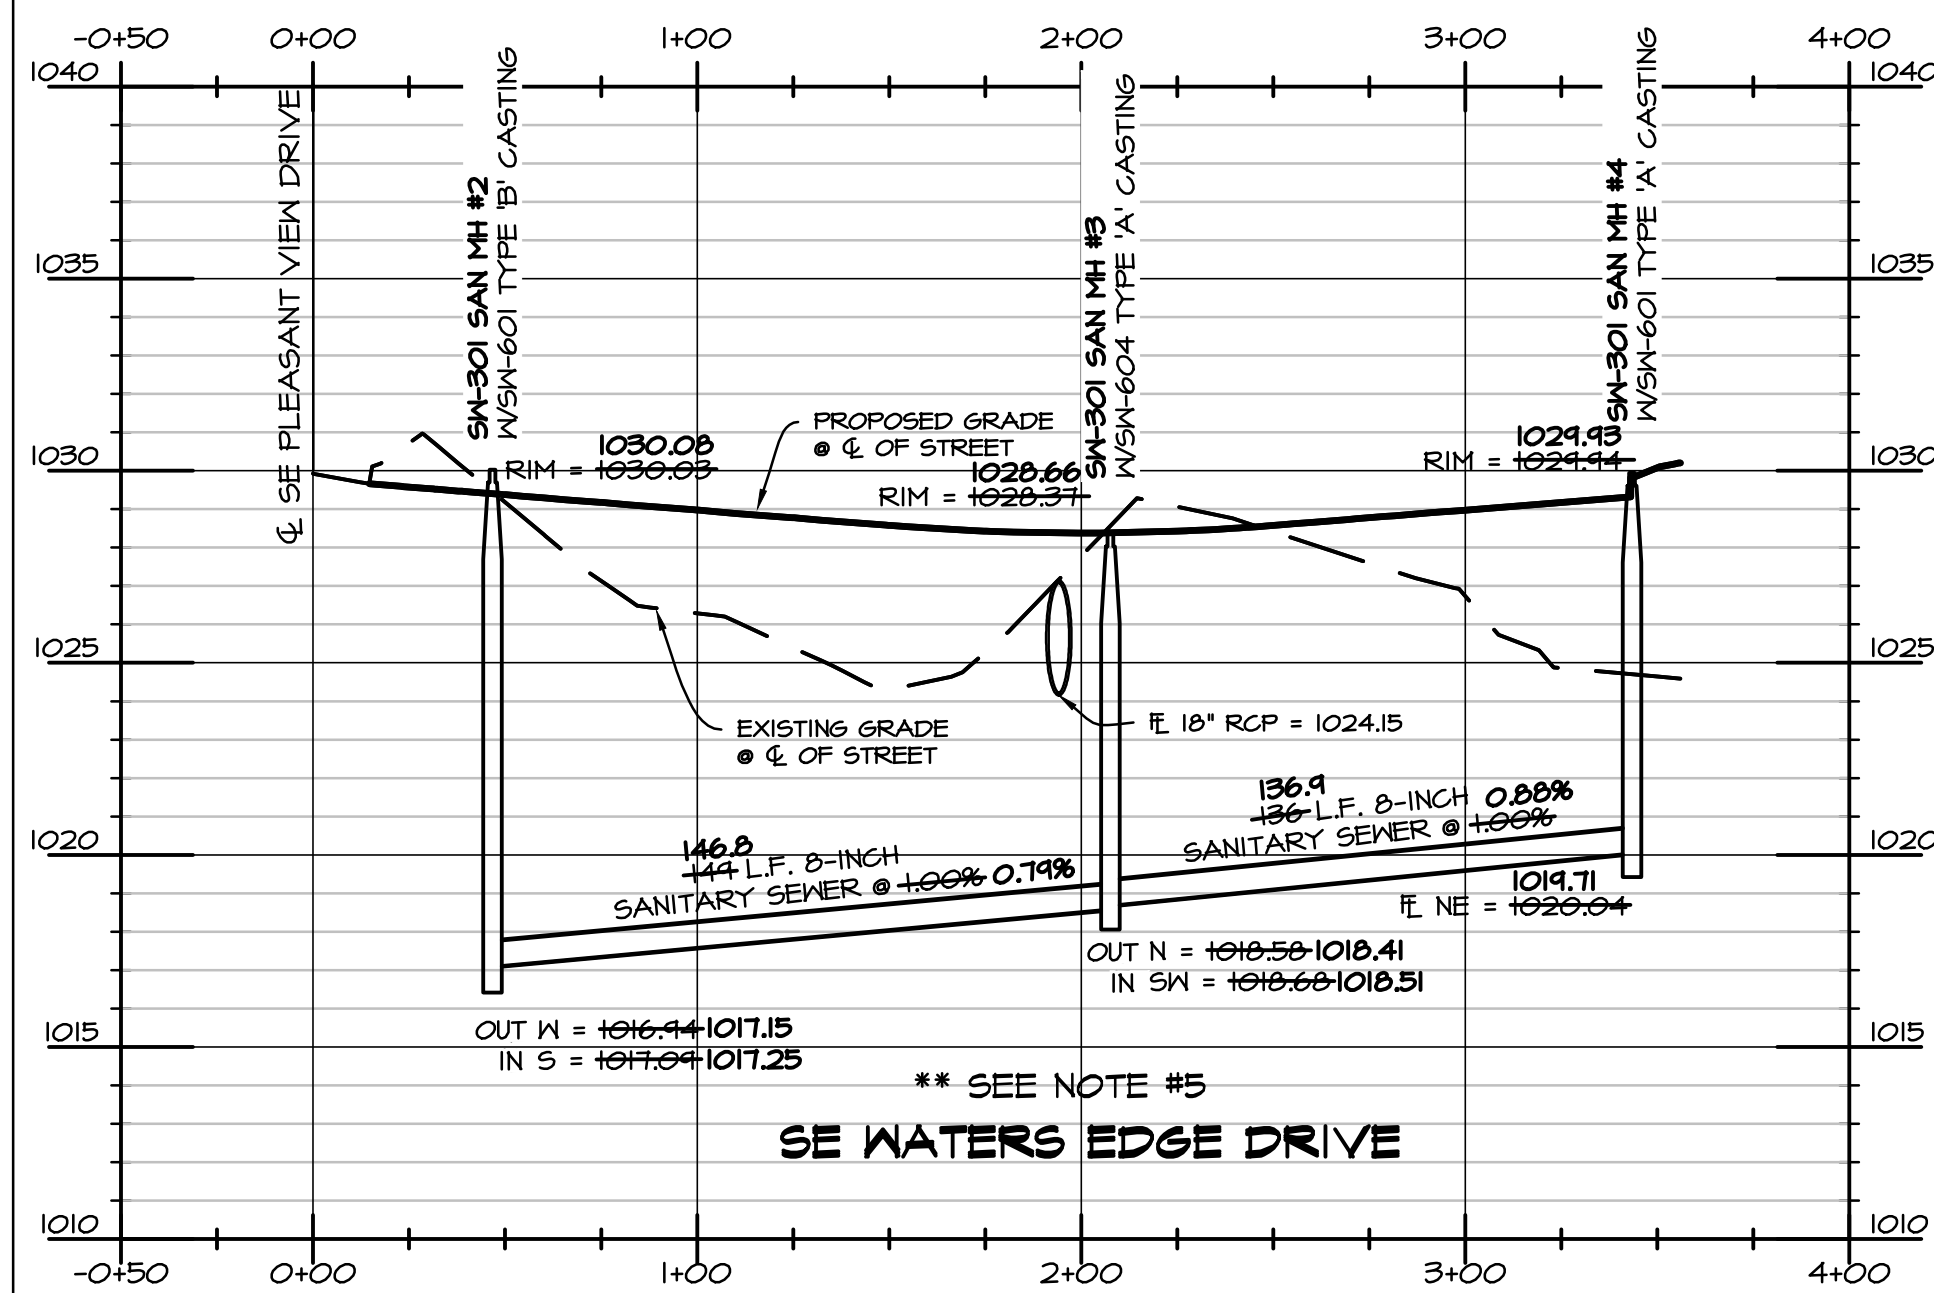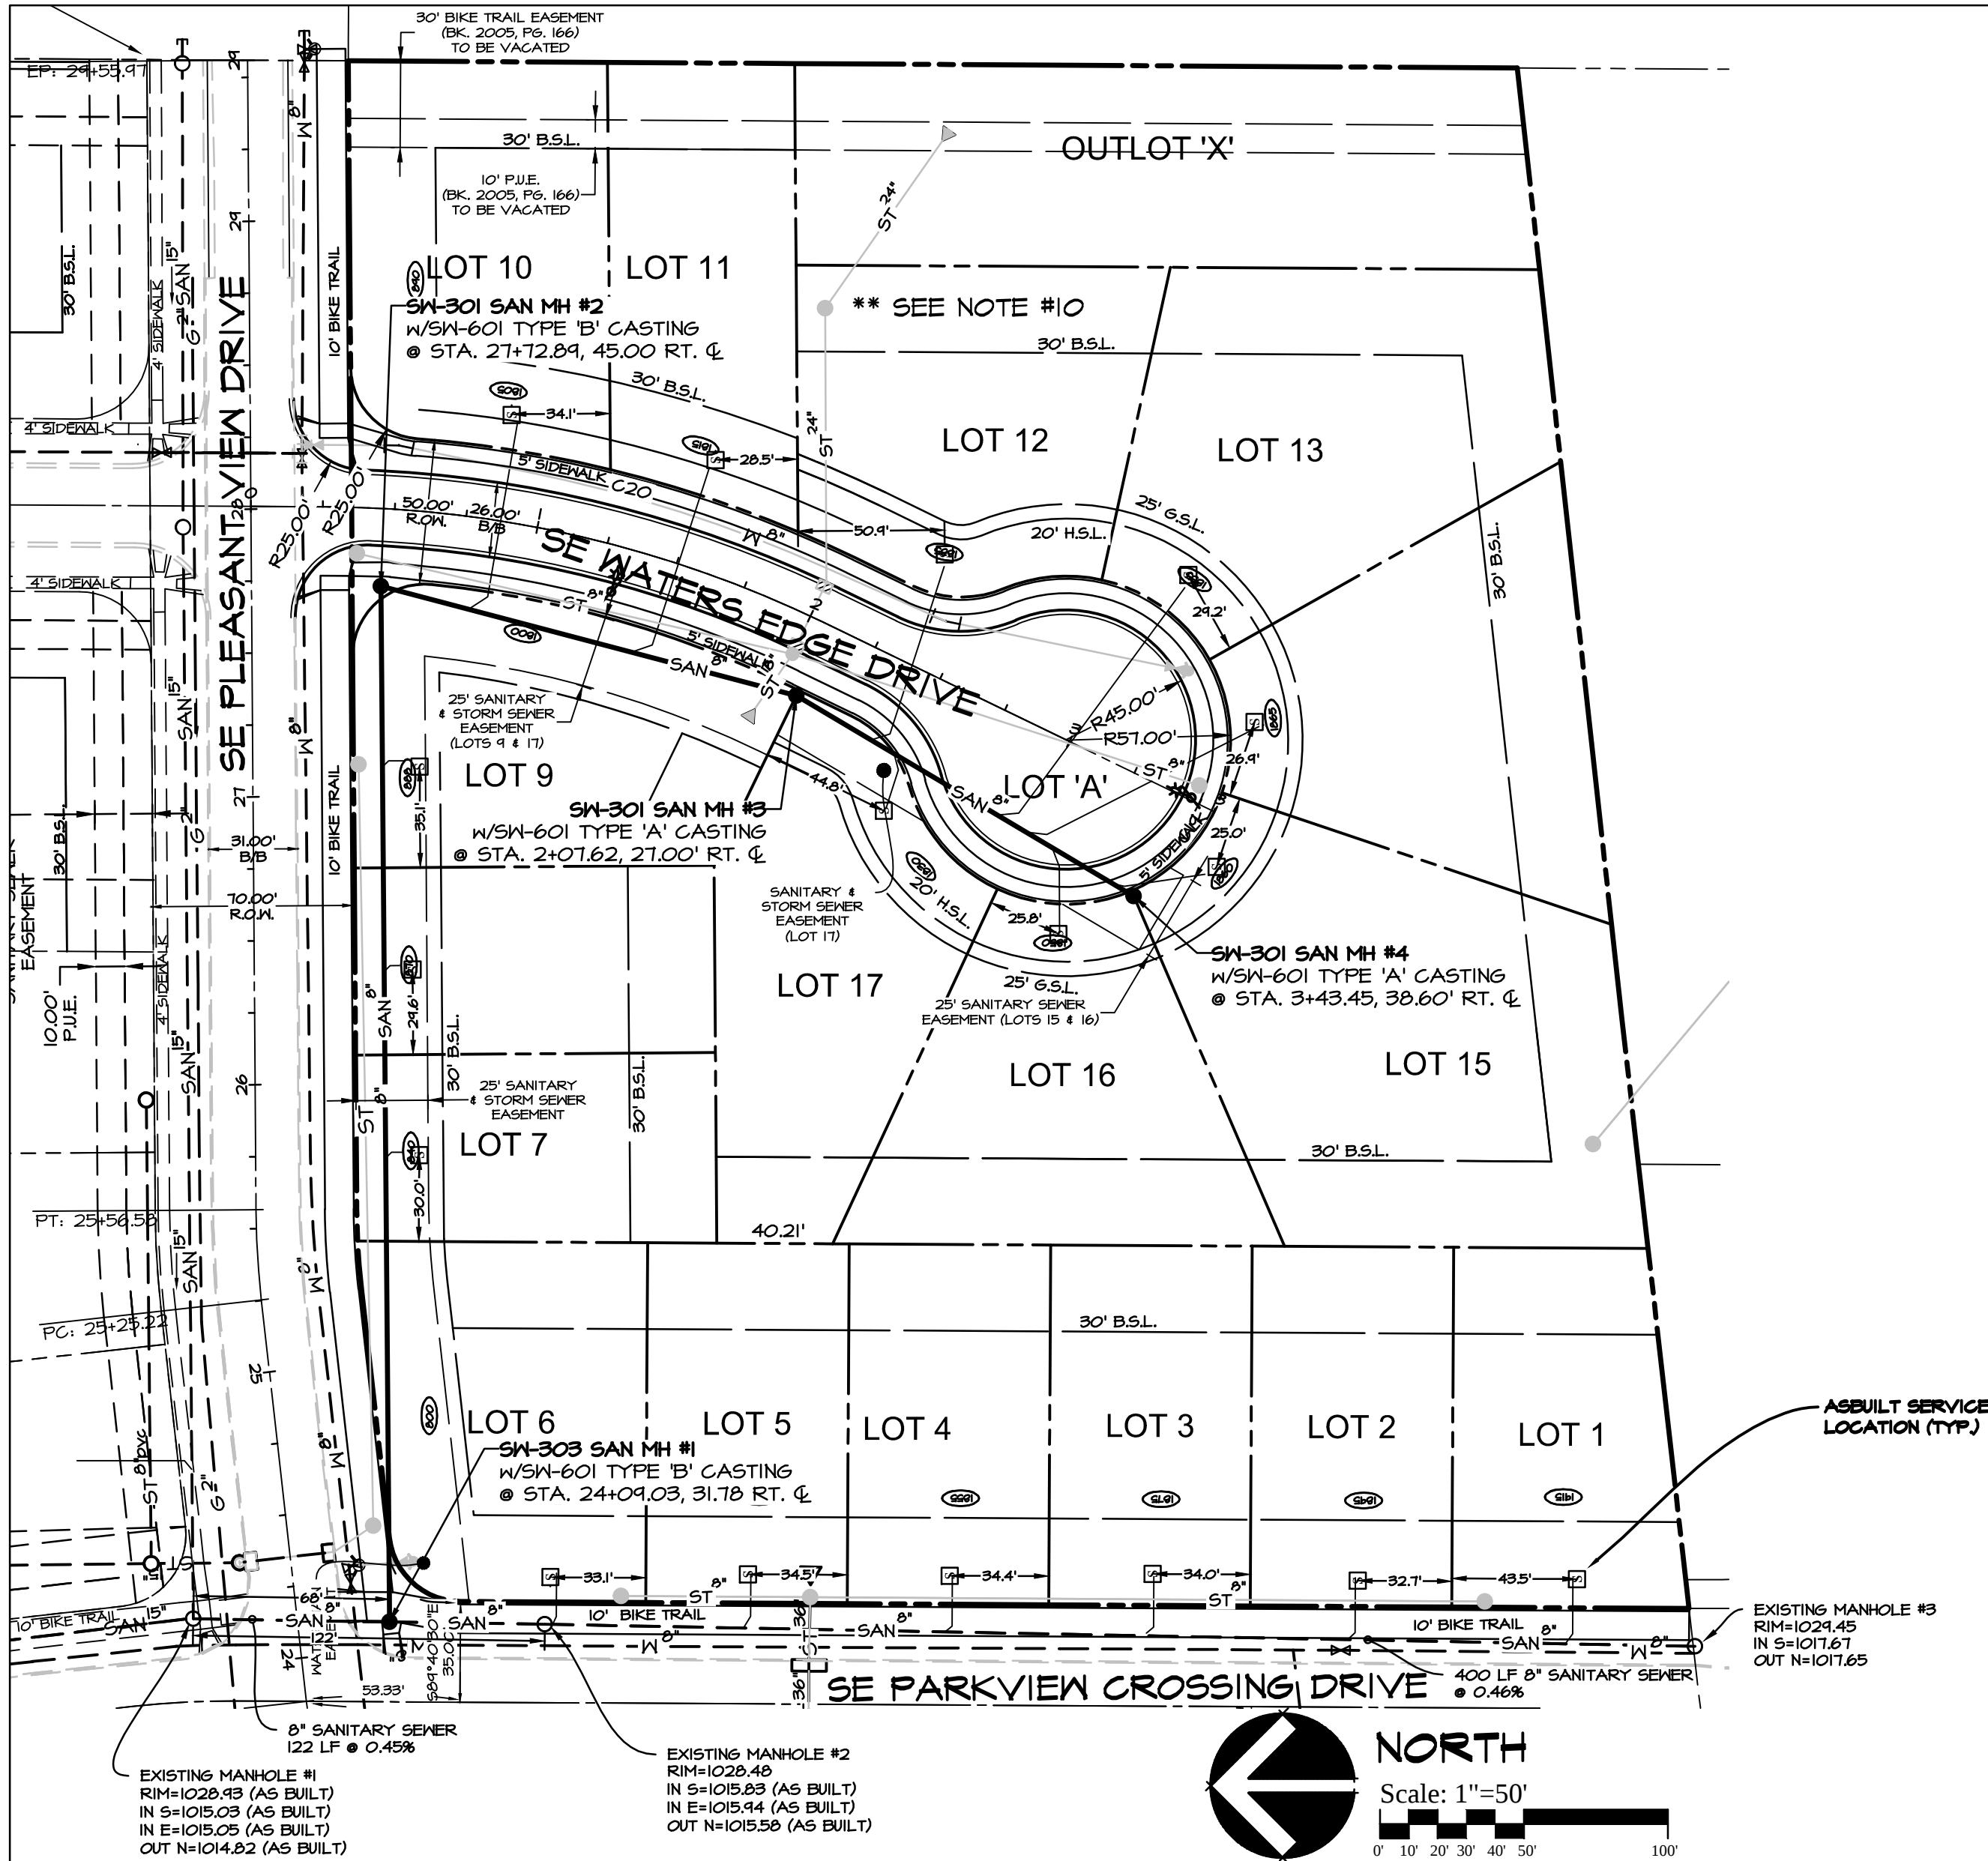

- NOTES**
- CASTING TYPES ARE FROM SUDAS SPECS.
 - WHEN CONNECTING TO ANY EXISTING MANHOLE, CORE DRILL MANHOLE & POUR WELL DEFINED INVERT. CONNECTION SHALL BE CONSTRUCTED WITH A WATERTIGHT SEAL. CONTRACTOR SHALL FIELD VERIFY THE INVERT INTO EXISTING MANHOLE #1 TO DETERMINE IF THE PROPOSED FLOW LINE NEEDS TO BE RAISED IN ORDER TO POUR A WELL DEFINED INVERT.
 - CONTRACTOR SHALL BE RESPONSIBLE FOR RECORDING AS-BUILT LOCATIONS OF ALL SANITARY SEWER SERVICES & PROVIDING THIS INFORMATION TO THE ENGINEER. THE CONTRACTOR SHALL CLEAN AND VIDEO TAPE THE SANITARY SEWER AT PROJECT COMPLETION. THE EXISTING SANITARY SEWER USED BY LOTS 1-6 SHALL ALSO BE VIDEO TAPED AND PRESSURE TESTED. A COPY OF THE VIDEO SHALL BE PROVIDED TO THE CITY OF Waukee Engineering Department.
 - SERVICES FOR LOTS 10-17 SHALL BE INSTALLED AT A MINIMUM GRADE OF 2%.
 - CONTRACTOR SHALL PROVIDE ENGINEER WITH ASBUILT DEPTH SO MINIMUM BASEMENT ELEVATIONS CAN BE DETERMINED.

QUANTITIES	
645 L.F.	8-INCH SANITARY SEWER
2 EA.	SM-301 MANHOLES W/SM-601 TYPE 'A' CASTING
2 EA.	SM-303 MANHOLE W/SM-601 TYPE 'B' CASTING
17 EA.	SERVICES

LEGEND

EXISTING/PROPOSED	
—	PLAT BOUNDARY
— SAN 8"	SANITARY SEWER & SIZE
— ST 18"	STORM SEWER & SIZE
— W 8"	WATER MAIN & SIZE
○	MANHOLE
□	STORM INTAKE
×	FIRE HYDRANT
+	VALVE
+	SERVICE CONNECTION
B.S.L.	BUILDING SETBACK LINE
H.S.L.	HOUSE SETBACK LINE
G.S.L.	GARAGE SETBACK LINE



SCALE	
50'	5'

DATE: 11-26-2013
REVISION: 12-18-2013
01-08-2014
01-30-2014

SHEET
2
OF 9



ASBUILT 7-31-2015




Civil Engineering Consultants, Inc.
2400 86th Street, Unit 12, Des Moines, Iowa 50322
515.276.4884, Fax: 515.276.7084, mail@ceclac.com

PLAN & PROFILE SANITARY SEWER
PARKVIEW CROSSING PLAT II
JERRY'S HOMES, INC., 10430 NEW YORK AVE SUITE C, URBANDALE, IA 50322

E-6853

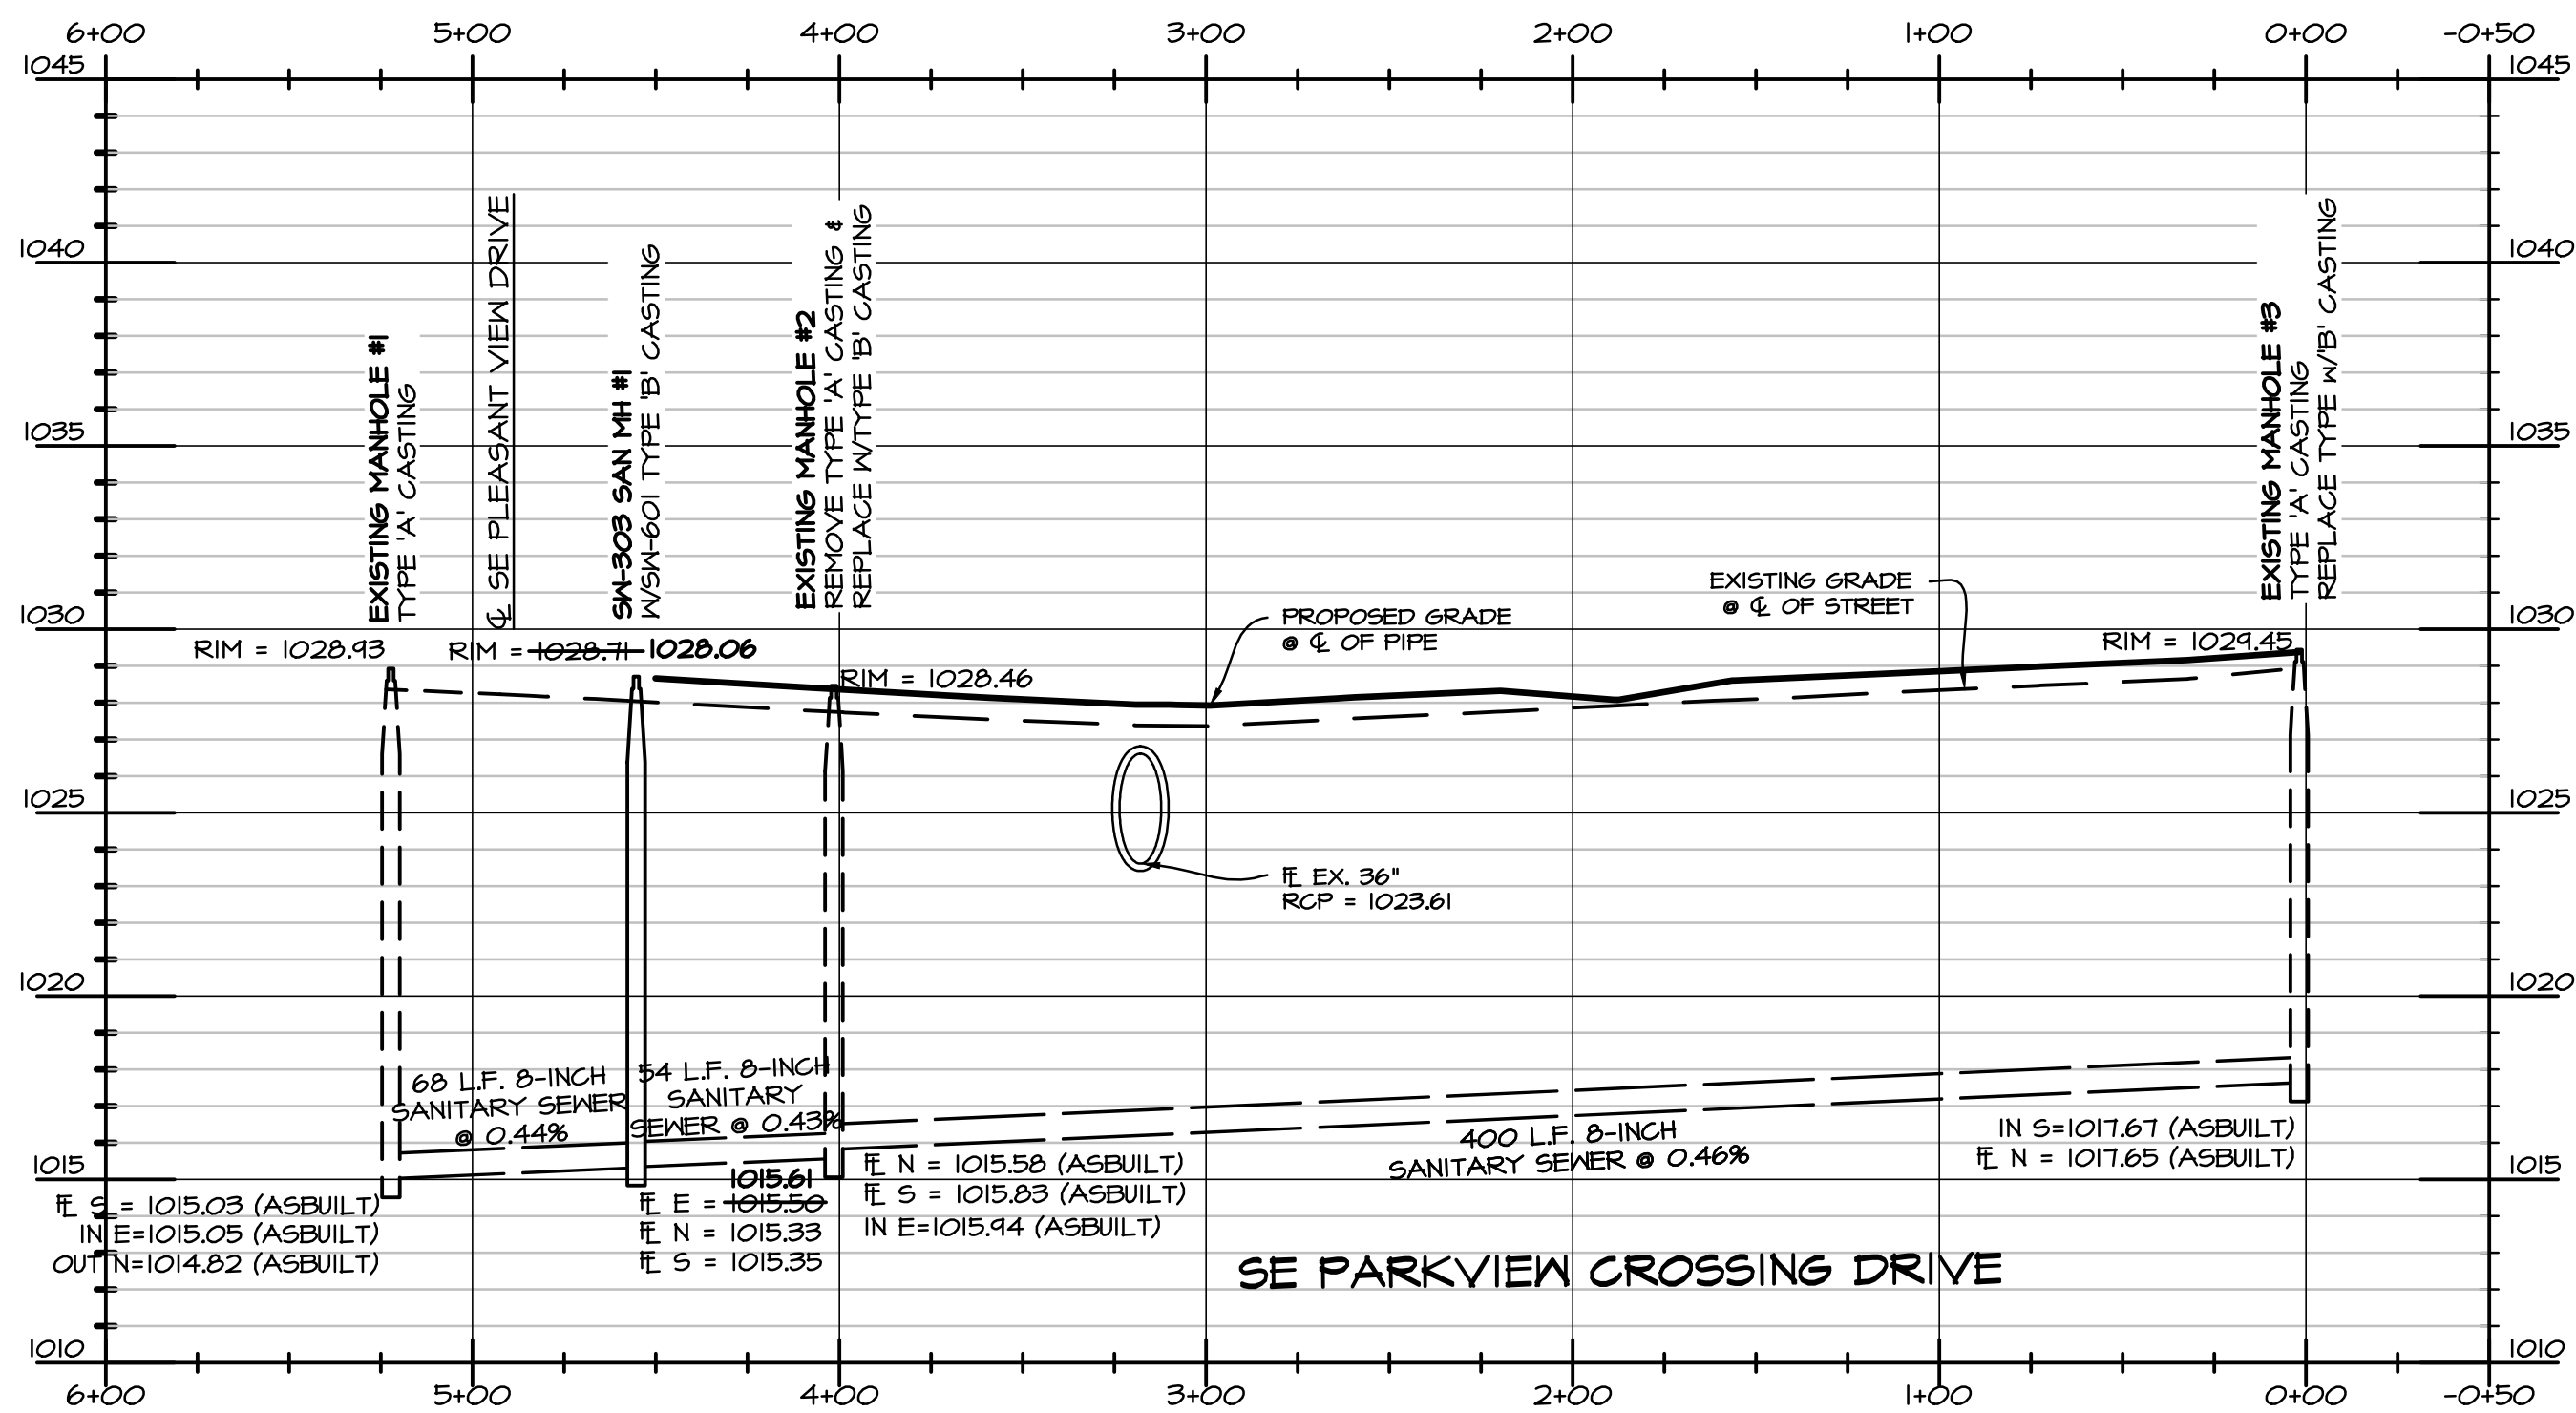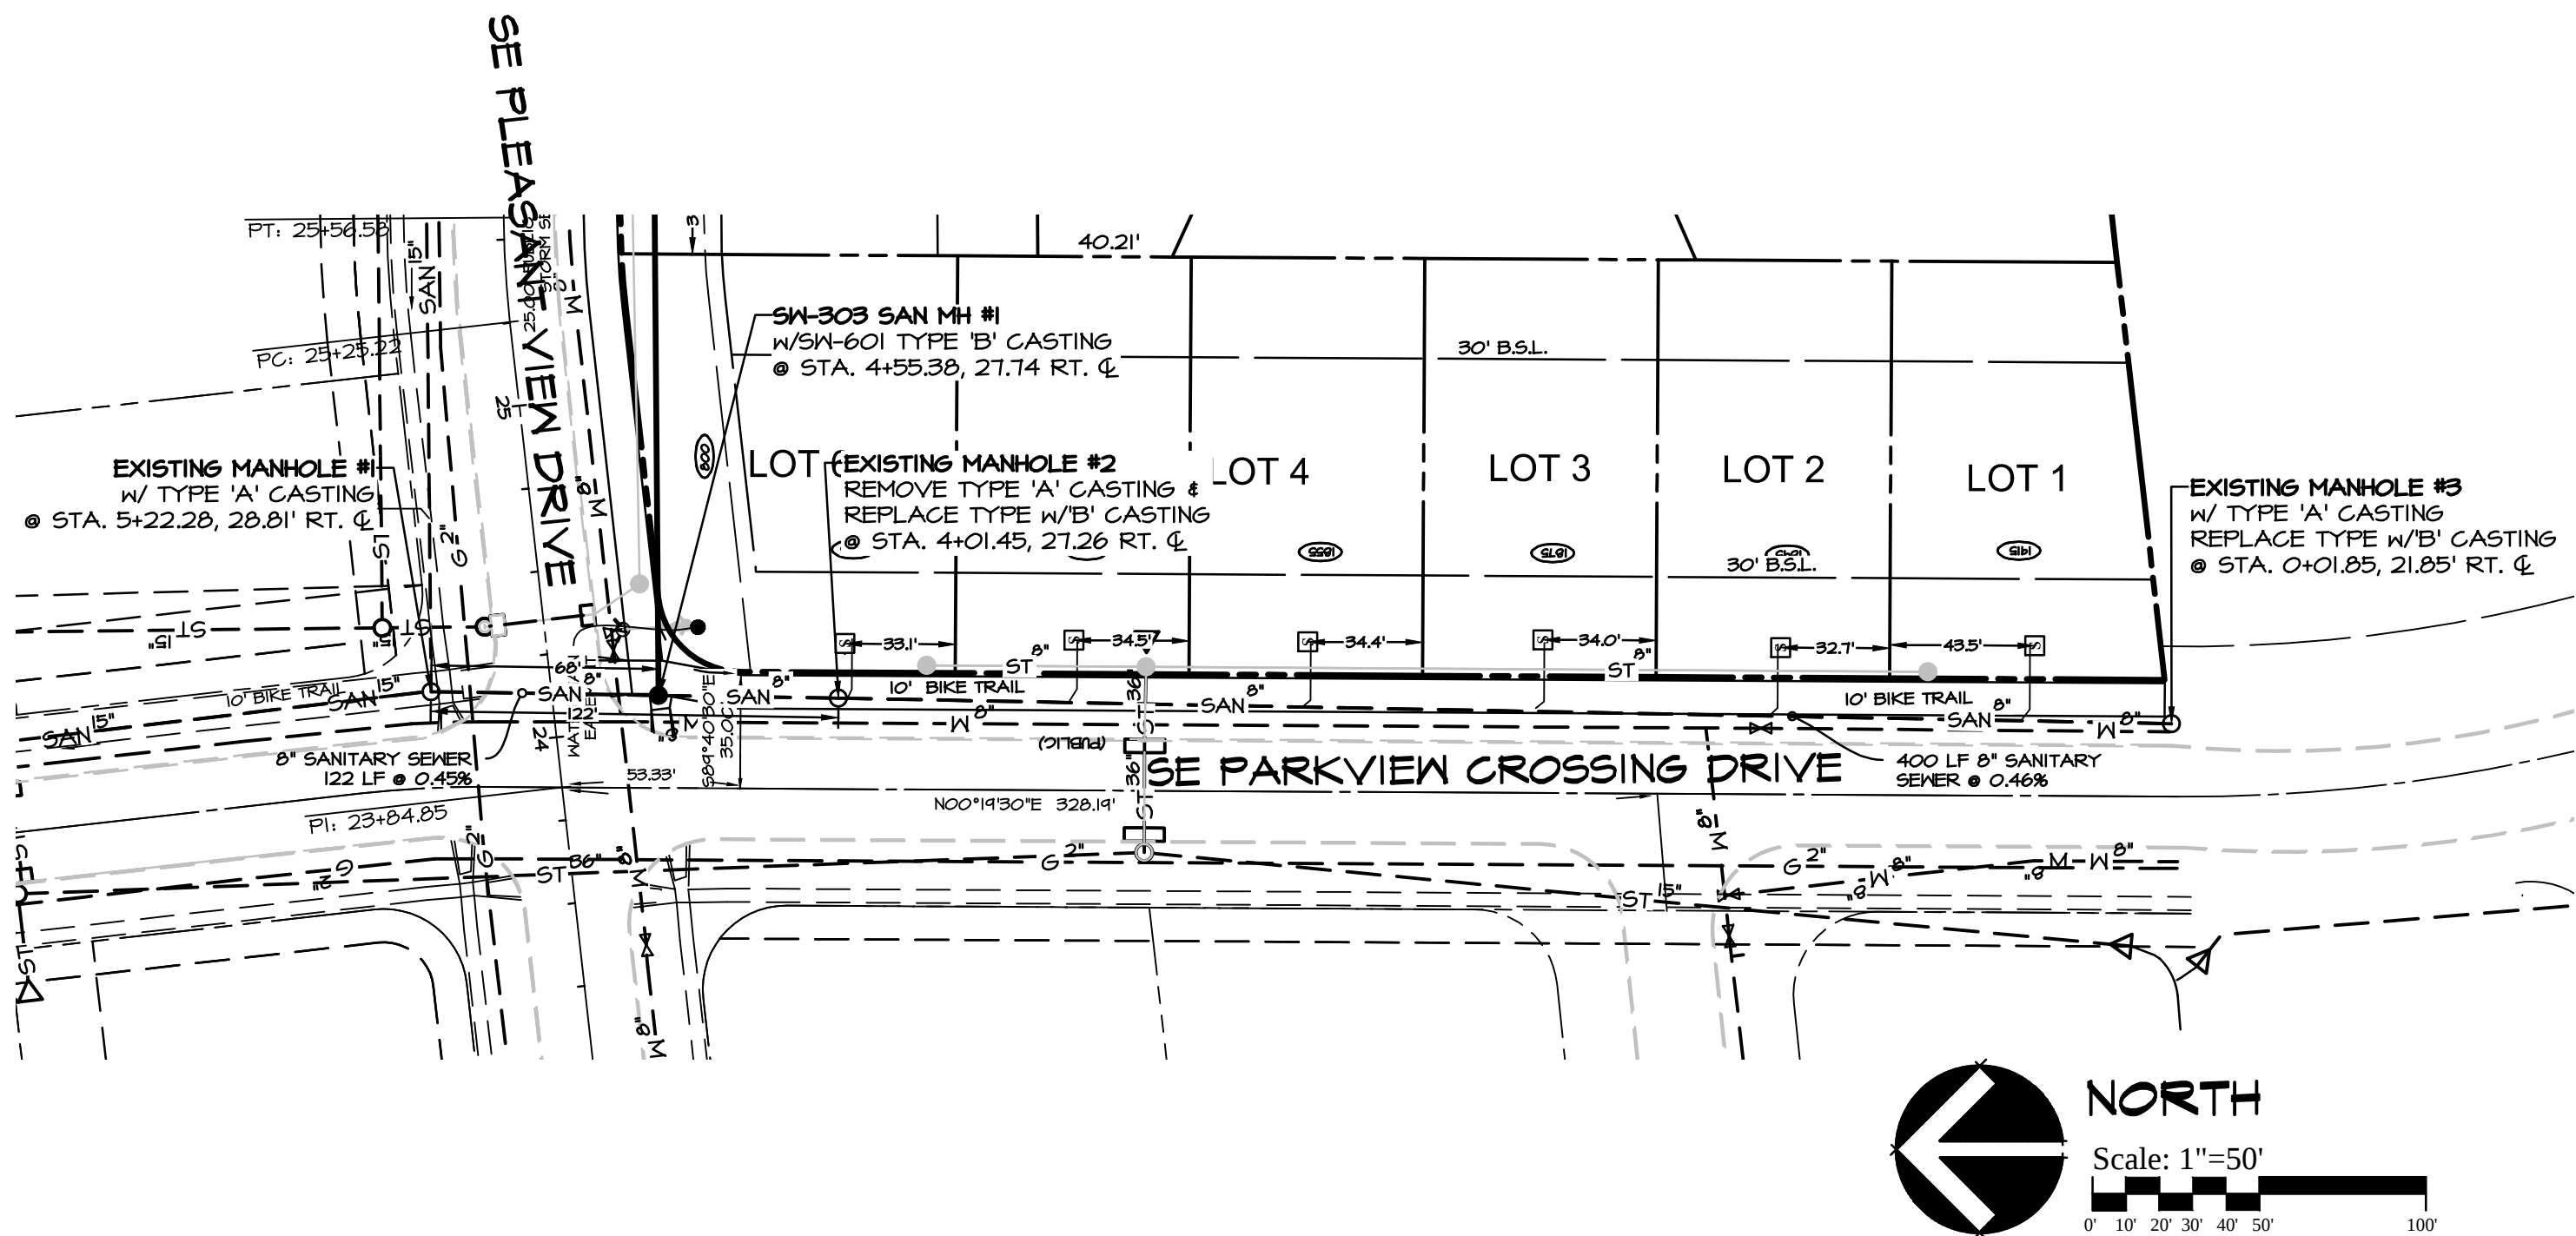

- LEGEND**
- EXISTING/PROPOSED
- PLAT BOUNDARY
 - SAN 8" SANITARY SEWER & SIZE
 - ST 18" STORM SEWER & SIZE
 - W 8" WATER MAIN & SIZE
 - MANHOLE
 - STORM INTAKE
 - FIRE HYDRANT
 - VALVE
 - SERVICE CONNECTION
 - B.S.L. BUILDING SETBACK LINE
 - H.S.L. HOUSE SETBACK LINE
 - G.S.L. GARAGE SETBACK LINE

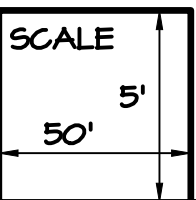

DATE: 11-26-2013
REVISION: 12-18-2013
01-08-2014
01-30-2014

SHEET
3
OF 9


ASBUILT 7-31-2015



Civil Engineering Consultants, Inc.
2400 86th Street . Unit 12 . Des Moines, Iowa 50322
515.276.4884 . Fax: 515.276.7084 . mail@ceclac.com



PLAN & PROFILE SANITARY SEWER
PARKVIEW CROSSING PLAT II
JERRY'S HOMES, INC., 10430 NEW YORK AVE SUITE C, URBANDALE, IA 50322

Q:\E-FILES\16-0000\ASBUILTS\6653 CD-ASBUILTS\6653 02-WTR ASBUILT.dwg, 7/30/2015 12:48:38 PM, jsmith

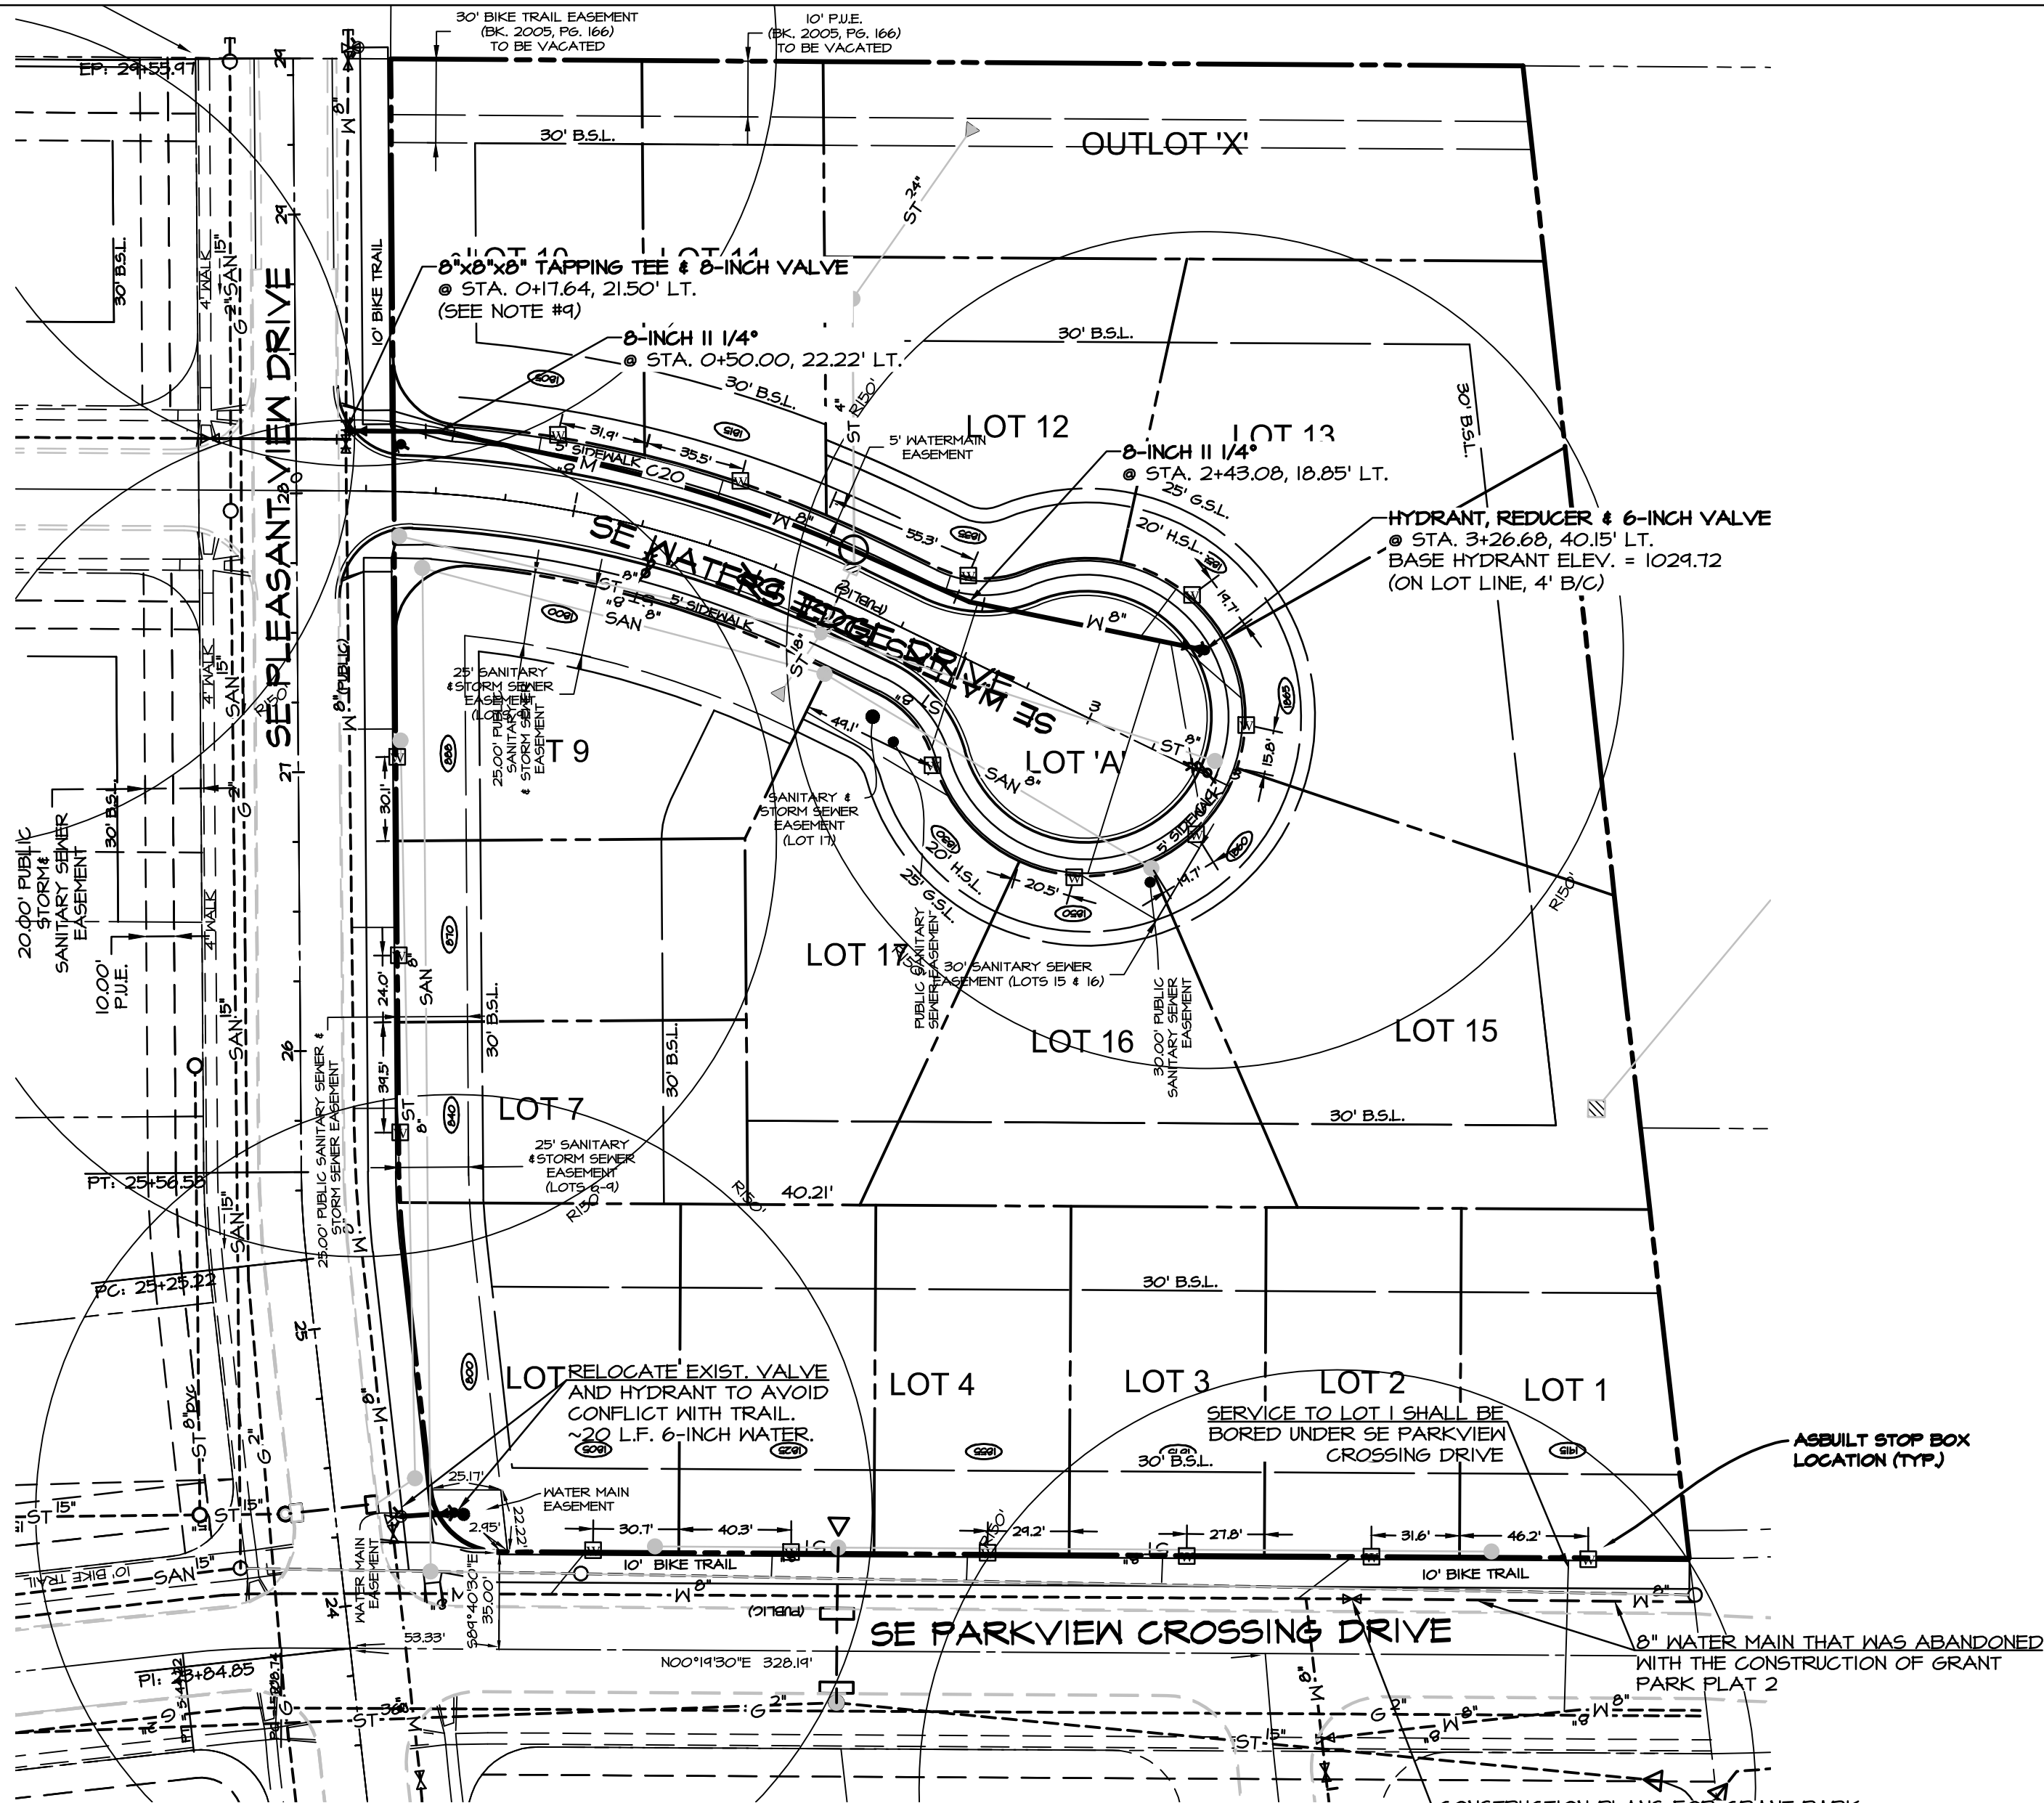


- NOTES**
1. PIPE MATERIALS: DUCTILE IRON IN ACCORDANCE WITH STANDARD SPECIFICATIONS OR ANNA C400 DR - 18" PVC INSTALL NO. 10 THIN STANDARD COPPER TRACER WIRE TO SURFACE AT FIRE HYDRANTS. CONNECT NEW TRACER TO EXISTING.
 2. THE CONTRACTOR SHALL PROTECT AND BACKFILL AROUND ALL UTILITIES AND STRUCTURES. BACKFILL SHALL BE IN 6-INCH LAYERS AND COMPACTED TO 95% STANDARD PROCTOR DENSITY, ± 0% TO +4% OPTIMUM MOISTURE CONTENT.
 3. HYDRANTS, MANHOLE COVERS AND VALVE BOXES SHALL BE SET TO CONFORM TO FINISHED PAVEMENT ELEVATIONS.
 4. SERVICES TO BE 1-INCH COPPER, STOP BOXES TO BE MUELLER H-10300 OR EQUAL.
 5. THE CONTRACTOR SHALL BE RESPONSIBLE FOR RECORDING THE AS-BUILT LOCATION OF ALL WATER SERVICES AND PROVIDING THIS INFORMATION TO THE ENGINEER.
 6. HYDRANTS SHALL BE SET NOT MORE THAN 4 FEET FROM MAIN.
 7. AN APPROVED SADDLE SHALL BE USED FOR ALL WATER SERVICE TAPS.
 8. CONTRACTOR SHALL USE A 4" LOCKING STORZ CONNECTION IN PLACE OF THE NST STEAMER ON ALL NEW HYDRANTS.
 9. LOCATE EXISTING 8"x8"x8" TEE TO NORTH PRIOR TO CONSTRUCTION. LOCATE NEW 8"x8"x8" TAPPING TEE & SLEEVE A MINIMUM OF 3 FEET FROM THE EXISTING TEE.
 10. MINIMUM BURY DEPTH OF WATER MAIN SHALL BE SIX FEET.

QUANTITIES	
320 L.F.	8-INCH WATER MAIN
1 EA.	HYDRANT, REDUCER & 6-INCH VALVE
1 EA.	8"x8"x8" TAPPING TEE & 8-INCH VALVE
2 EA.	11 1/4" BEND
17 EA.	SERVICES (LOT 1 SERVICE TO BE BORED UNDER STREET)
20 L.F.	6-INCH WATER MAIN (FOR HYDRANT RELOCATION)

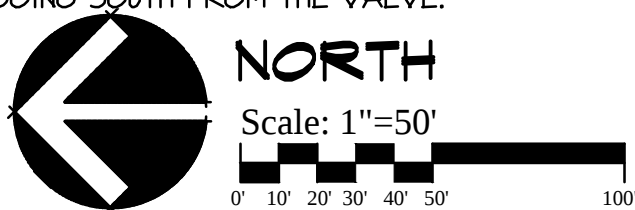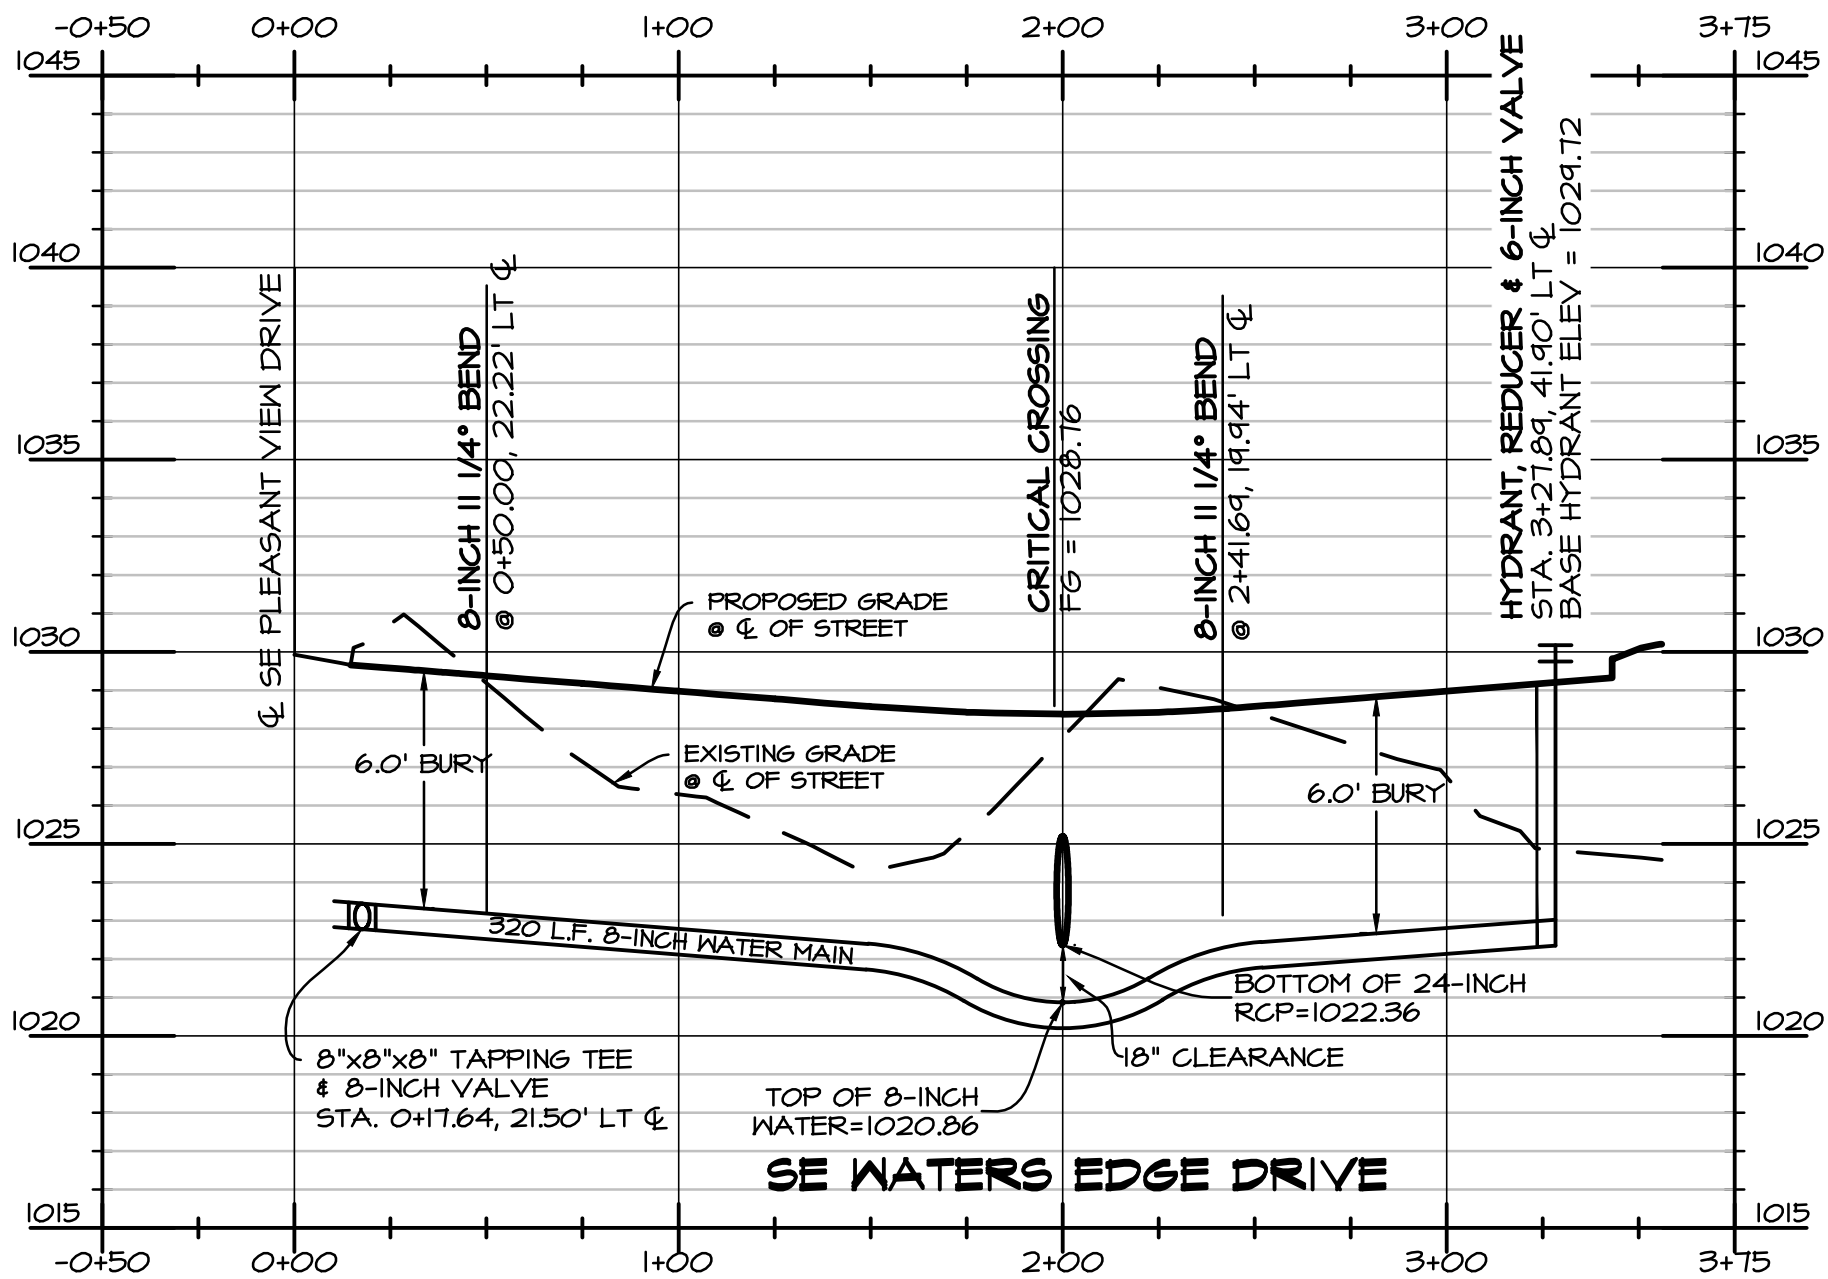

LEGEND

EXISTING/PROPOSED	
---	PLAT BOUNDARY
--- SAN 8"	SANITARY SEWER & SIZE
---	STORM SEWER & SIZE
--- W 8"	WATER MAIN & SIZE
○	MANHOLE
□	STORM INTAKE
⊕	FIRE HYDRANT VALVE
⊕	SERVICE CONNECTION

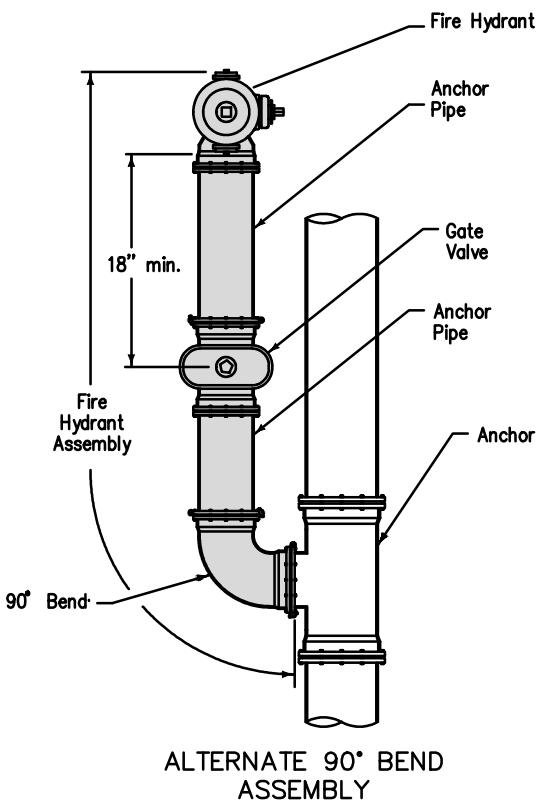

Use ductile iron pipe with restrained mechanical joints for fire hydrant assembly and anchor tee.
① Do not cover drain holes or tracer wire.

SUDAS	DESIGN	DATE
FIGURE 5020.201	WM-201	11-18-13
STANDARD ROAD PLAN	SHEET 1 OF 1	
REVISIONS: Standard Notes 1 and references, reworked Note 2, and deleted "Top of the Street"		
SCALE:	DATE:	REVISION:

DATE: 11-26-2013
REVISION: 12-18-2013
01-08-2014
01-30-2014

SCALE
50'
5'

SHEET
4
OF 8

ASBUILT 7-31-2015





Civil Engineering Consultants, Inc.
2400 86th Street, Unit 12 • Des Moines, Iowa 50322
515.276.4884 • Fax: 515.276.7084 • mail@ceclac.com

PLAN & PROFILE WATER MAIN
PARKVIEW CROSSING PLAT II
JERRY'S HOMES, INC., 10430 NEW YORK AVE SUITE C, URBANDALE, IA 50322



E-6653

- NOTES
1. CONTRACTOR SHALL BE RESPONSIBLE FOR RECORDING AS-BUILT LOCATIONS OF ALL STORM SEWER SERVICES AND PROVIDE THIS INFORMATION TO THE ENGINEER.
 2. CONTRACTOR SHALL BE RESPONSIBLE FOR REPAIRING ANY FARM TILE DAMAGE DURING CONSTRUCTION AND RECORDING LOCATION OF TILE.
 3. A GEOTECHNICAL REPORT FOR THIS PROJECT CAN BE OBTAINED BY CONTACTING THE OWNER.
 4. INTAKE & CASTING TYPES LISTED ARE PER THE CURRENT EDITION OF THE IOWA S.D.A.S. SPECS.
 5. PROVIDE APRON GUARDS & CONCRETE FOOTINGS ON ALL FLARED END SECTIONS. CONTRACTOR SHALL TIE THE LAST THREE PIPE JOINTS AT THE FLARED END SECTION.
 6. ALL STORM SEWER TO BE CLEANED AND VIDEO TAPED UPON COMPLETION.
 7. CONTRACTOR SHALL INSTALL TRACER WIRE FOR ALL STORM SEWER INSTALLATIONS.
 8. 8-INCH PERFORATED A2000 PIPE SHALL BE USED FOR SUMP COLLECTOR LINES

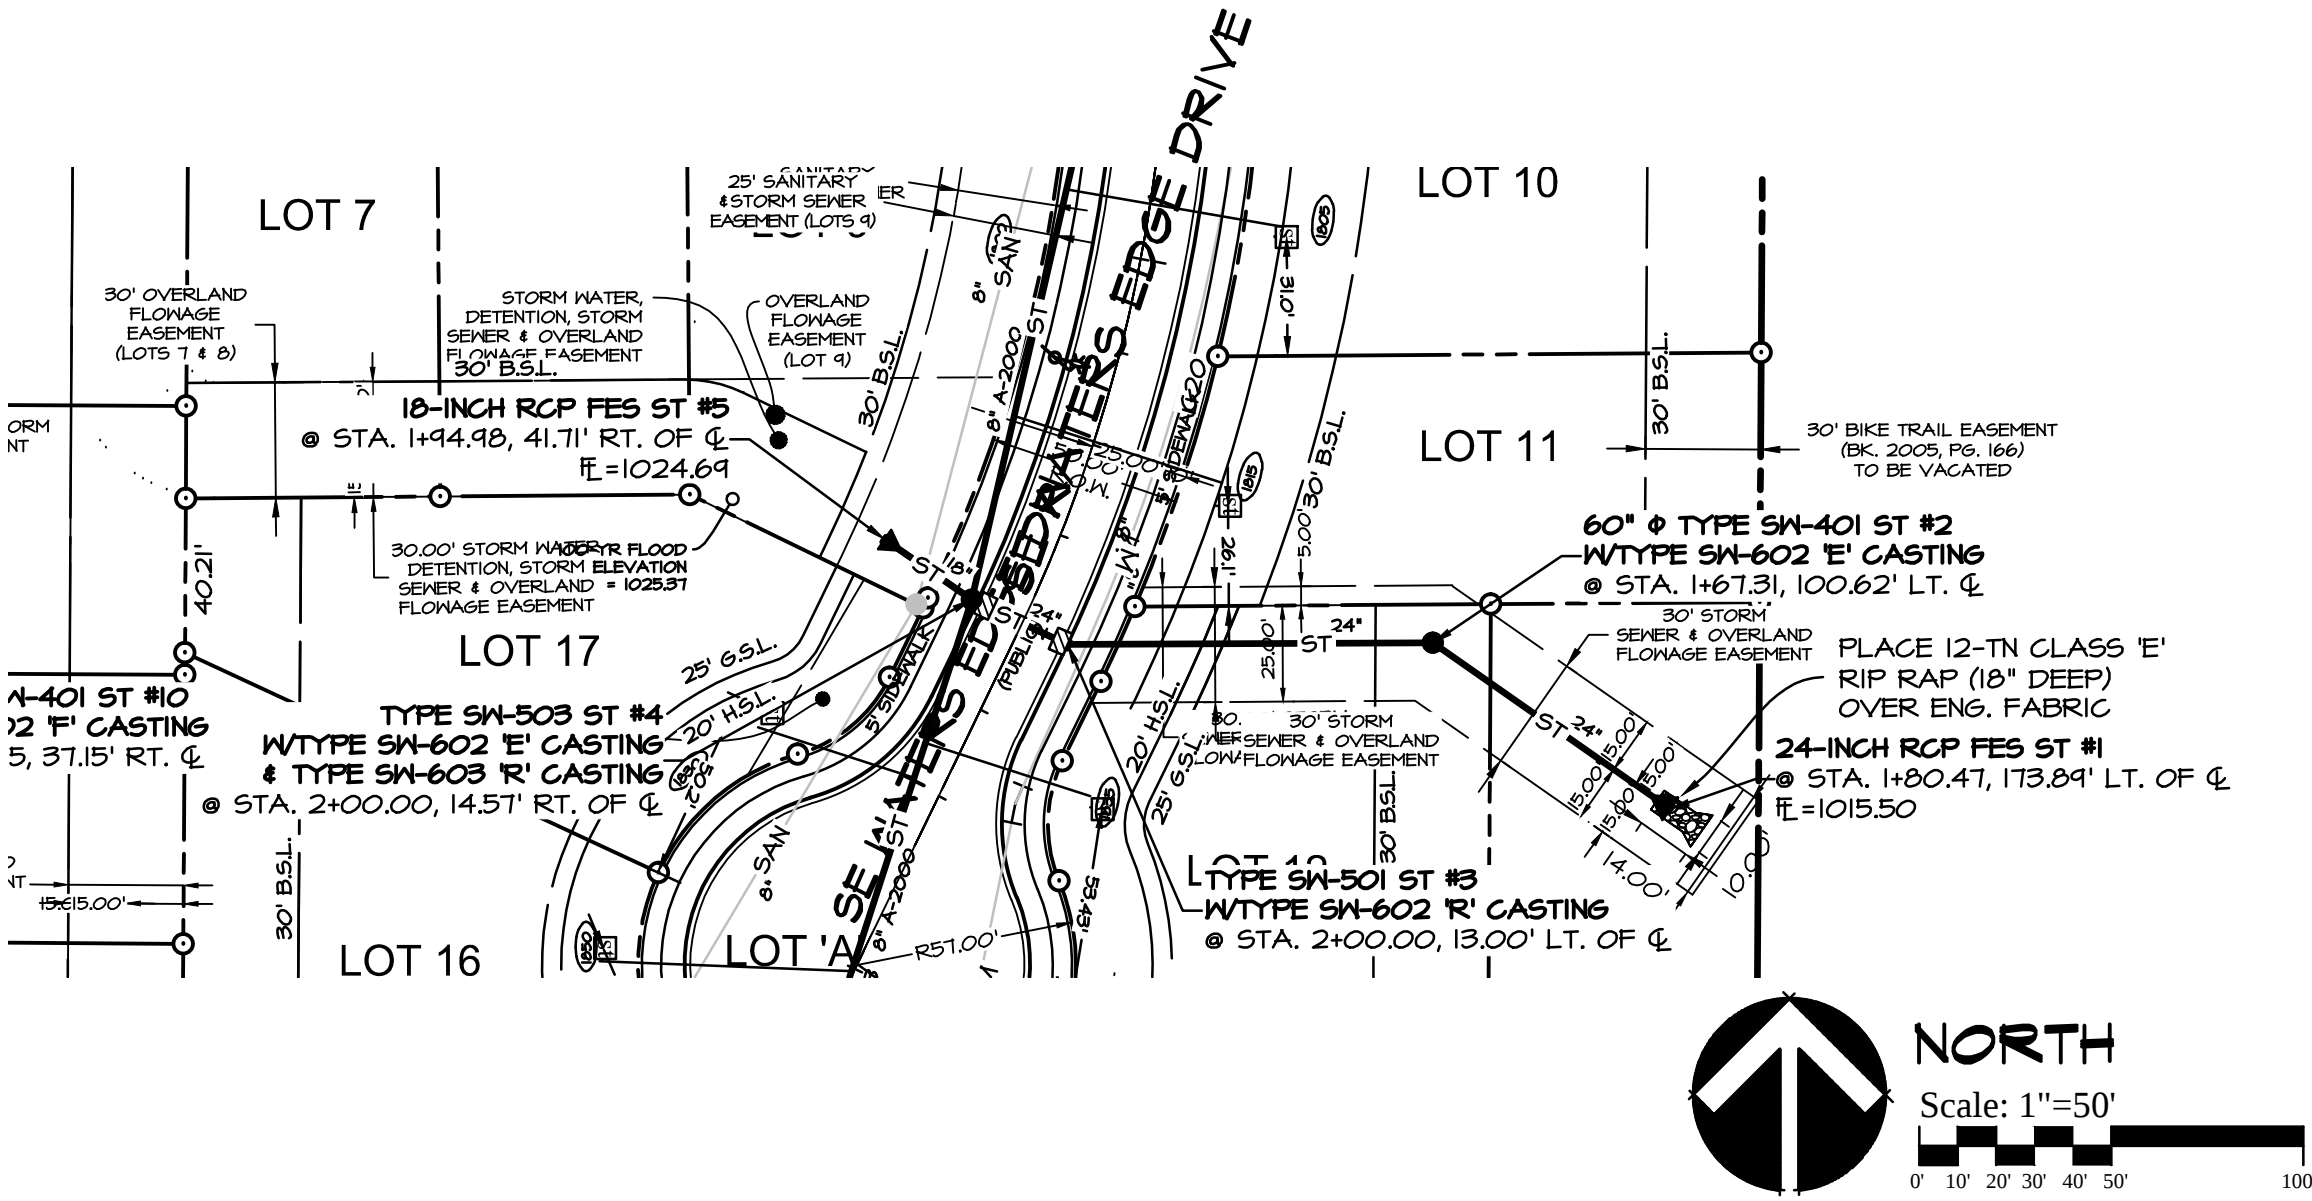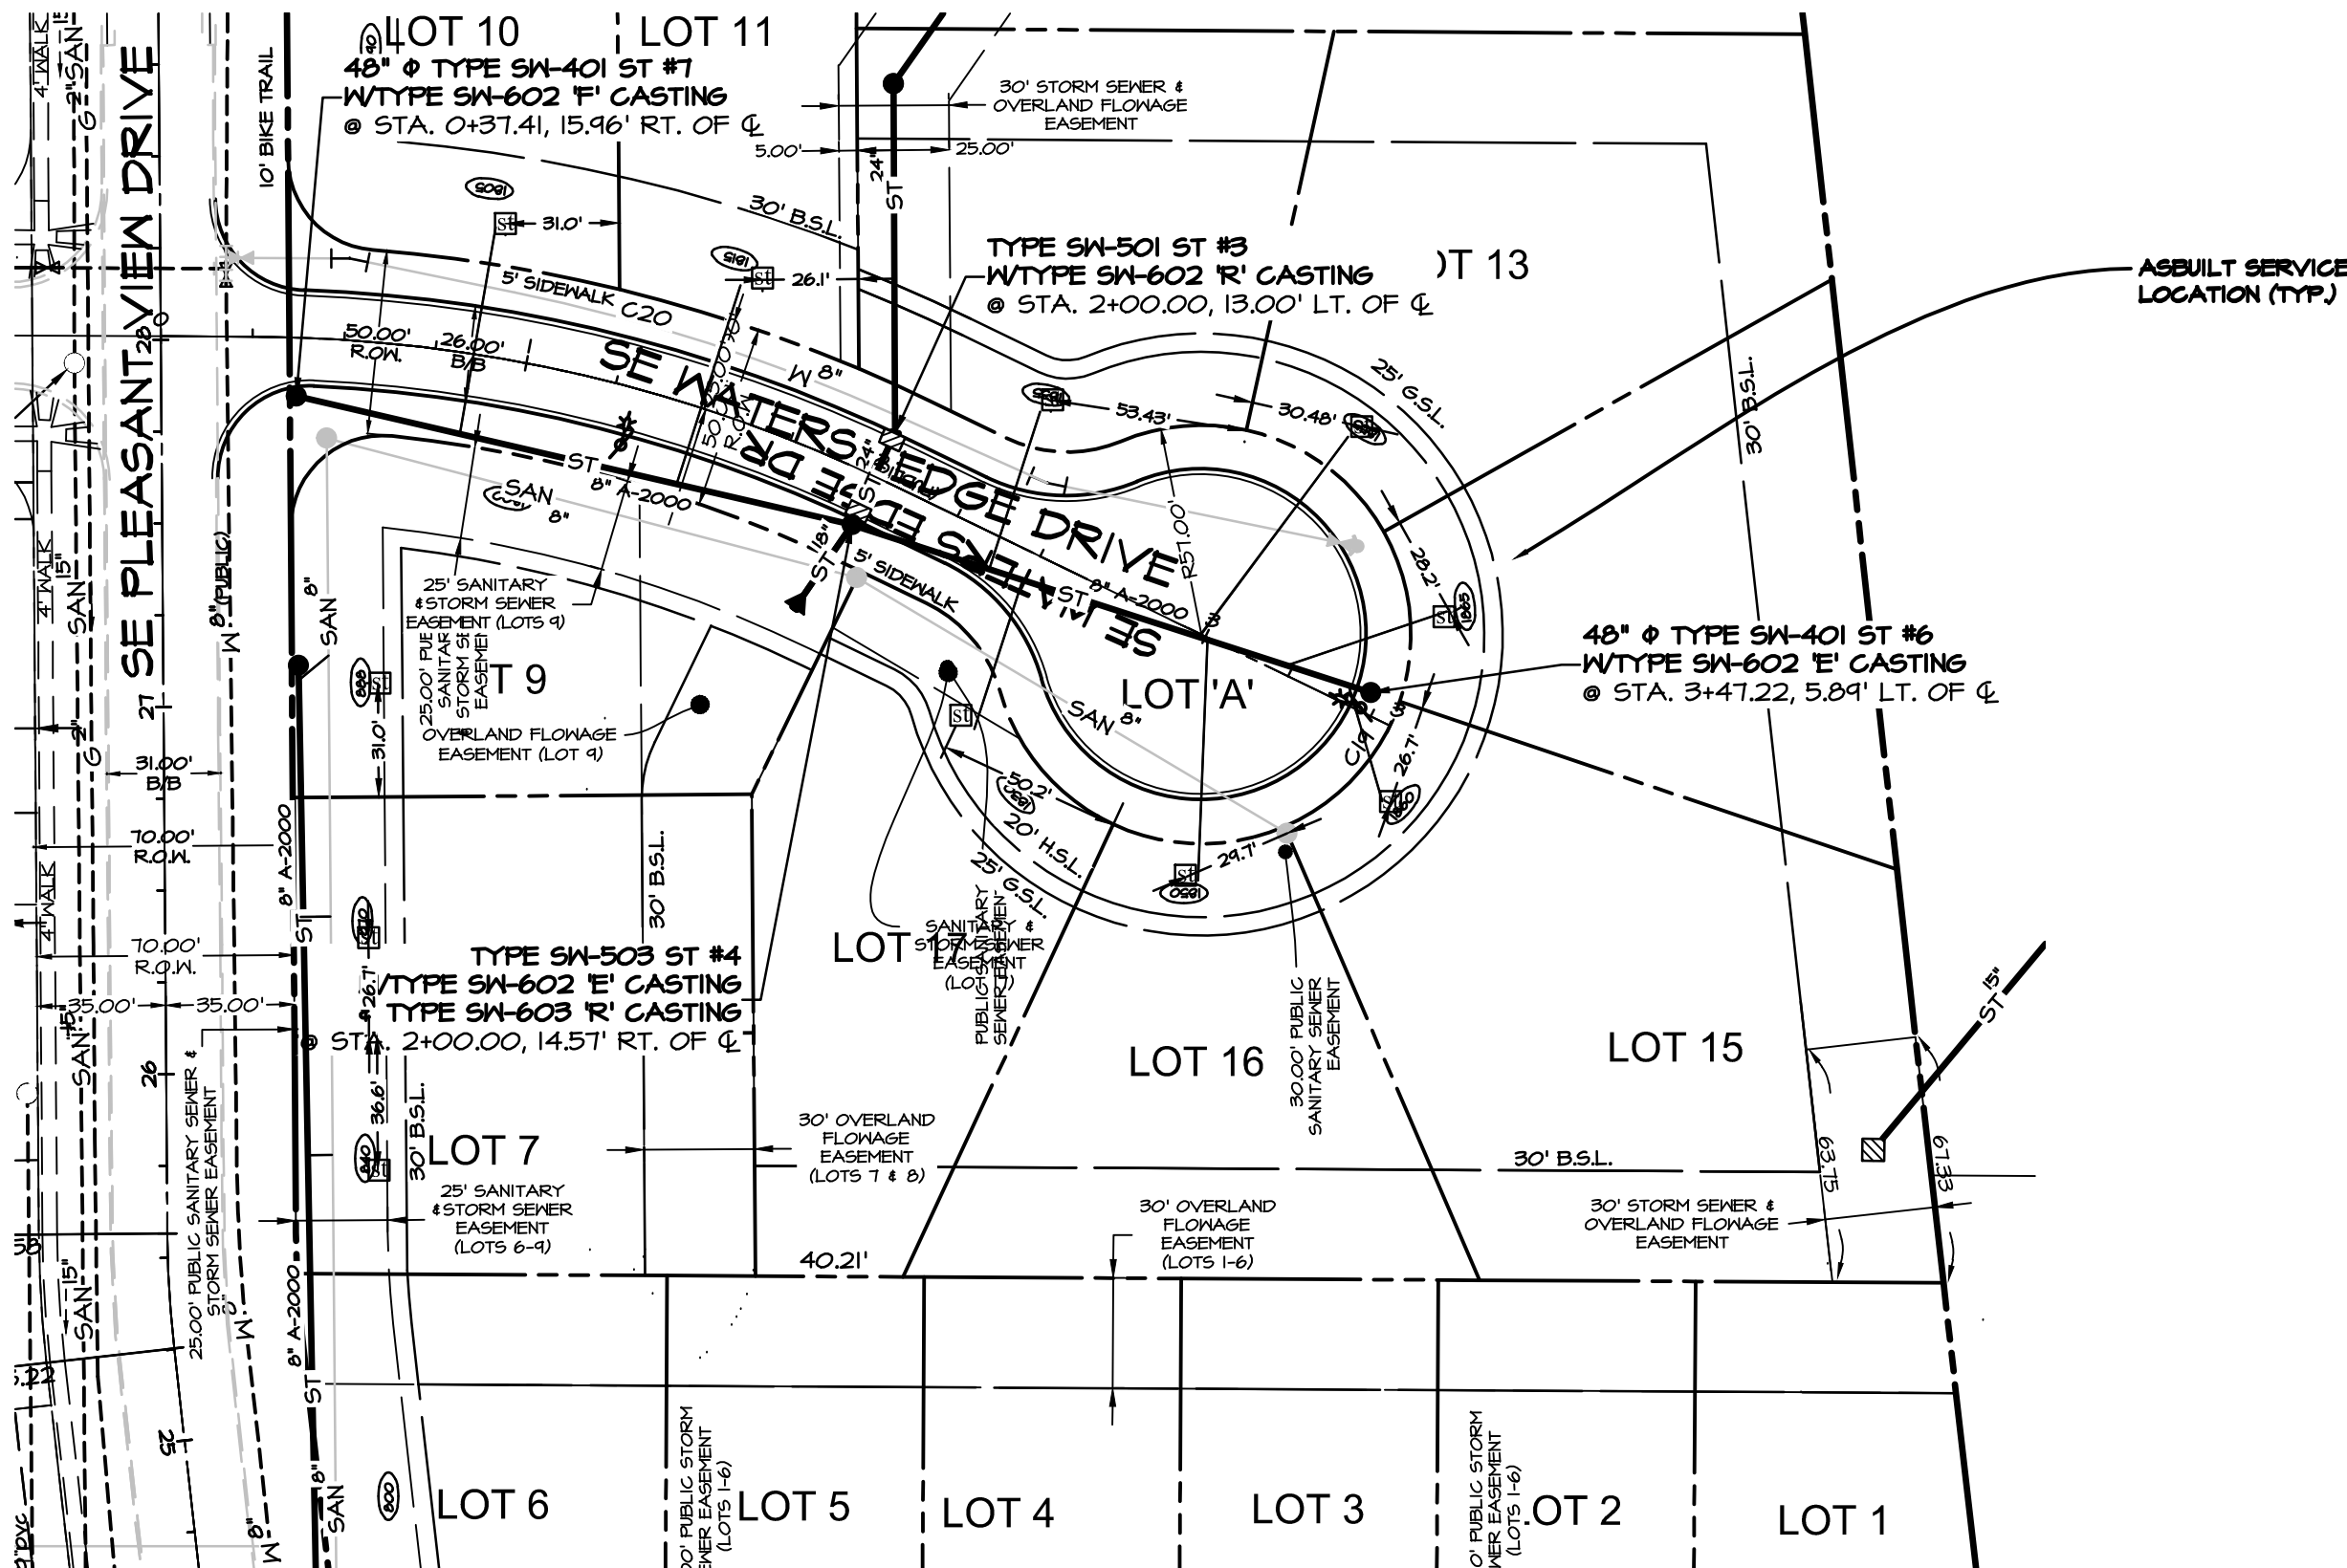


QUANTITIES

196 L.F.	24-INCH RCP CLASS III
28 L.F.	18-INCH RCP CLASS III
154 L.F.	15-INCH RCP CLASS III
868 L.F.	8-INCH PERFORATED A2000 PIPE
1 EA.	15-INCH RCP FES
1 EA.	18-INCH RCP FES
1 EA.	24-INCH RCP FES
2 EA.	48" DIA. SM-401 MANHOLE W/SM-602, TYPE 'E' CASTING
5 EA.	48" DIA. SM-401 MANHOLE W/SM-602, TYPE 'F' CASTING
1 EA.	60" DIA. SM-401 MANHOLE W/SM-602, TYPE 'F' CASTING
1 EA.	SM-503 INTAKE W/SM-603, TYPE 'R' CASTING
1 EA.	SM-501 INTAKE W/SM-603, TYPE 'R' CASTING
1 EA.	SM-513 INTAKE W/SM-602, TYPE 'G' CASTING
24 TONS	CLASS 'E' RIP RAP
17 EA.	SERVICES
10.5 L.F.	REMOVE 36" RCP (INCLUDES FES)

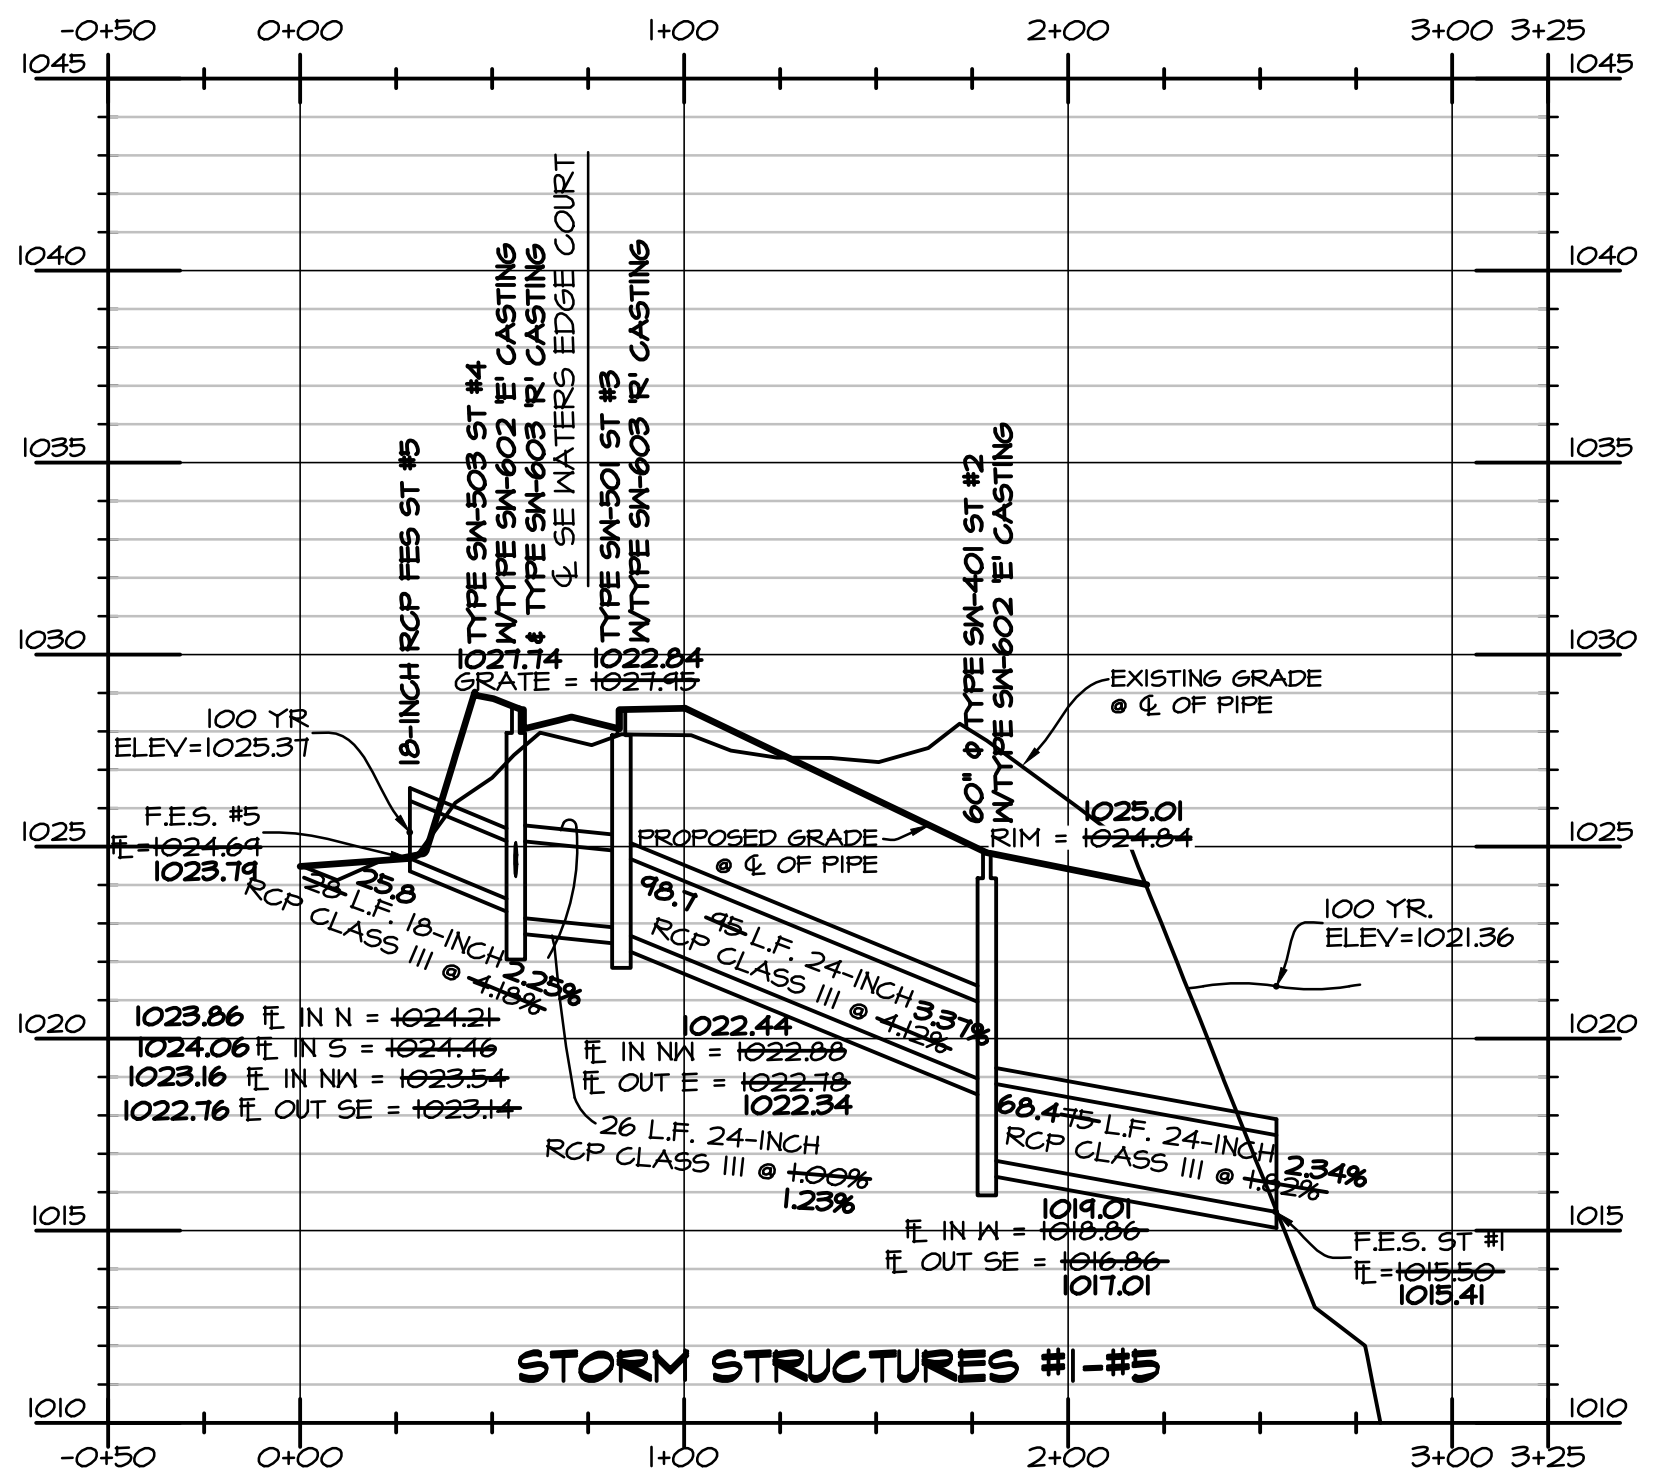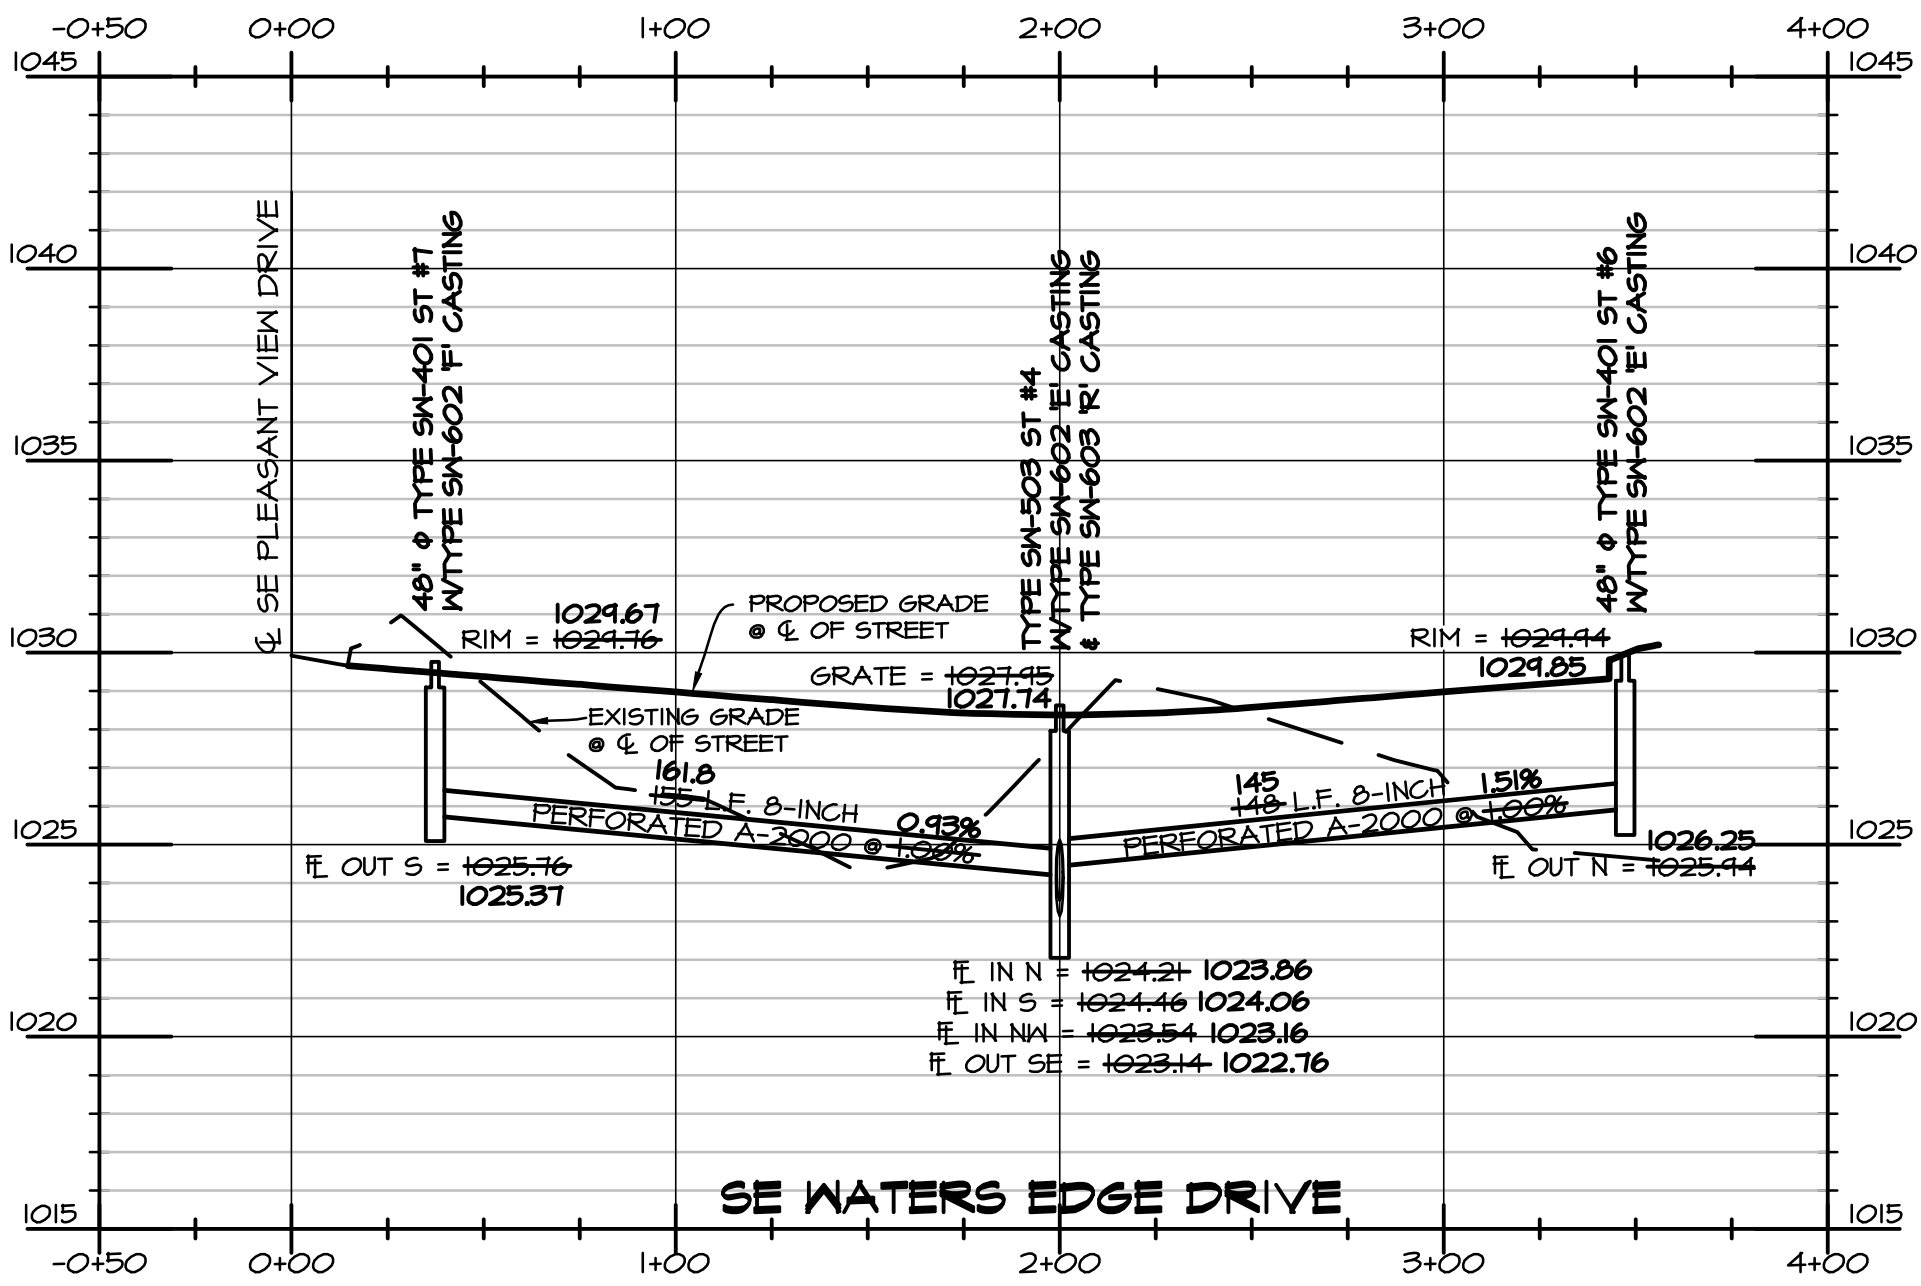

LEGEND










EXISTING/PROPOSED	FLAT BOUNDARY
— SAN 8"	SANITARY SEWER & SIZE
— W 8"	STORM SEWER & SIZE
— W 8"	WATER MAIN & SIZE
○	MANHOLE
□	STORM INTAKE
✕	FIRE HYDRANT
✕	VALVE
✕	SERVICE CONNECTION

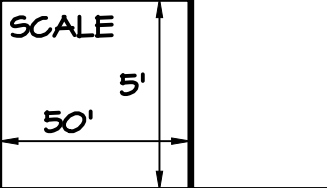

DATE: 11-26-2013
REVISION: 12-18-2013
01-08-2014
01-30-2014

SHEET
5
OF 9

ASBUILT 7-31-2015

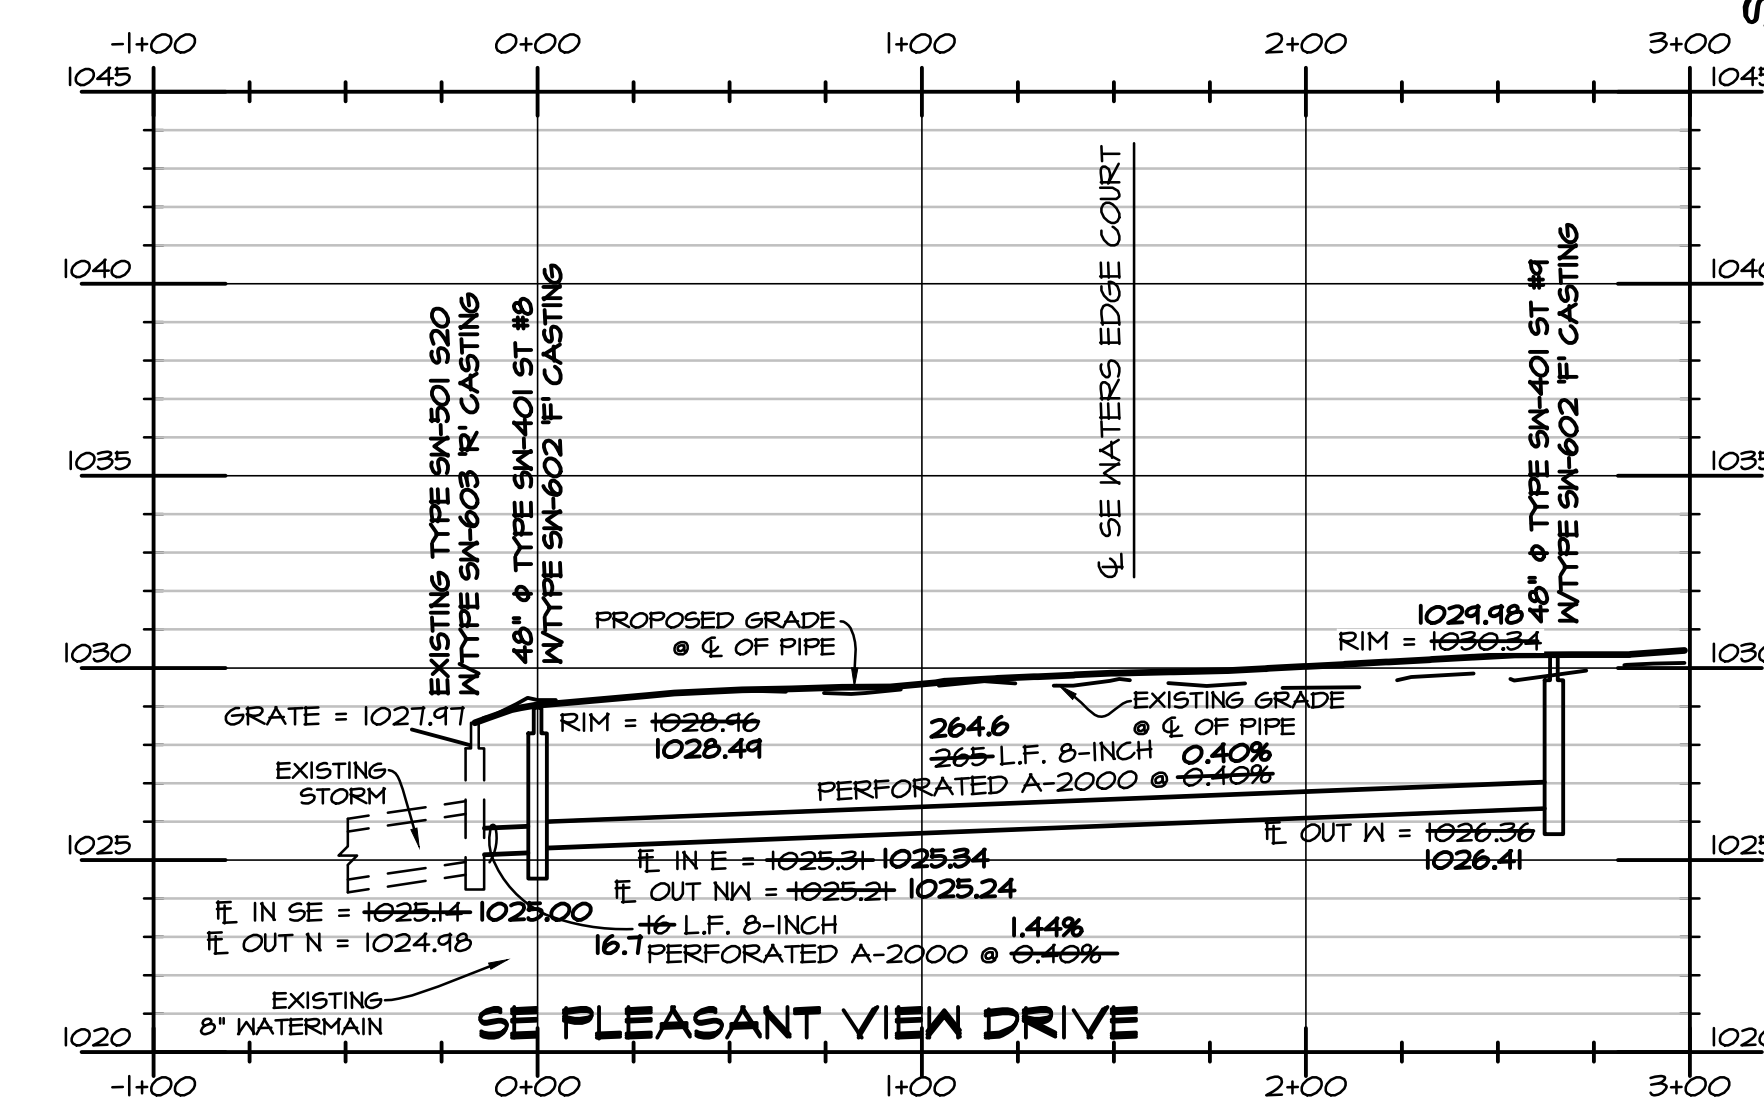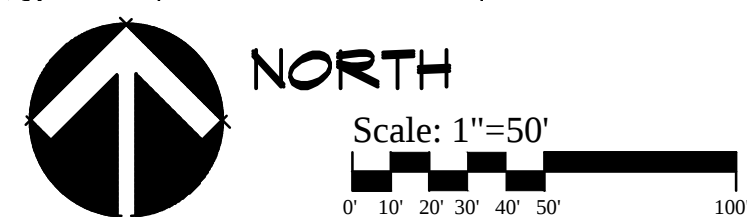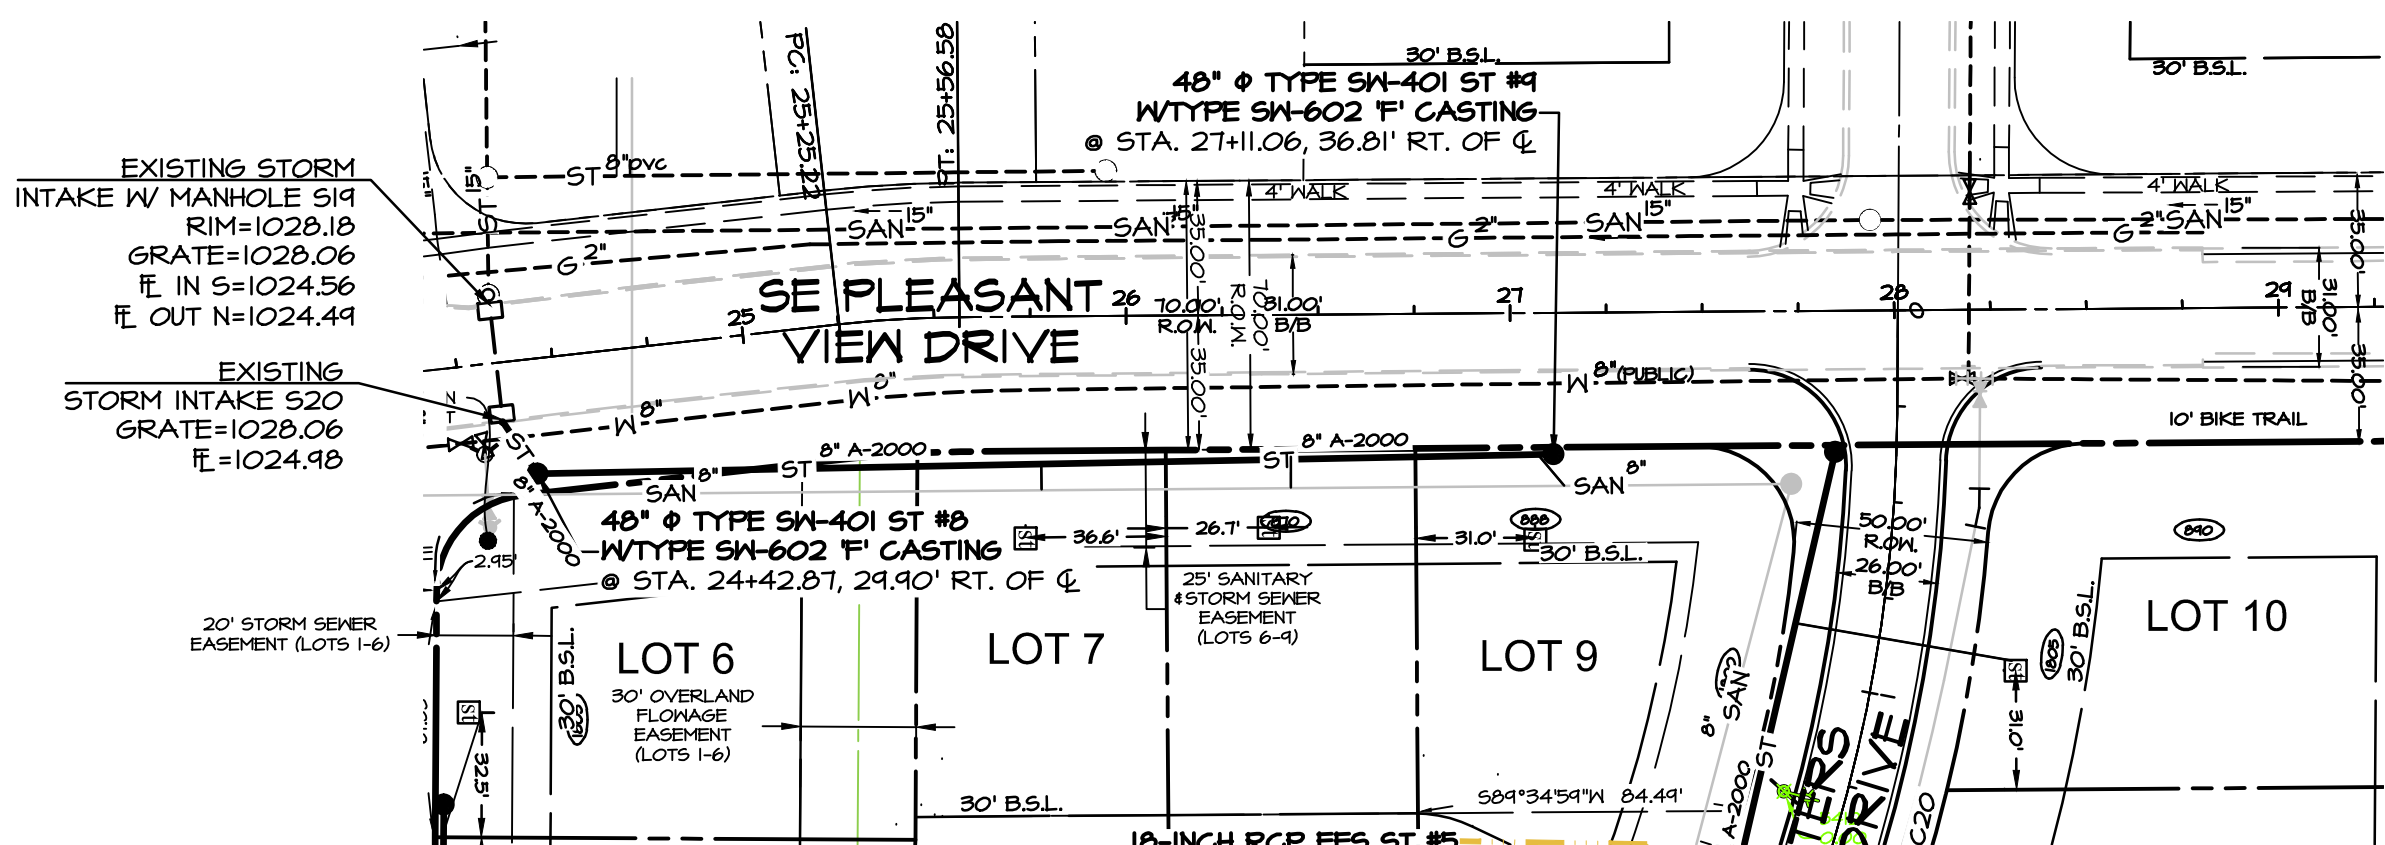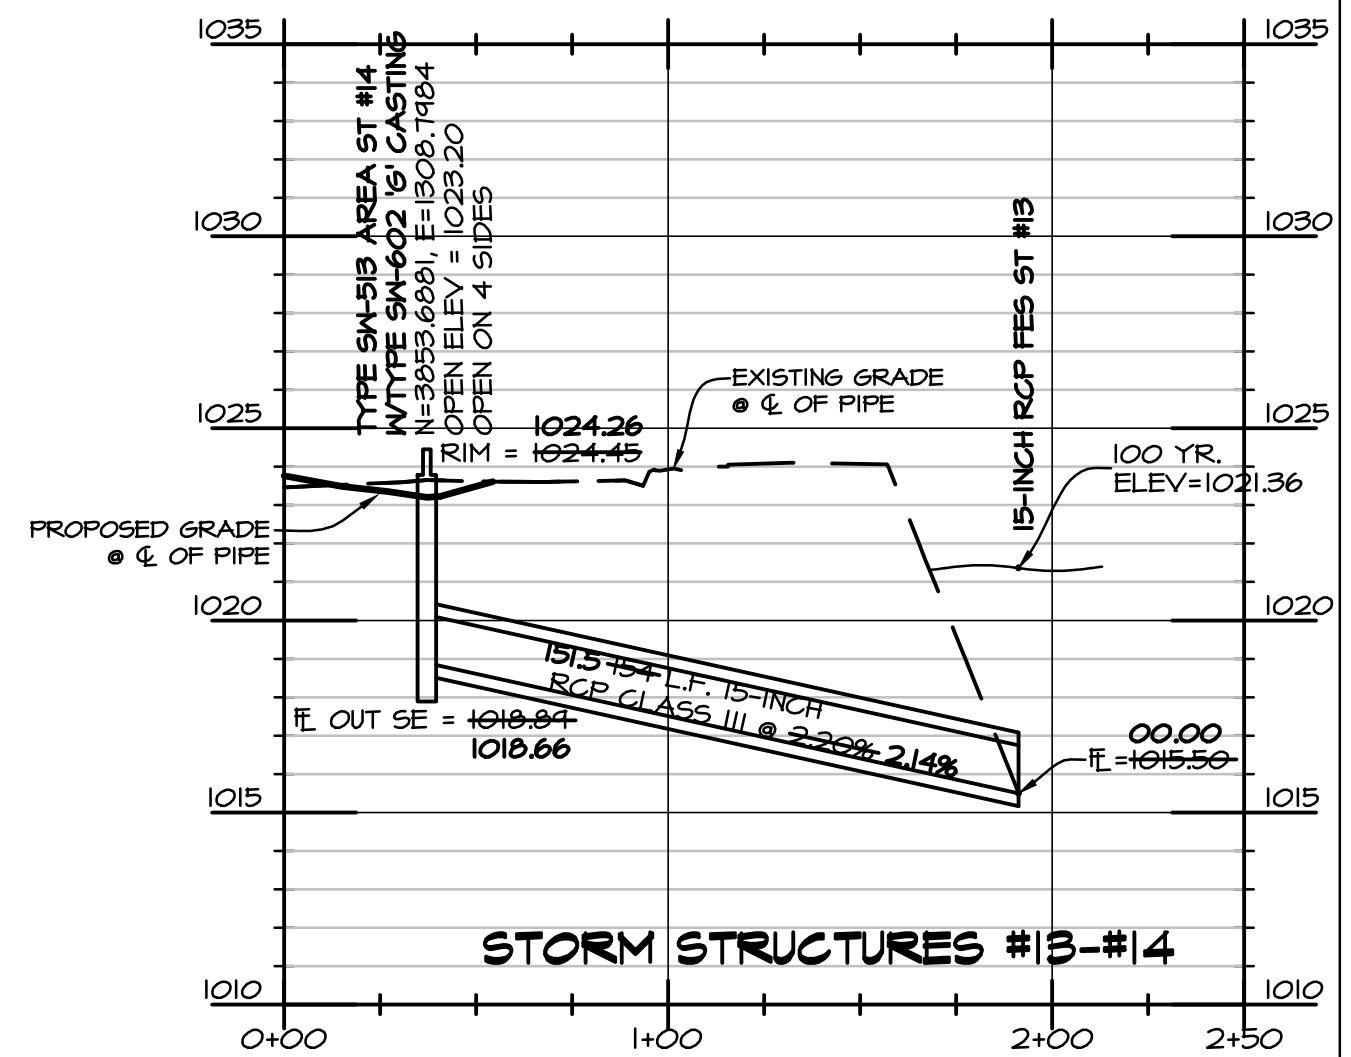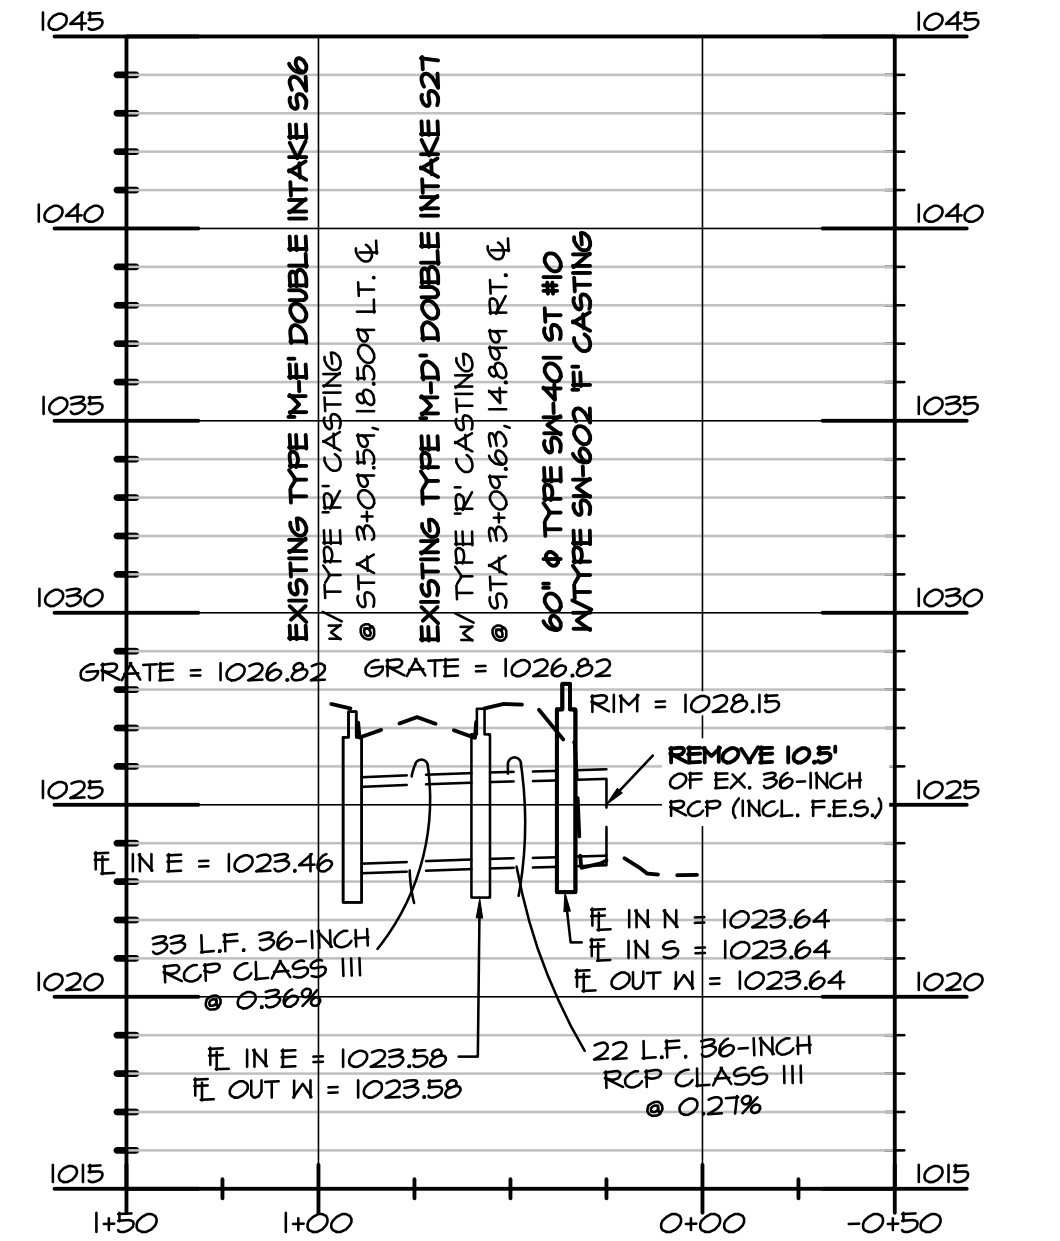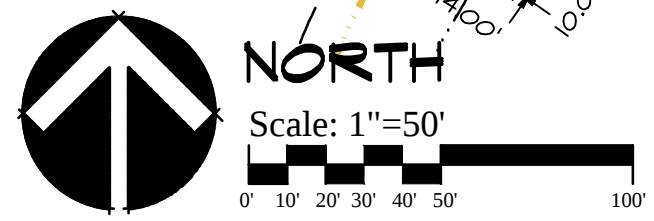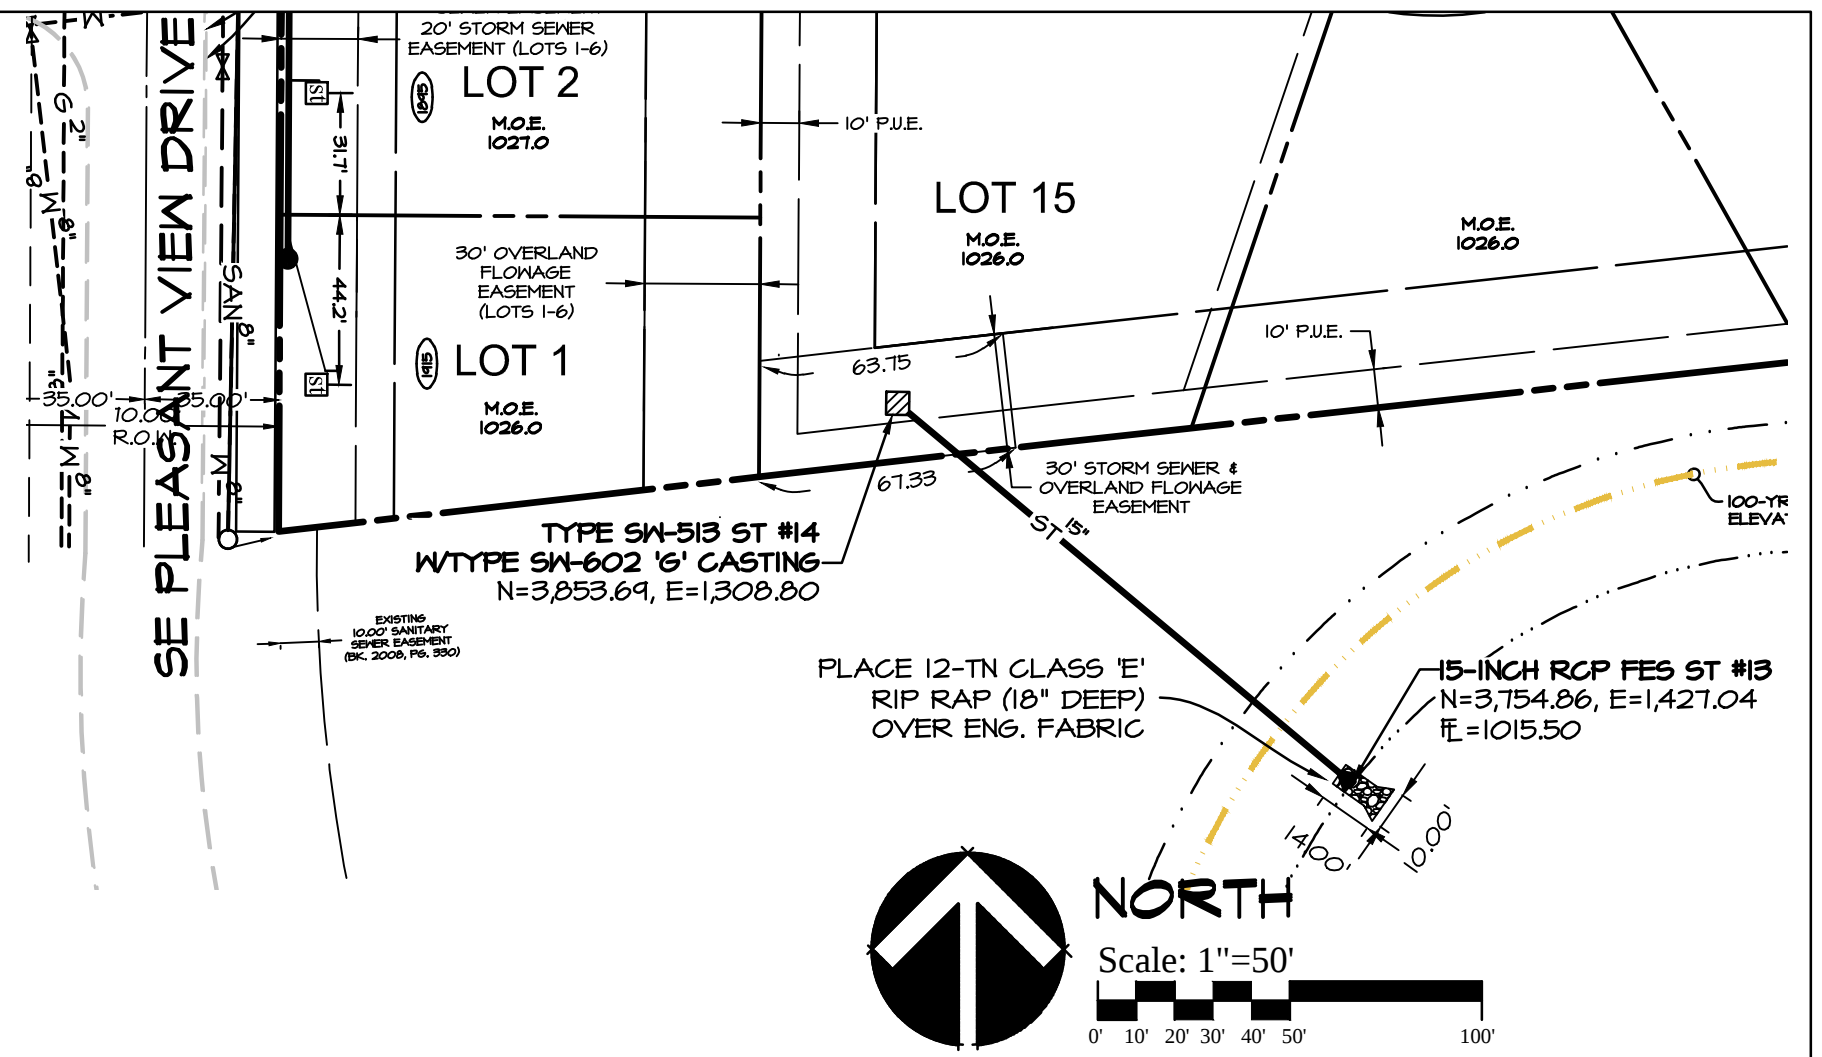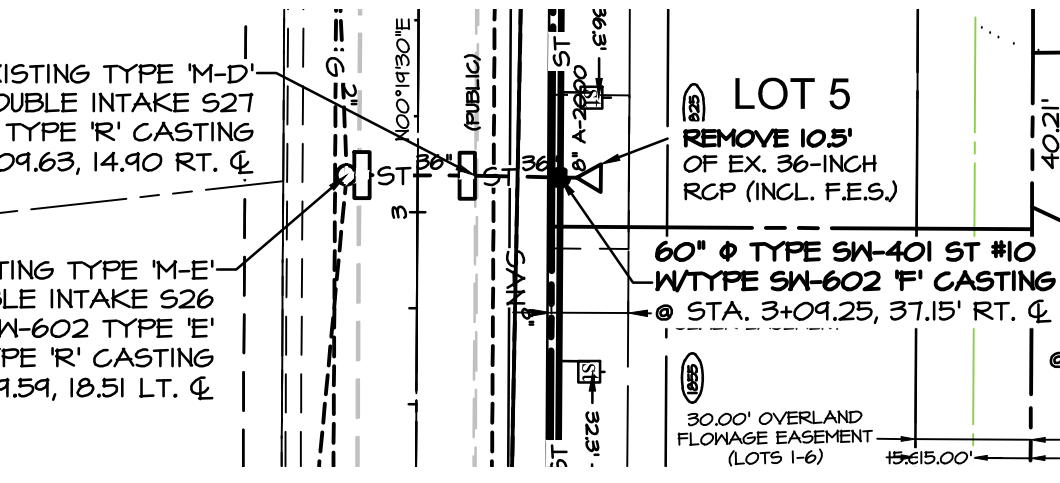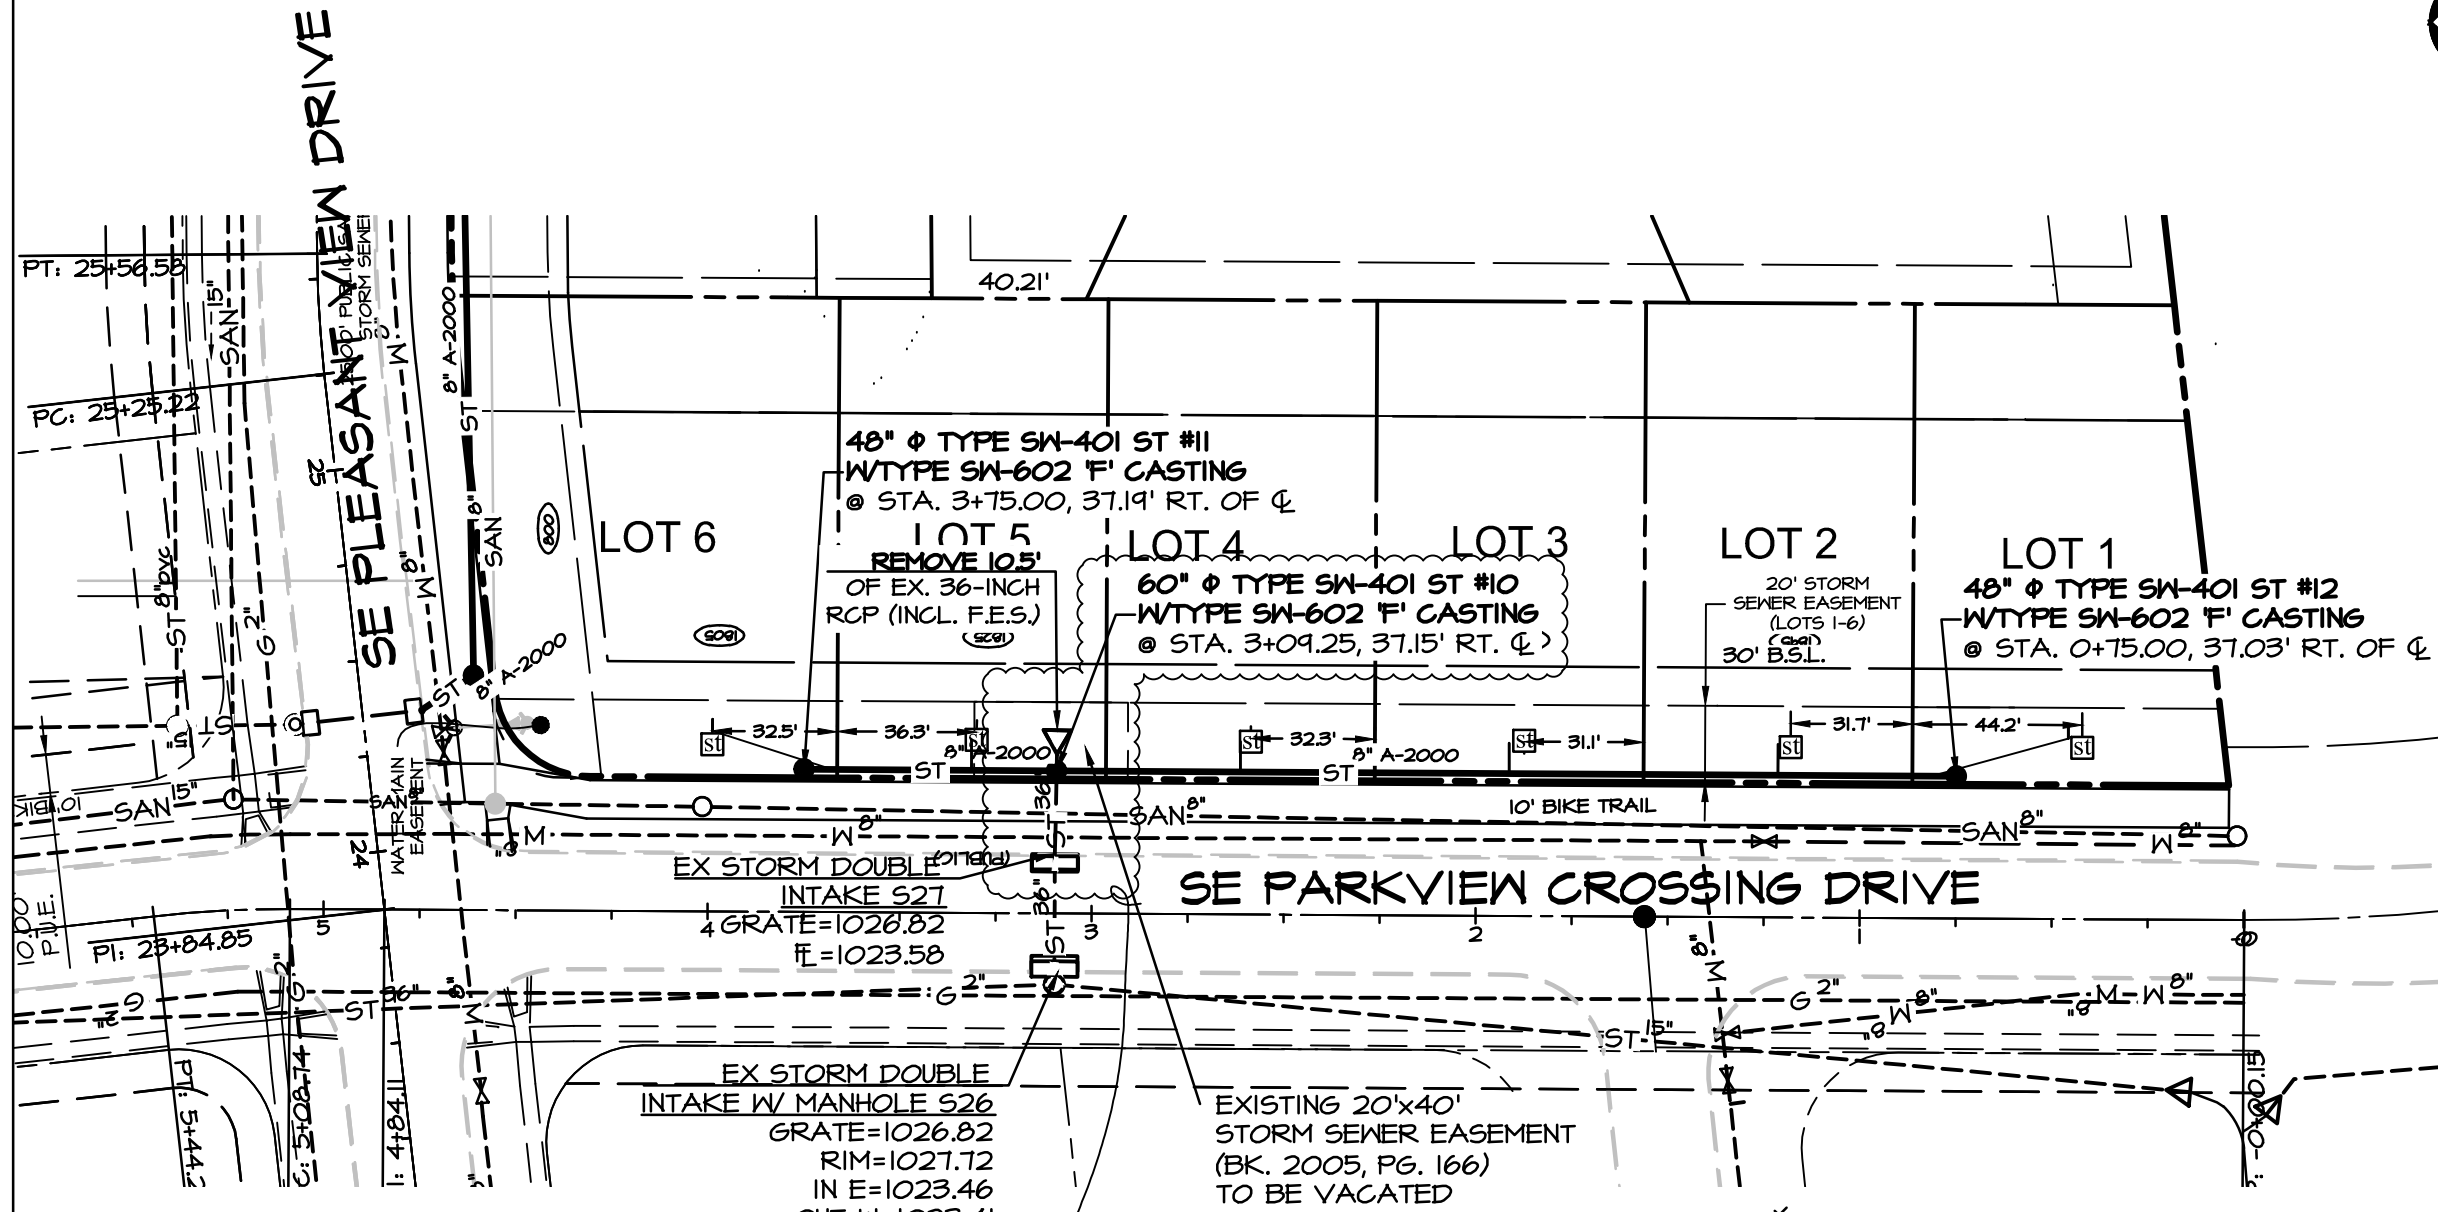

LEGEND	
EXISTING/PROPOSED	
---	PLAT BOUNDARY
SAN 8"	SANITARY SEWER & SIZE
---	STORM SEWER & SIZE
---	WATER MAIN & SIZE
○	MANHOLE
□	STORM INTAKE
+	FIRE HYDRANT
+	VALVE
+	SERVICE CONNECTION



SCALE	
5'	5'
50'	5'

DATE: 11-26-2013	SHEET 6 OF 9
REVISION: 12-18-2013	
01-08-2014	
01-30-2014	

ASBUILT 7-31-2015



Civil Engineering Consultants, Inc.
2400 86th Street, Unit 12, Des Moines, Iowa 50322
515.276.4884, Fax: 515.276.7084, mail@ceclac.com

PLAN & PROFILE STORM SEWER
PARKVIEW CROSSING PLAT II
JERRY'S HOMES, INC., 10430 NEW YORK AVE SUITE C, URBANDALE, IA 50322

E-6853

GRADING AND EROSION CONTROL NOTES

- ALL CONSTRUCTION (PUBLIC & PRIVATE) SHALL BE IN ACCORDANCE WITH SUDAS & THE WAUKEE STANDARD SPECIFICATIONS FOR PUBLIC IMPROVEMENTS IN EFFECT AT THE TIME OF CONSTRUCTION. CURRENT SPECIFICATIONS ARE AVAILABLE ONLINE AT: WWW.WAUKEE.ORG/PDF/SUDAS/STDSPEC_2005A.PDF
- CONTRACTOR SHALL ARRANGE FOR TESTING AND INSPECTION AND NOTIFY THE FOLLOWING AT LEAST ONE WEEK PRIOR TO BEGINNING CONSTRUCTION:
 - CITY OF WAUKEE
 - JERRY'S HOMES, INC.
 - CIVIL ENGINEERING CONSULTANTS, INC.
 - IOWA ONE-CALL
- THE LOCATION OF EXISTING FACILITIES AND APPURTENANCES SHOWN ON THIS PLAN ARE BASED ON AVAILABLE INFORMATION WITHOUT UNCOVERING AND MEASURING TO DETERMINE EXACT FACILITIES LOCATIONS. CIVIL ENGINEERING CONSULTANTS, INC. DOES NOT GUARANTEE THE LOCATION OF EXISTING FACILITIES AS SHOWN, OR THAT ALL EXISTING FACILITIES ARE SHOWN. IT IS THE CONTRACTOR'S RESPONSIBILITY TO CONTACT ALL PUBLIC AND PRIVATE UTILITY PROVIDERS SERVING THIS AREA, AND IOWA ONE CALL, TO DETERMINE THE EXTENT AND PRECISE LOCATION OF EXISTING FACILITIES BEFORE CONSTRUCTION BEGINS.
- THE CONTRACTOR SHALL PROTECT EXISTING ON-SITE FACILITIES FROM DAMAGE RESULTING FROM THE CONTRACTOR'S WORK. IF DAMAGE, BREAKAGE, INTERRUPTION OF SERVICE, ETC. OF EXISTING FACILITIES DOES OCCUR, THE CONTRACTOR SHALL IMMEDIATELY CONTACT THE UTILITY'S OWNER. EXISTING FILL DIRT HAS BEEN HAULED IN TO RAISE THIS SITE UP. TOPSOIL ON THIS SITE MAY HAVE NOT BEEN STRIPPED IN THE PROCESS. THE BUILDER OF EACH INDIVIDUAL LOT SHALL BE REQUIRED TO HIRE A GEOTECHNICAL ENGINEER TO PERFORM FOOTING AND FLOOR SLAB INSPECTION TO DETERMINE THAT FOUNDATION AND FLOOR SLAB SOILS ARE SUITABLE AND CAN PROVIDE ADEQUATE SUPPORT PRIOR TO CONCRETE PLACEMENT.
- EXISTING TOPSOIL SHALL BE STRIPPED AND RESPAID ON ALL LAWN AREAS IF POSSIBLE.
- UNLESS GRADING FOR A DESIGNED SUMP OR LOW POINT AREA, GRADE ALL SITE AREAS TO DRAIN WITHOUT TRAPPING OR PONDING SURFACE WATER WHEN SITE GRADING IS COMPLETE.
- FINAL GRADE ELEVATIONS OF ALL PAVED AREAS SHALL BE WITHIN 0.10 FEET OF PLAN GRADE UNLESS STATED OTHERWISE IN THE WAUKEE STANDARD SPECIFICATIONS FOR PUBLIC IMPROVEMENTS. LAWN AREAS SHALL BE WITHIN 0.20 FEET OF PLAN GRADE.
- SPOT ELEVATIONS ON PAVED SURFACES ARE TOP OF SLAB ELEVATIONS UNLESS NOTED OTHERWISE.
- CIVIL ENGINEERING CONSULTANTS, INC. IS NOT A GEOTECHNICAL ENGINEER.
- A GEOTECHNICAL REPORT FOR THIS PROJECT CAN BE OBTAINED BY CONTACTING THE OWNER.
- AN ASBUILT PLAN SET SHALL BE PROVIDED UPON COMPLETION OF SITE IMPROVEMENTS INCLUDING DIMENSIONS, ELEVATIONS AND SPOT ELEVATIONS TO ENSURE THAT SITE GRADING CONFORMS TO THE GRADING PLAN AND THAT PROPER DRAINAGE HAS BEEN ESTABLISHED.
- THE CONTRACTOR SHALL CERTIFY ON THE ASBUILT PLAN THAT THE STORMWATER MANAGEMENT FACILITY WAS CONSTRUCTED TO ADDRESS ALL PROPERTIES WITHIN THE DEVELOPMENT.
- GRADING, OUTLET PROTECTION AND STORM SEWER CONSTRUCTION WITHIN OUTLOT 'X', PARKVIEW CROSSING PLAT II AND OUTLOT 'Y', GRANT PARK PLAT 2, SHALL BE COORDINATED WITH THE ALICE'S ROAD REGIONAL DETENTION BASIN CONTRACTOR. THE BASIN PROJECT IS PROJECTED TO START SPRING 2014.
- THE CONTRACTOR SHALL REFER TO AND FOLLOW RECOMMENDATIONS OF ALLENDER BUTZKE'S GEOTECHNICAL REPORT FN 13481, DATED JANUARY 3, 2014.

MINIMUM OPENING ELEVATION TABLE	
LOT NUMBER	M.O.E.
LOT 1	1026.0
LOT 2	1027.0
LOT 3	1028.0
LOT 4	1029.0
LOT 5	1029.0
LOT 6	1028.5
LOT 7	1028.0
LOT 8	1027.5
LOT 9	1027.0
LOT 10	1027.0
LOT 11	1026.0
LOT 12	1026.0
LOT 13	1026.0
LOT 14	1026.0
LOT 15	1026.0
LOT 16	1028.0
LOT 17	1028.0

BENCHMARK

CITY OF WAUKEE BENCHMARK LOCATED ON THE BURY BOLT OF THE WATER HYDRANT LOCATED ON THE NW CORNER OF LOT 26, PARKVIEW CROSSING PLAT 6
ELEVATION= 1025.46

CONSTRUCTION SCHEDULE

4/01/2014 - 4/12/2014	ROUGH GRADING
4/12/2014 - 4/30/2014	SEEDING/MULCHING/SILT FENCING
4/12/2014 - 5/12/2014	UTILITY CONSTRUCTION
5/12/2014 - 5/31/2014	PAVING
5/12/2014 - 5/26/2014	FINAL GRADING & SEEDING
5/26/2014 - 5/31/2014	MULCHING/SILT FENCING/RIPRAP

QUANTITIES


5 EA.	BELOW GRADE INLET FILTER / FILTER SOCK
1,924 L.F.	SILT FENCE
2 EA.	SEDIMENT TRAP
24 TN.	CLASS 'E' RIPRAP OVER ENGINEERING FABRIC

AREA DISTURBED = 5.31 AC.
210,293 SF SEEDING (TYPE II EROSION CONTROL MIX)

SEDIMENT TRAP DETAILS

SEDIMENT TRAP #1
1.06 ACRE DRAINAGE AREA
3,016 CF OF STORAGE REQ'D
ELEV A = 1020.00
ELEV B = 1022.29
ELEV C = 1023.20
ELEV D = 1024.00
L = 2 FEET


SEDIMENT TRAP #2
0.80 ACRE DRAINAGE AREA
2,860 CF OF STORAGE REQ'D
ELEV A = 1022.00
ELEV B = 1024.00
ELEV C = 1024.69
ELEV D = 1025.00
L = 2 FEET

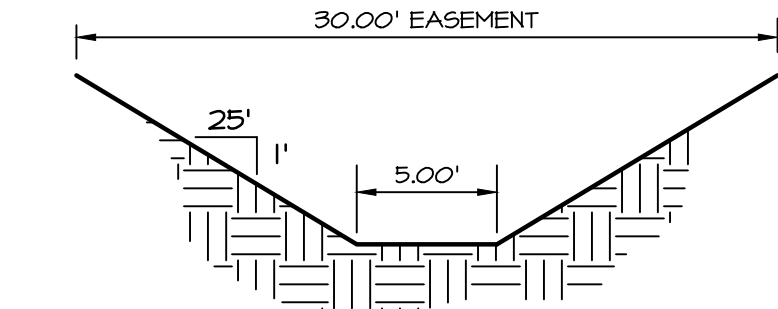

TYPICAL 30' SWALE
NO SCALE

LEGEND

EXISTING/PROPOSED	
---	PLAT BOUNDARY
--- SAN 18"	SANITARY SEWER & SIZE
--- ST 18"	STORM SEWER & SIZE
--- W 8"	WATER MAIN & SIZE
○	MANHOLE
□	STORM INTAKE
▽	FIRE HYDRANT
▽	VALVE
B.S.L.	BUILDING SETBACK LINE
H.S.L.	HOUSE SETBACK LINE
G.S.L.	GARAGE SETBACK LINE
---	EXISTING CONTOURS
---	PROPOSED CONTOURS
---	SILT FENCE
□	BELOW GRADE INLET FILTER & FILTER SOCK
SB	TEMPORARY SEDIMENT BASIN
ST	SEDIMENT TRAP

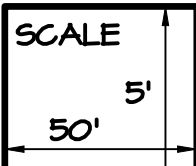

DATE:	11-26-2013	SHEET 7 OF 9
REVISION:	12-10-2013	
	01-08-2014 01-30-2014	



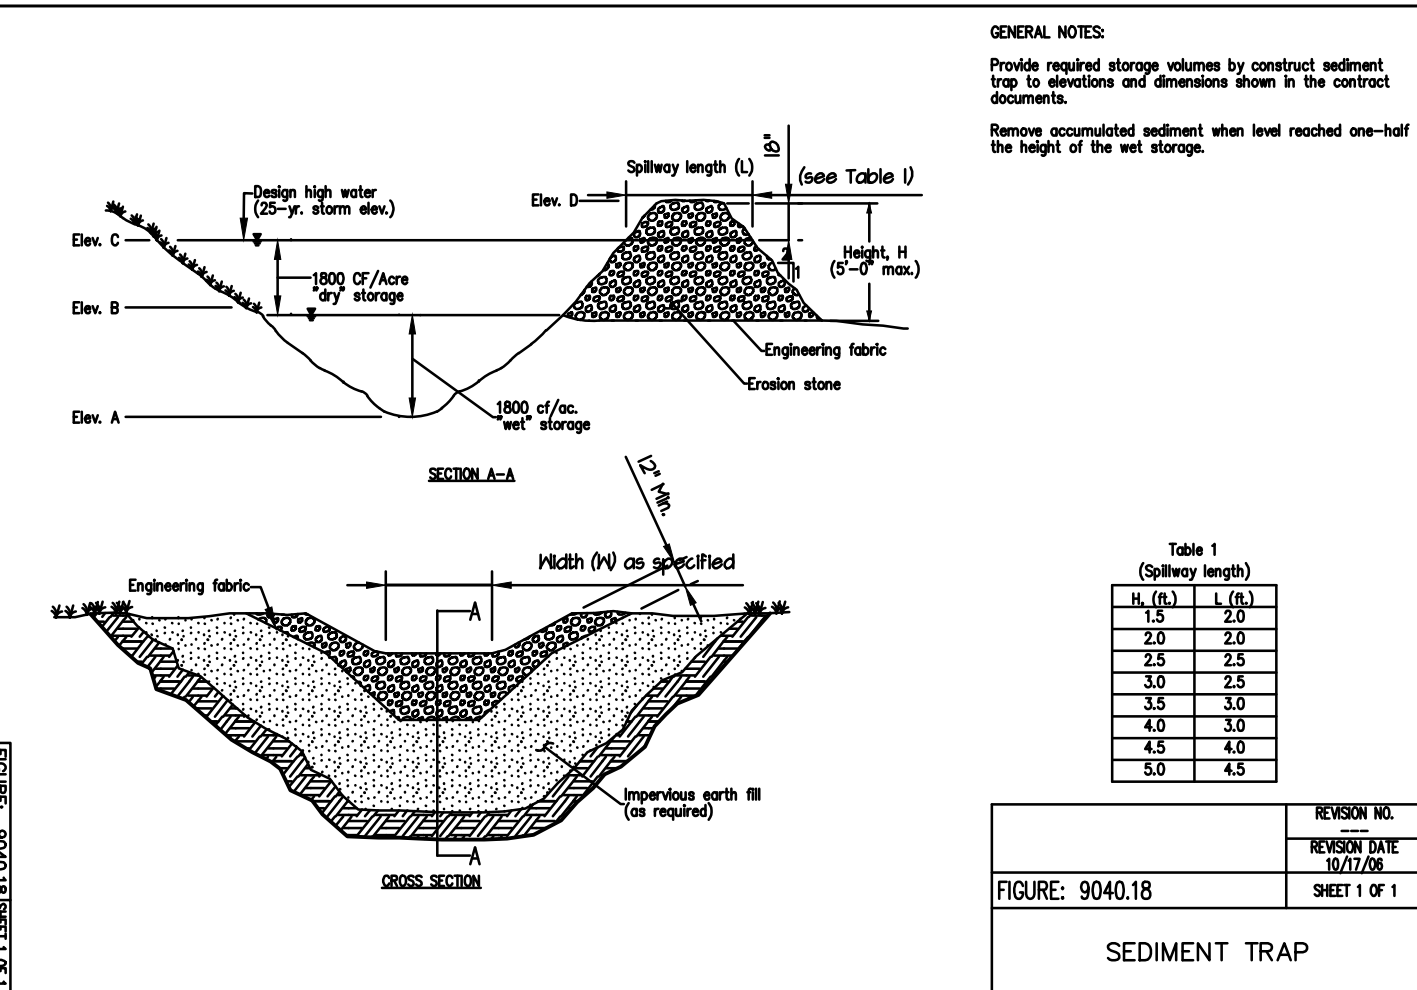






Table 1 (Spillway length)	
L (ft.)	V (cu ft.)
15	2.0
20	2.0
25	2.5
30	2.5
35	3.0
40	3.0
45	4.0
50	4.5

FIGURE: 9040.18	REVISION NO. 10/17/08 SHEET 1 OF 1
SEDIMENT TRAP	

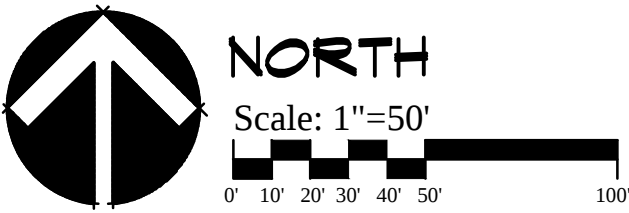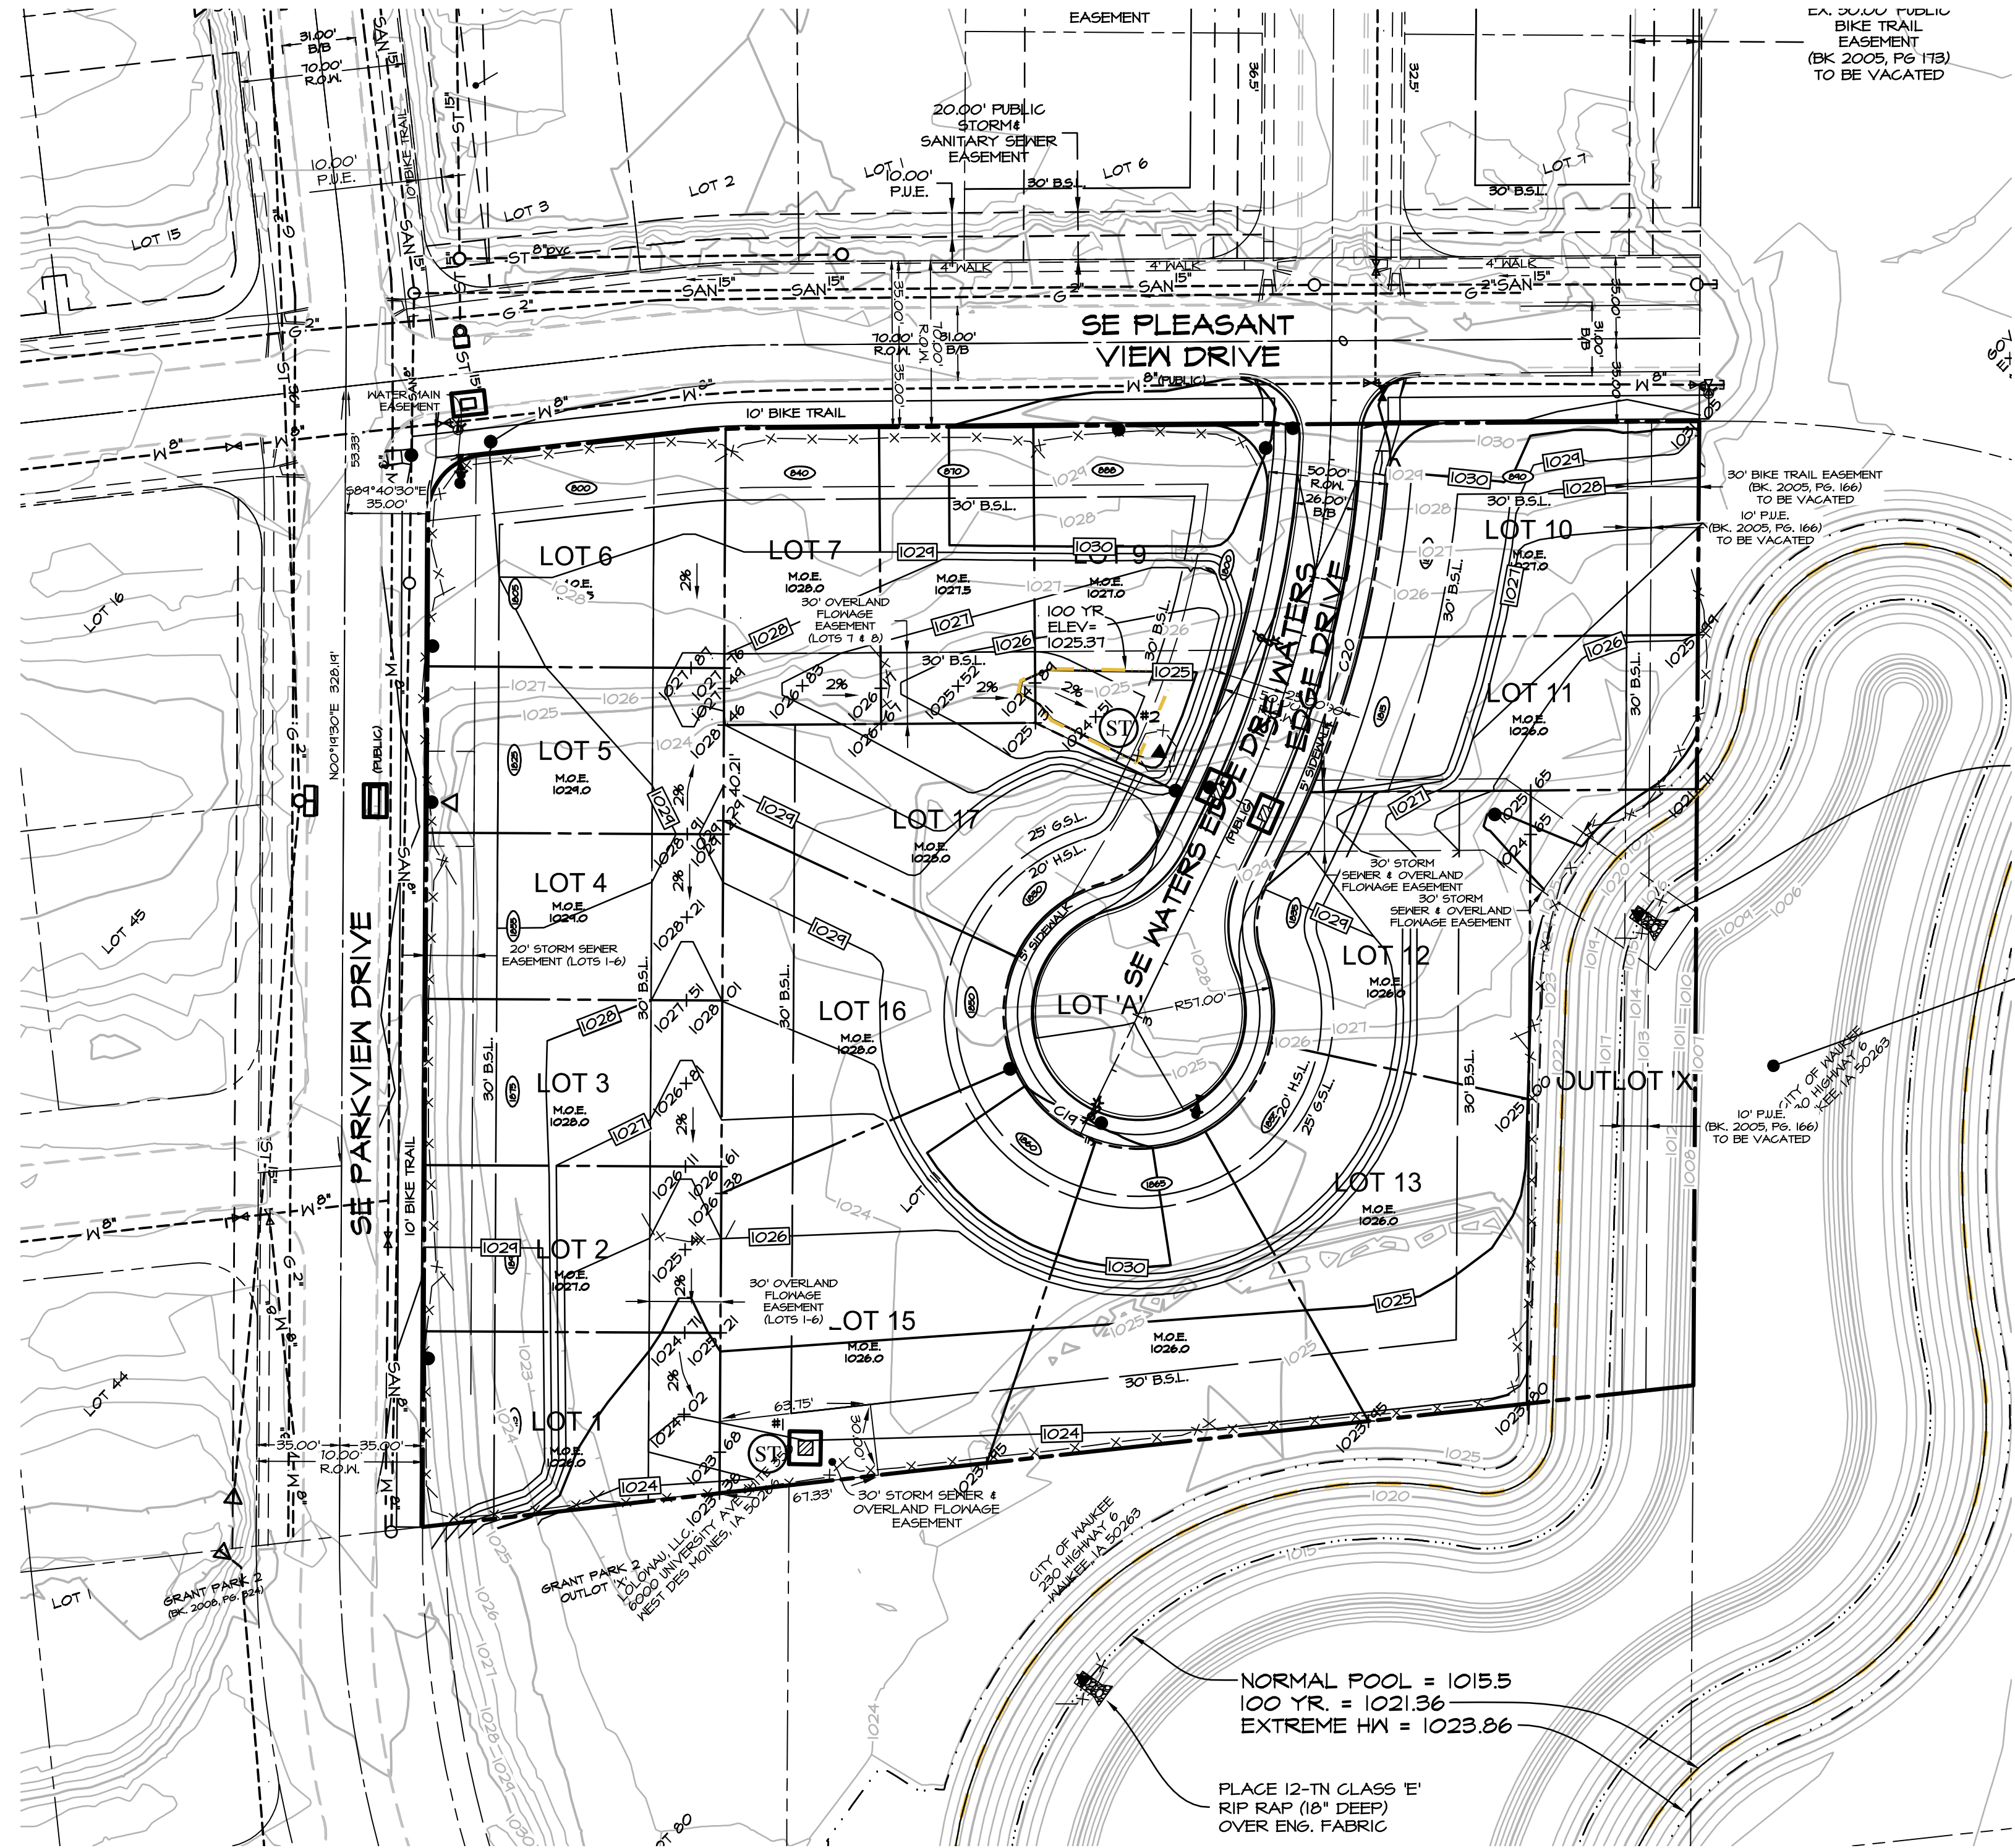


Civil Engineering Consultants, Inc.
2400 86th Street, Unit 12, Des Moines, Iowa 50322
515.276.4884, Fax: 515.276.7084, mail@ceclac.com

GRADING PLAN
PARKVIEW CROSSING PLAT II
JERRY'S HOMES, INC., 10430 NEW YORK AVE SUITE C, URBANDALE, IA 50322

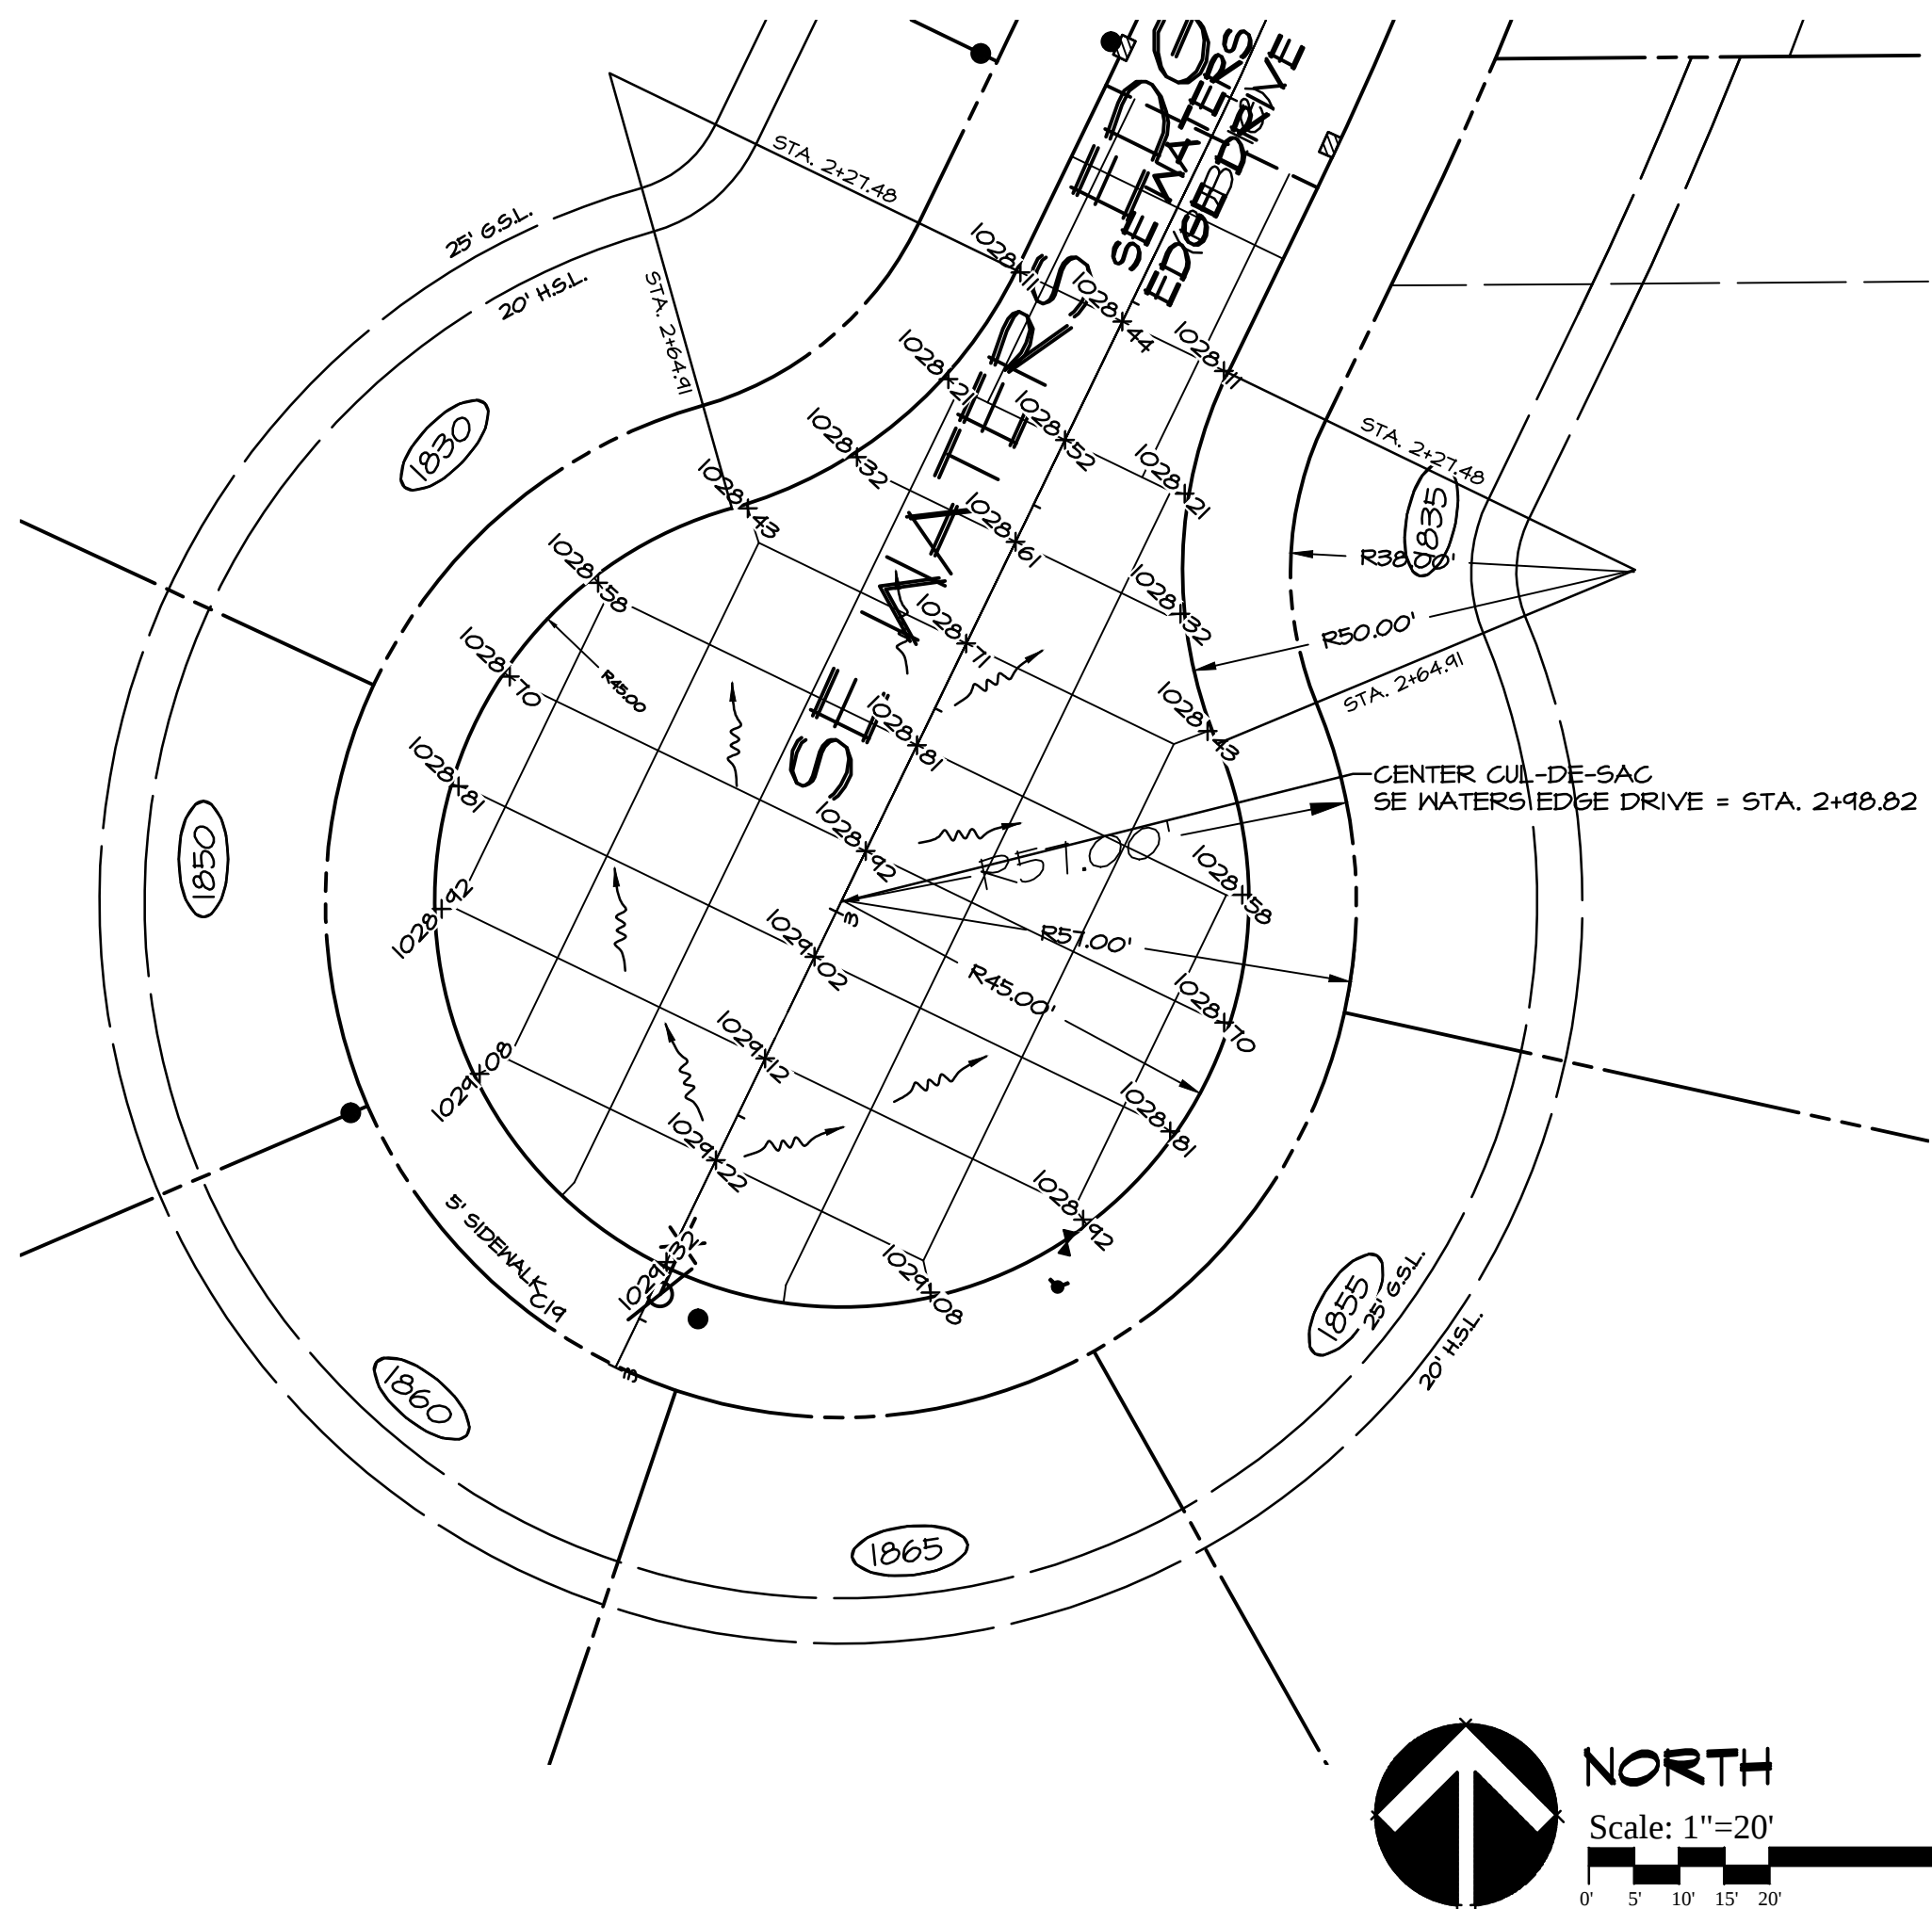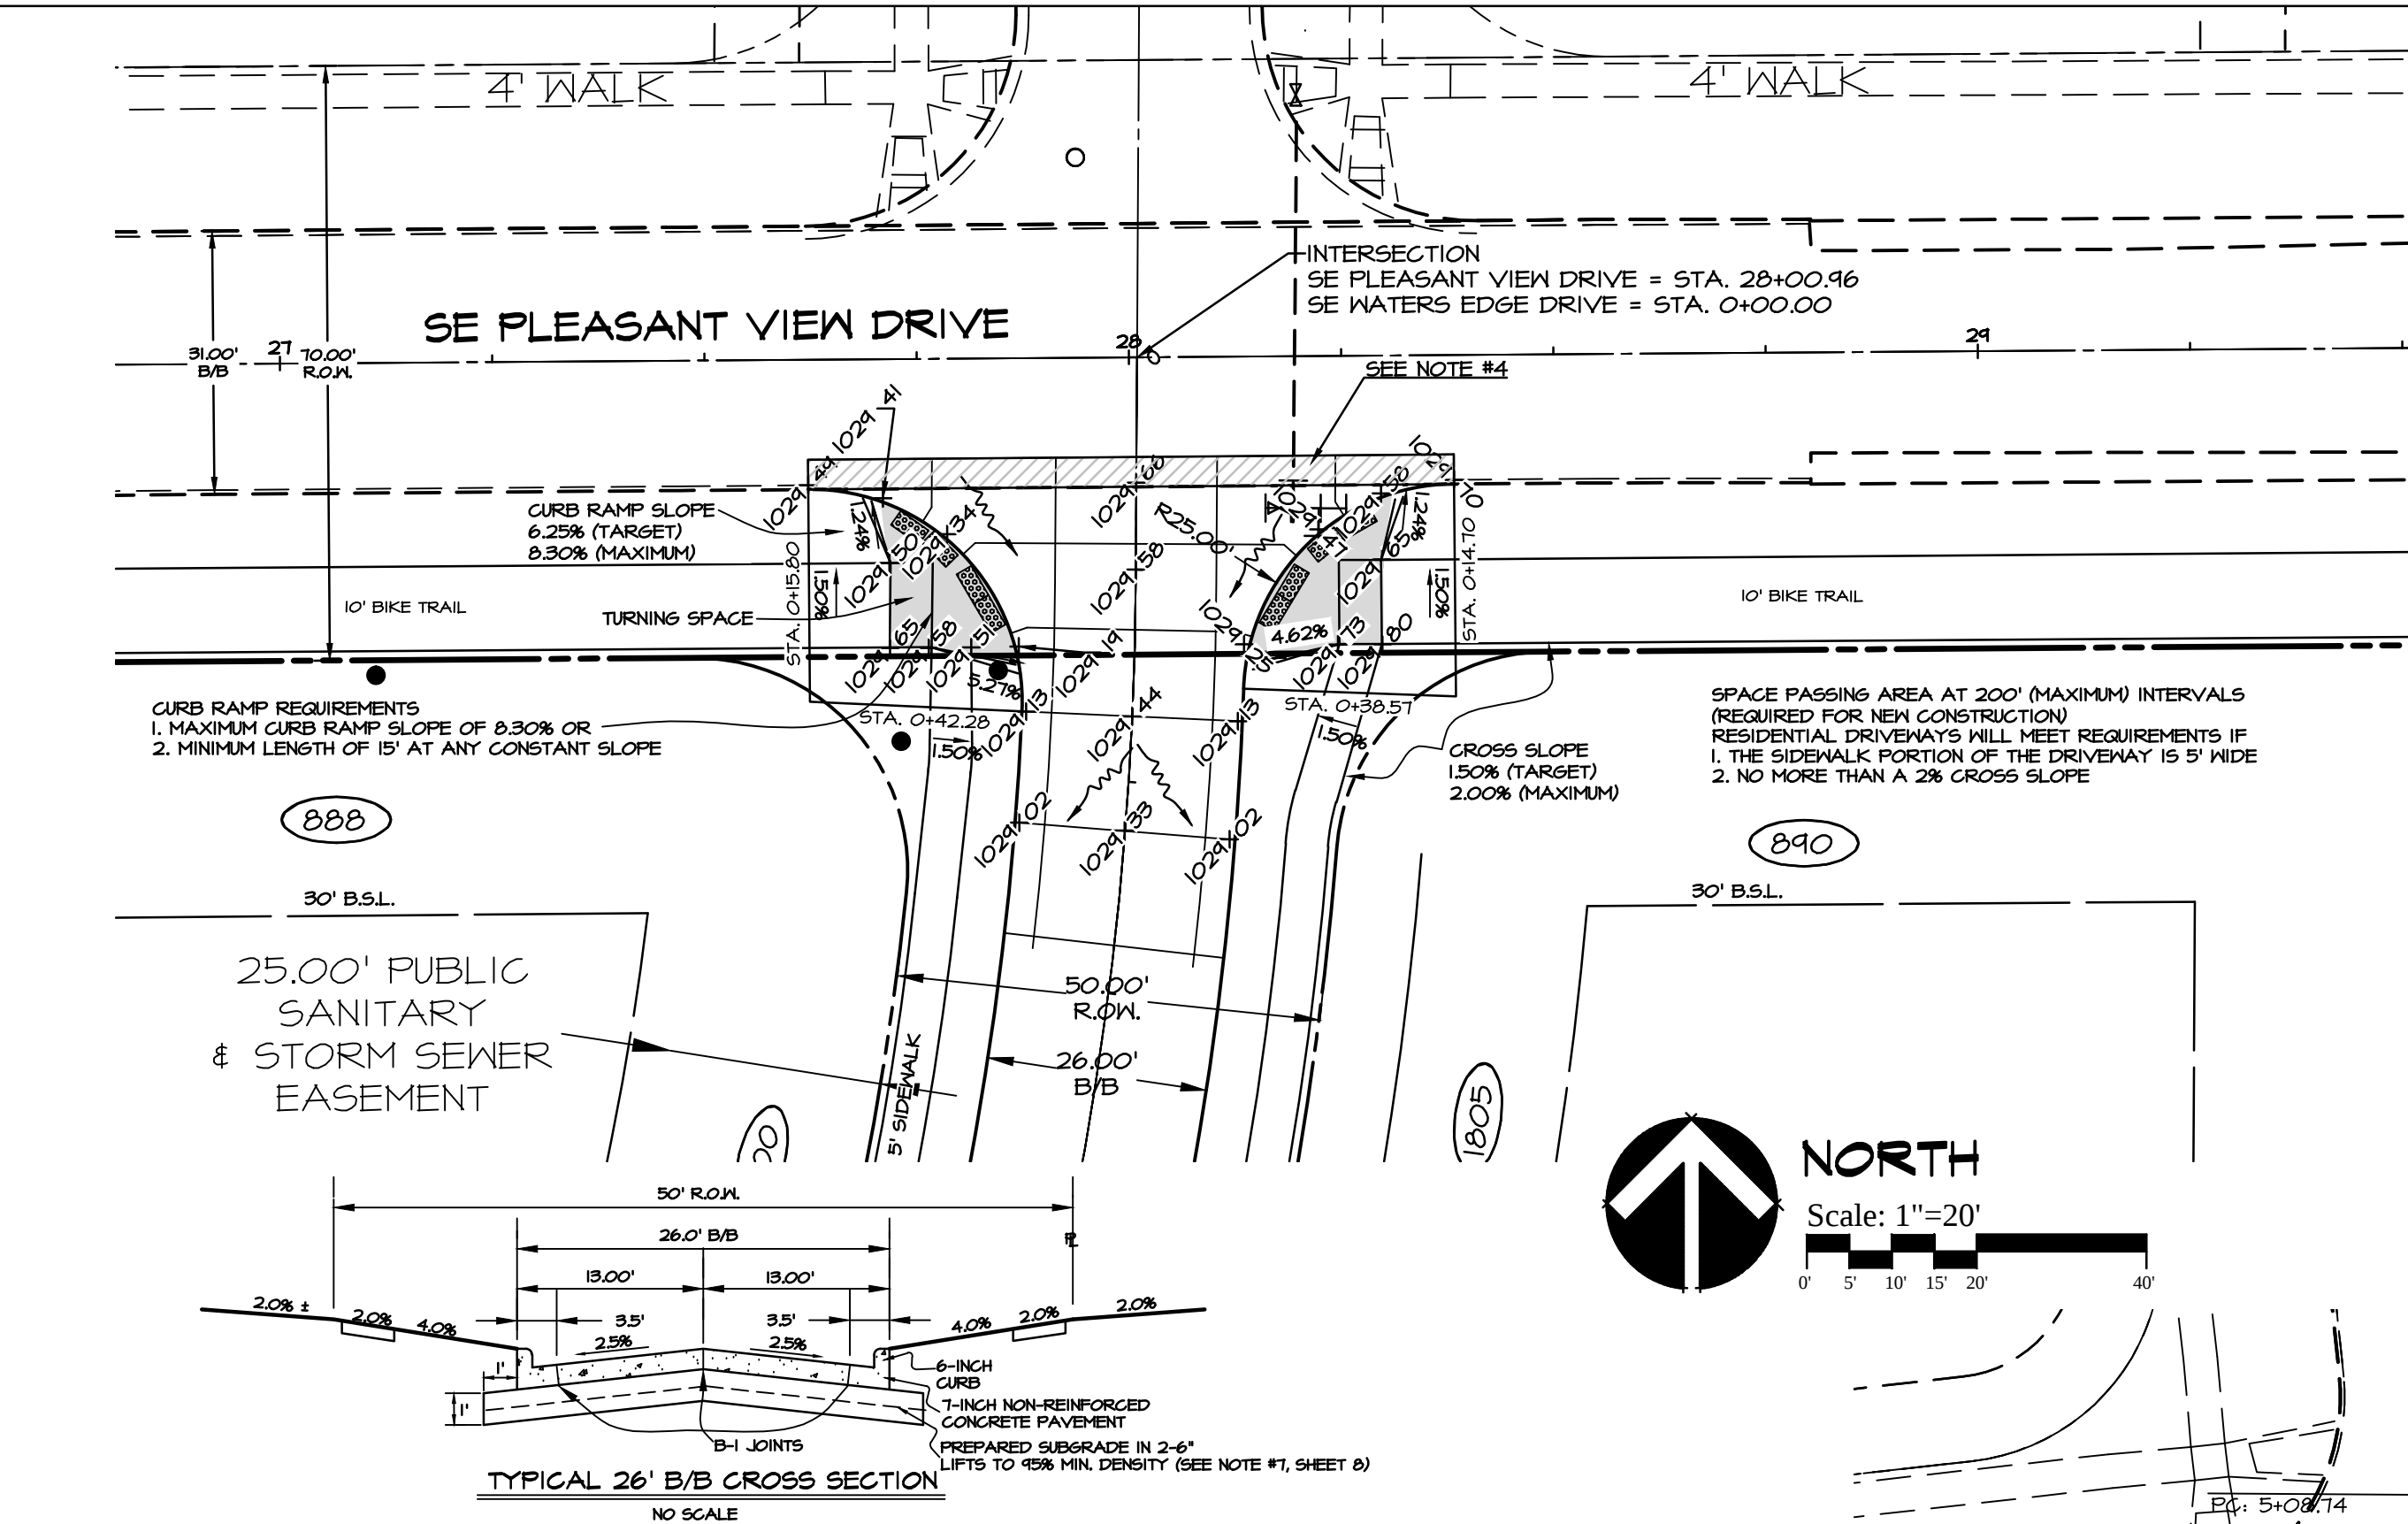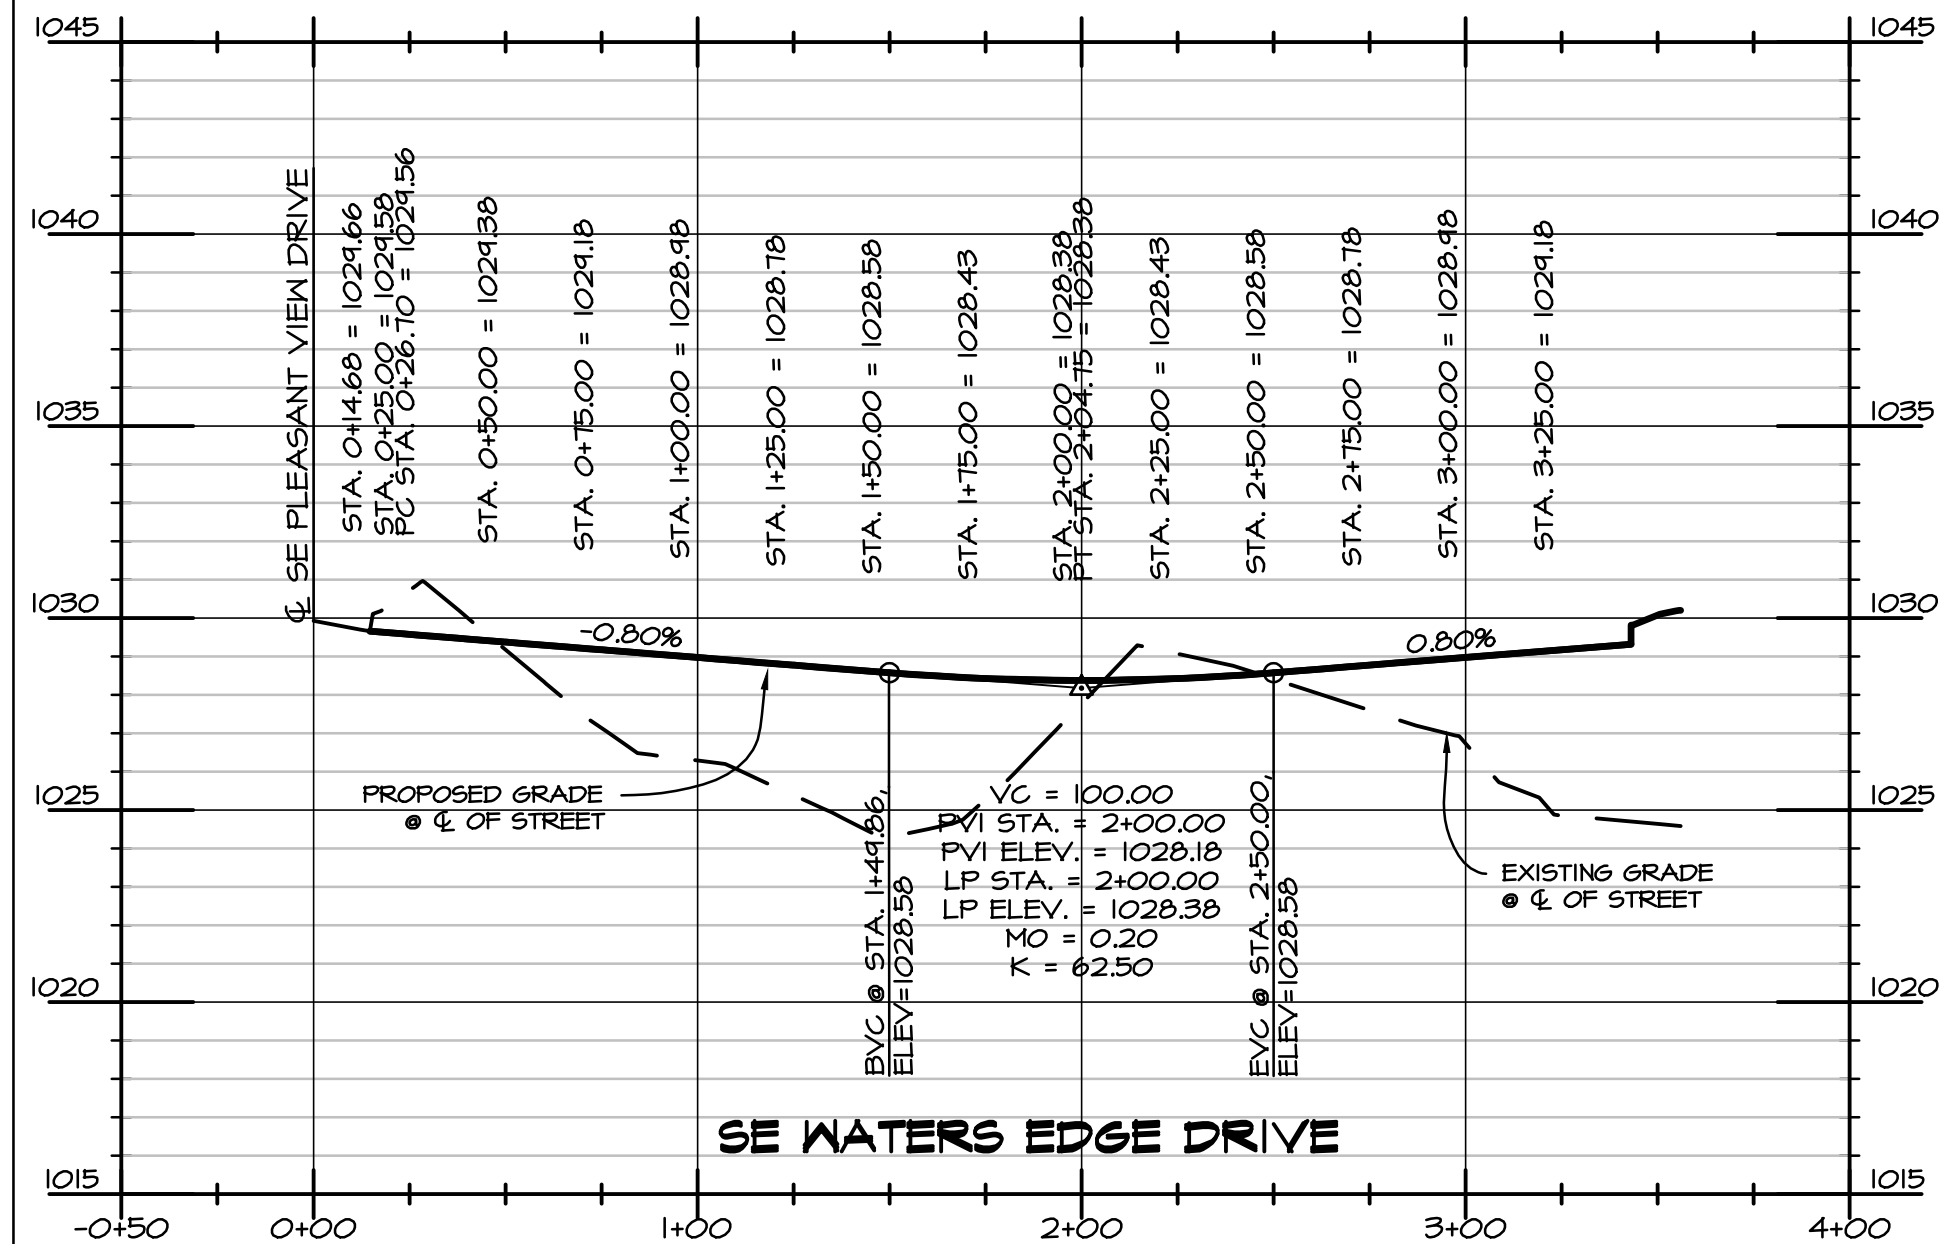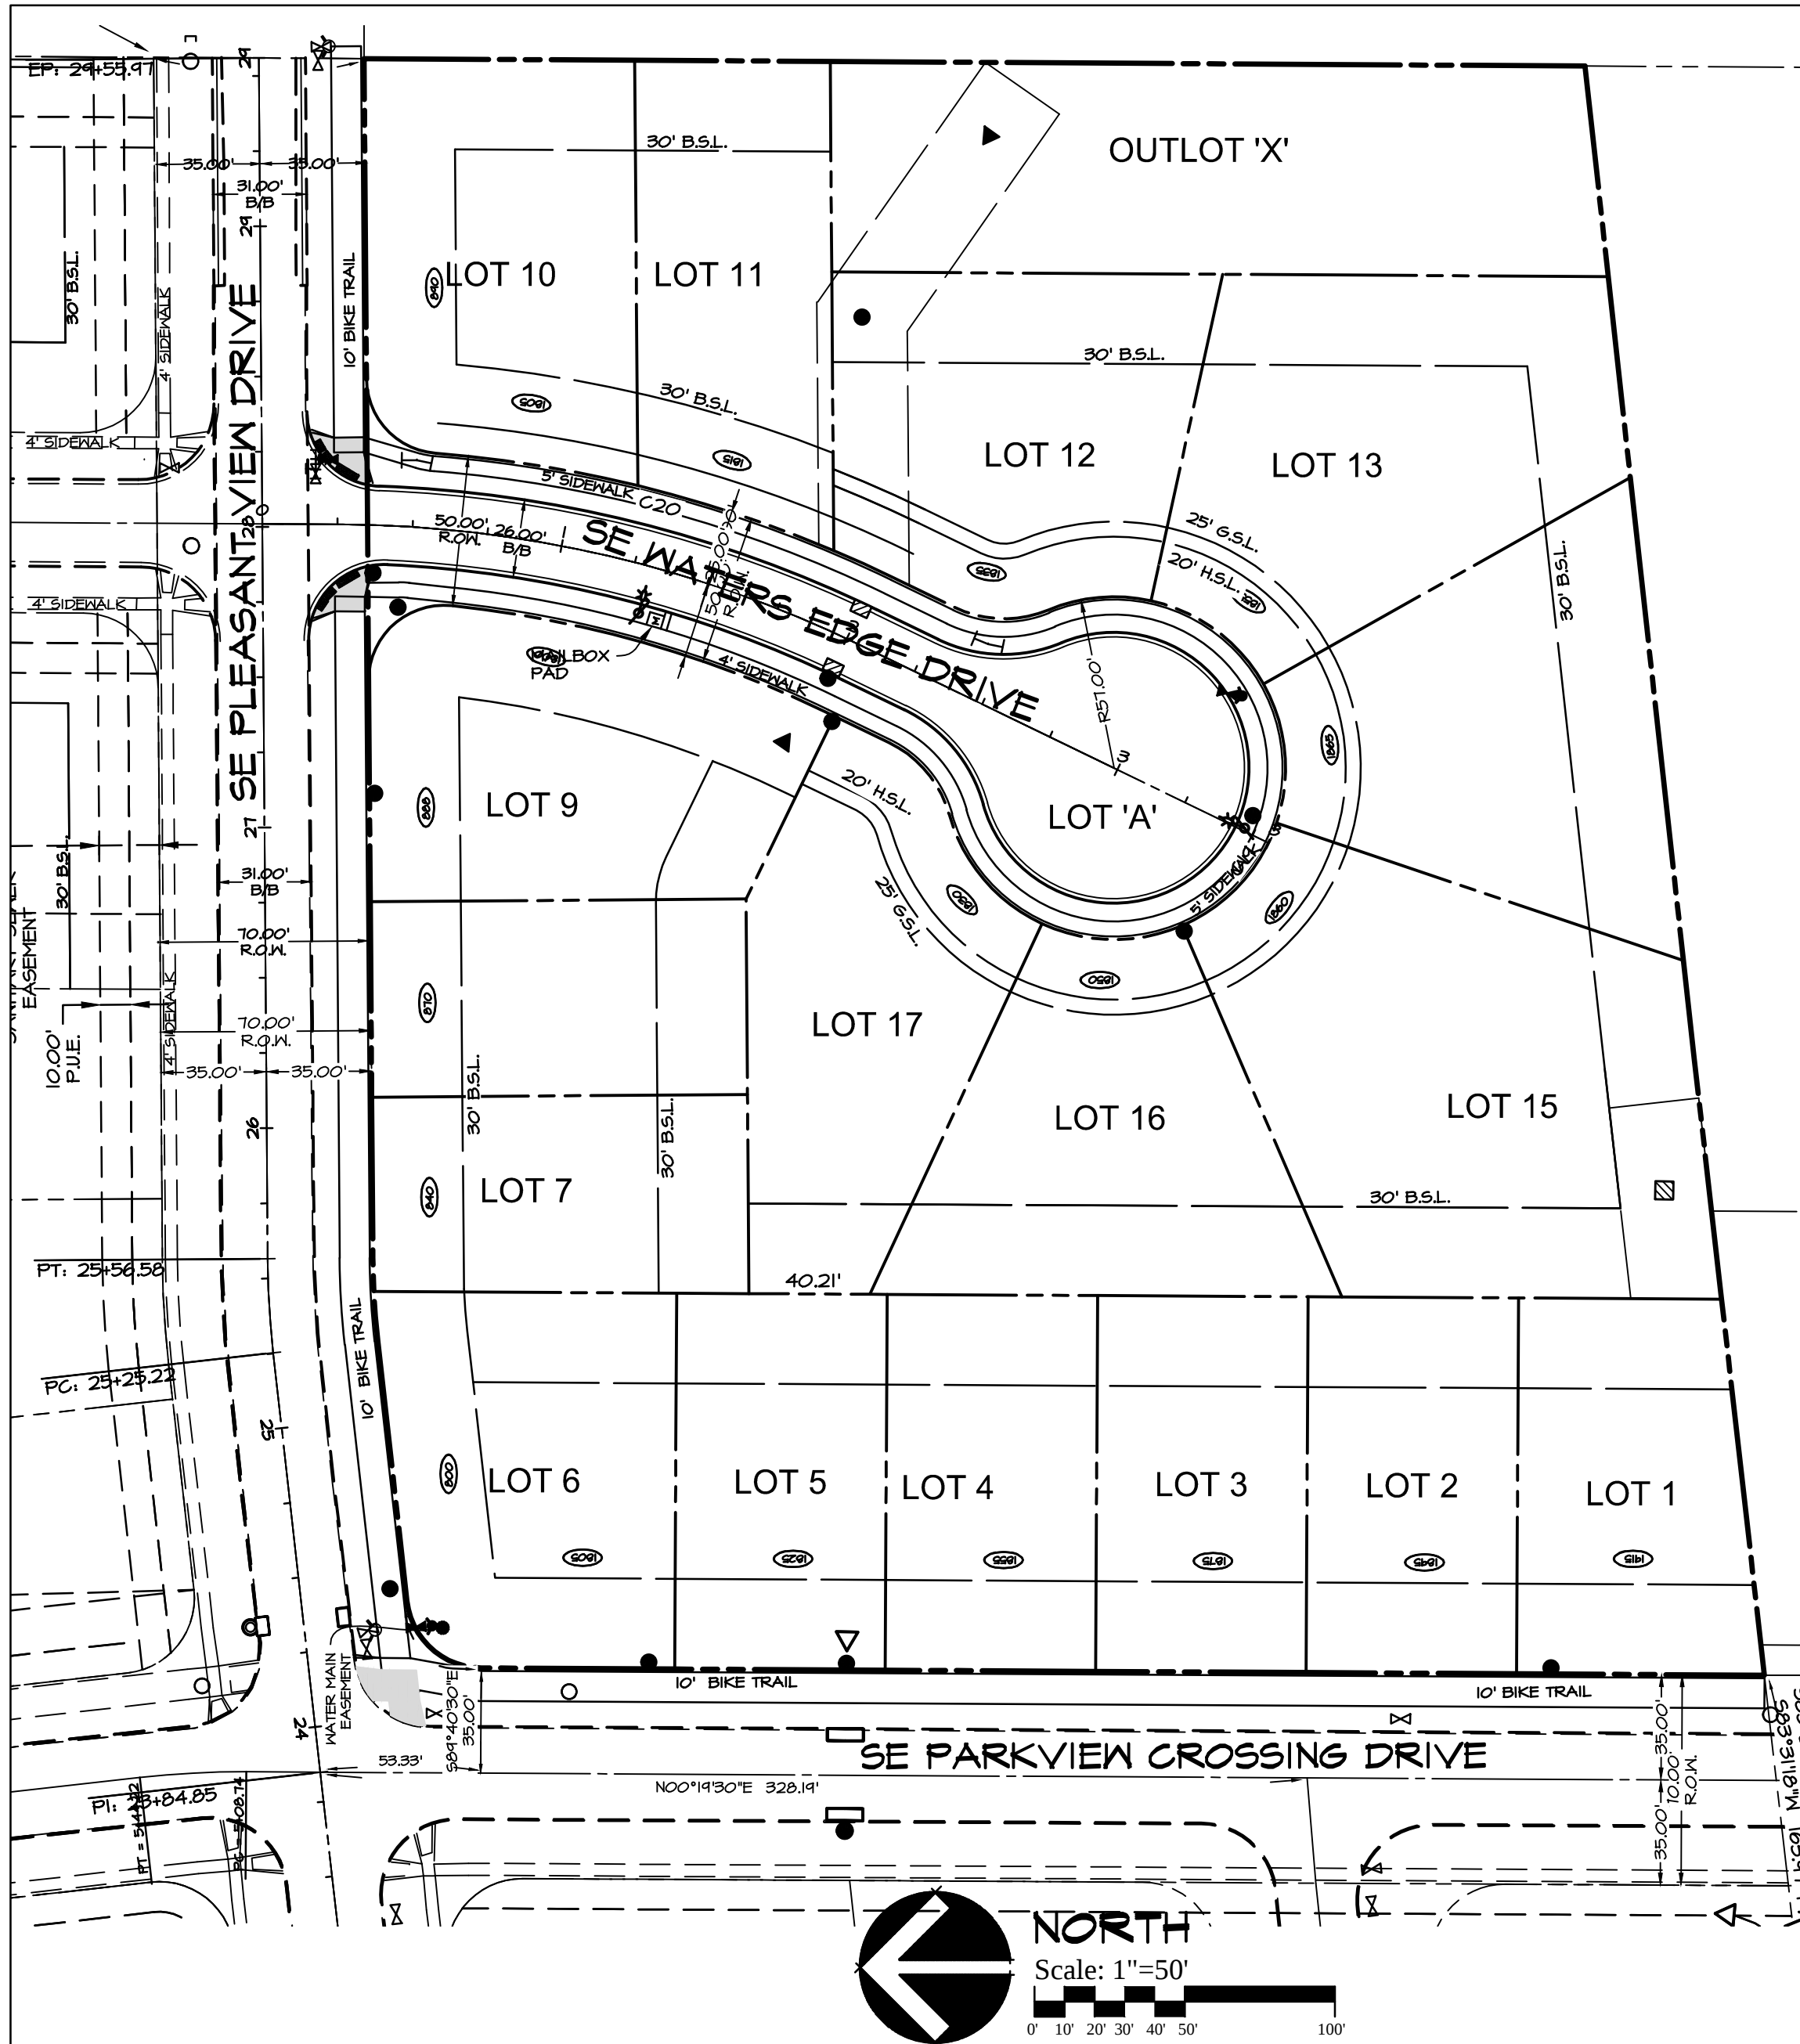

- NOTES**
1. ALL ELEVATIONS ARE PROPOSED FINISHED GRADE AT TOP OF CURB UNLESS OTHERWISE NOTED.
 2. ALL STREETS SHALL HAVE 6-INCH CURBS.
 3. PROVIDE CURB DROPS FOR SIDEWALKS AT INTERSECTIONS.
 4. ALL PAVEMENT ALONG SE PLEASANT VIEW DRIVE SHALL BE 8-INCH P.C.C. W/C BASKETS. SAWCUT PAVING AT NEAREST JOINT. REMOVE EXISTING CURB & GUTTER. PROVIDE 'BT-2' JOINT.
 5. ALL TRUNCATED DOWNS, WARNING PANELS & MAILBOX PADS ARE TO BE INSTALLED AS PART OF THE PUBLIC IMPROVEMENT FOR THIS PLAN.
 6. THE CONTRACTOR SHALL REFER TO AND FOLLOW RECOMMENDATIONS OF ALLENDER BUTZKE'S GEOTECHNICAL REPORT FN (3140), DATED JANUARY 3, 2014 WITH REGARDS TO STREET SUBGRADE PREPARATION.
 7. THE CONTRACTOR SHALL REMOVE THE TOP 12-INCHES BELOW THE BOTTOM OF THE PROPOSED PAVING AND HAVE A PROOF ROLL PERFORMED (OBSERVED BY A GEOTECHNICAL ENGINEER) TO DETERMINE IF SUBSURFACE MATERIAL IS ADEQUATE. THE CONTRACTOR WILL THEN INSTALL NON-EXPANSIVE SUBGRADE IN TWO 6-INCH LIFTS PER STANDARD SPECIFICATIONS.

- QUANTITIES**
- | | |
|-----------|---|
| 1450 S.Y. | 1-INCH NON-REINFORCED P.C.C. (SE WATERS EDGE COURT) |
| 1647 S.Y. | SUB GRADE PREP. WORK |
| 30 S.Y. | REMOVE & REPLACE 8" P.C.C. W/C BASKETS (SE PLEASANT VIEW DRIVE) |
| 4 EA. | PEDESTRIAN RAMP WITH TRUNCATED DOMES |
| 1 EA. | MAILBOX PAD |

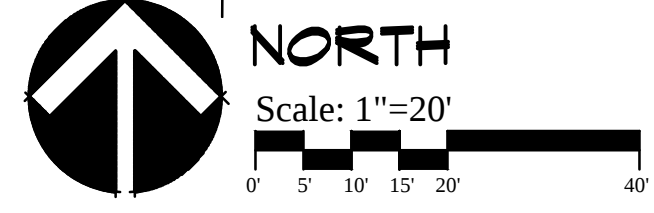


- LEGEND**
- | | |
|--------------------|-----------------------|
| EXISTING/PROPOSED | PLAT BOUNDARY |
| SAN 8" | SANITARY SEWER & SIZE |
| ST 18" | STORM SEWER & SIZE |
| W 8" | WATER MAIN & SIZE |
| MANHOLE | MANHOLE |
| STORM INTAKE | STORM INTAKE |
| FIRE HYDRANT | FIRE HYDRANT |
| VALVE | VALVE |
| SERVICE CONNECTION | SERVICE CONNECTION |
| MAILBOX PAD | MAILBOX PAD |







DATE: 11-26-2013
REVISION: 12-18-2013
01-08-2014
01-30-2014

SHEET
8
OF 9




WAUKEE STANDARD CLUSTER MAILBOX PAD DETAIL

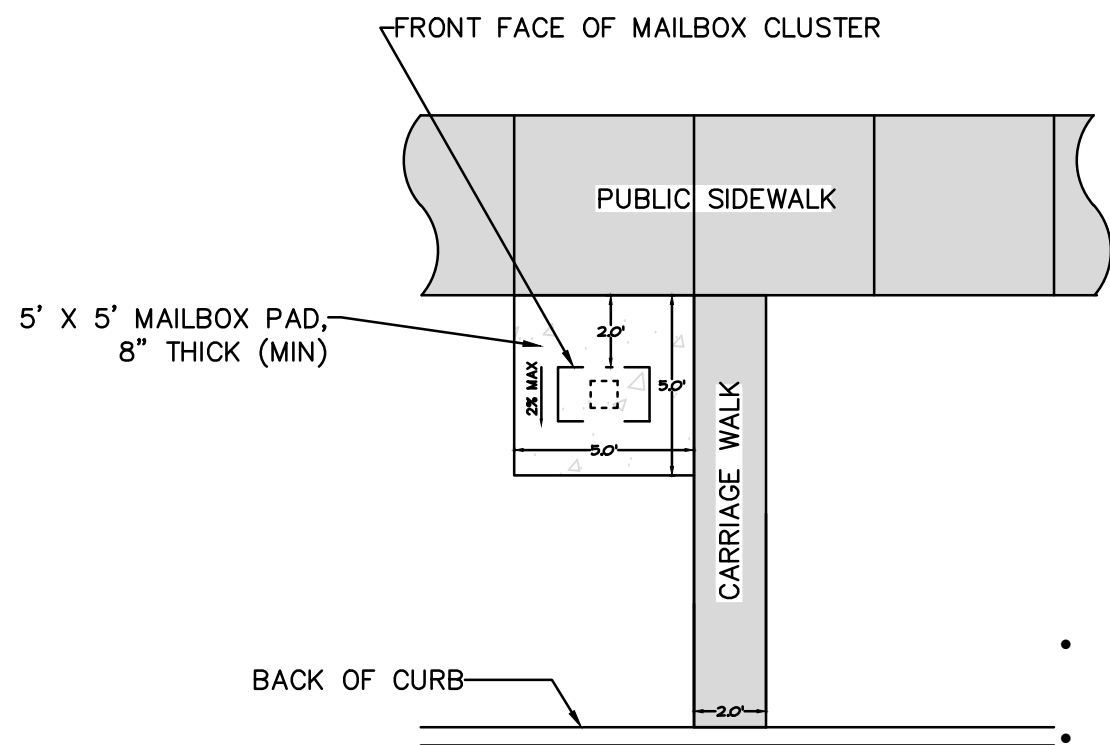

- Cluster Mailbox to be located on the no parking/street light side of street
- Do not locate at intersection
- Locate near shared property line per approved plan

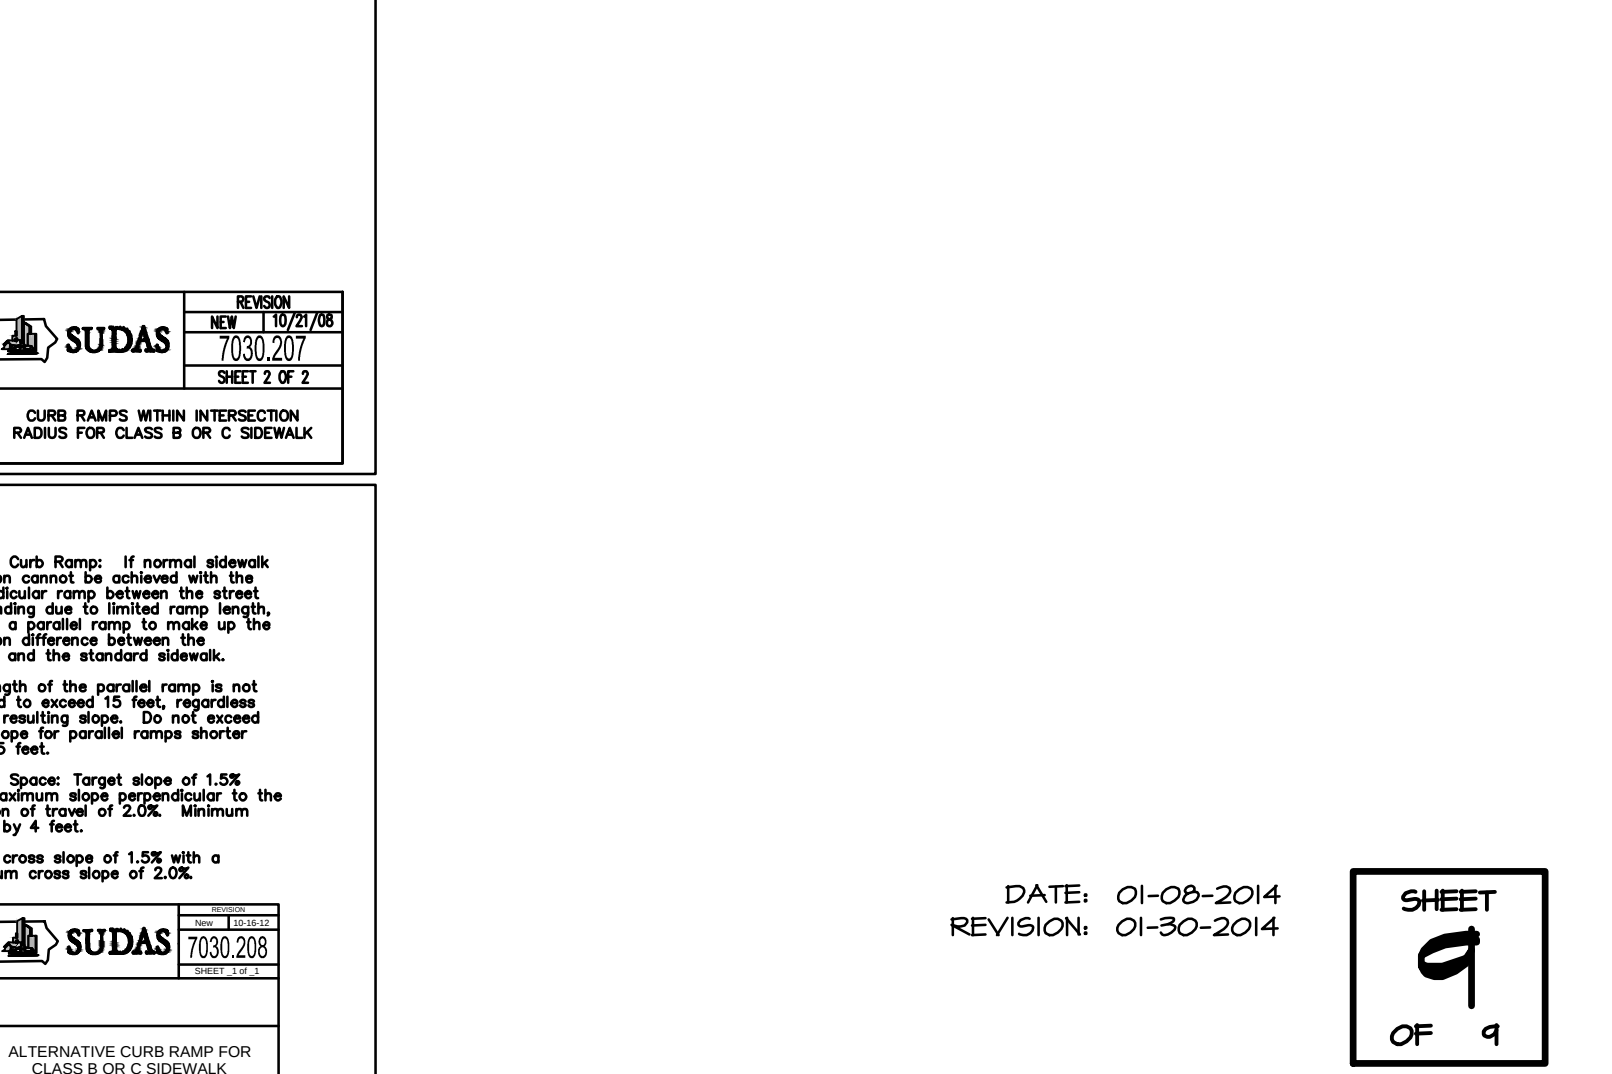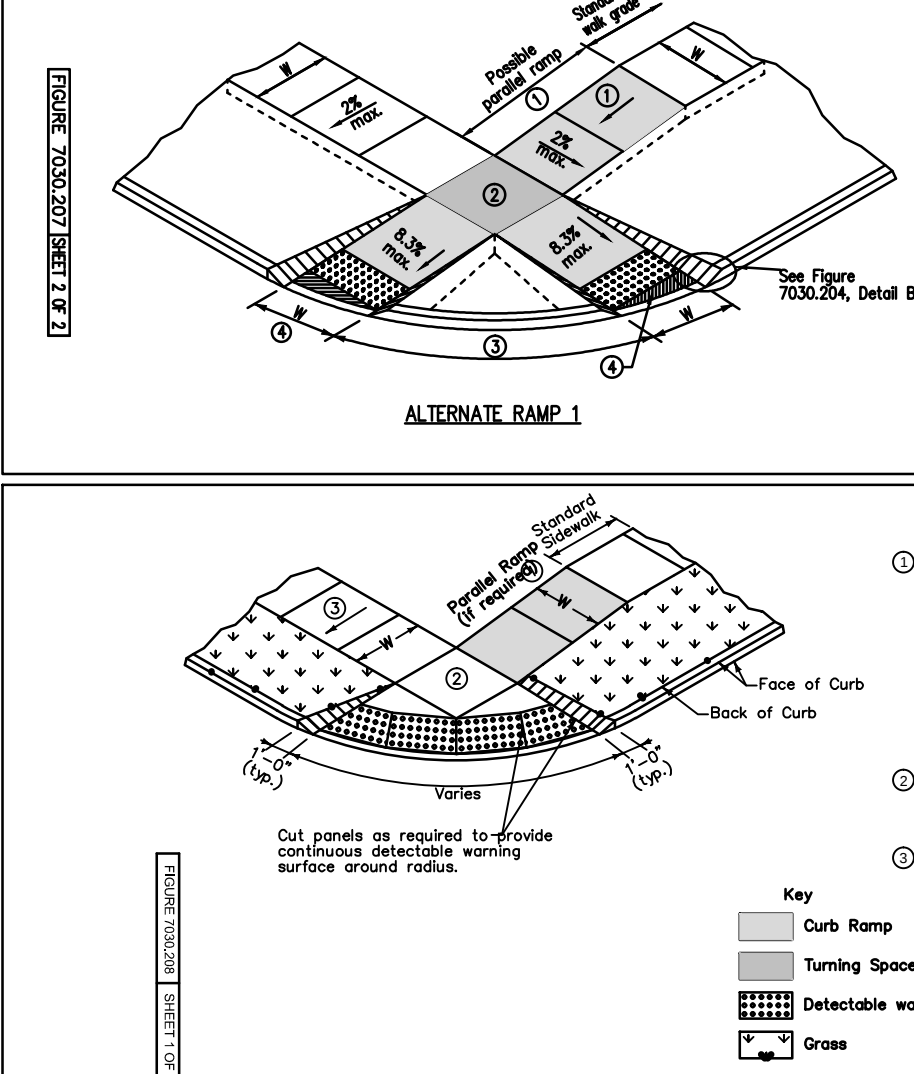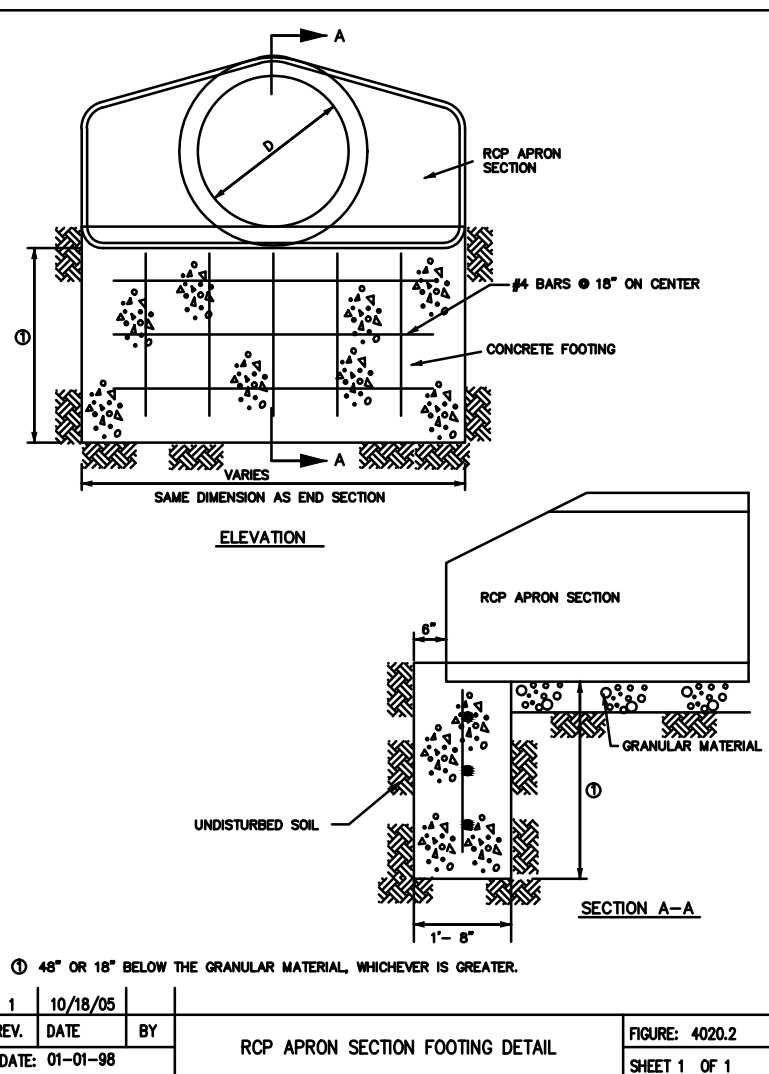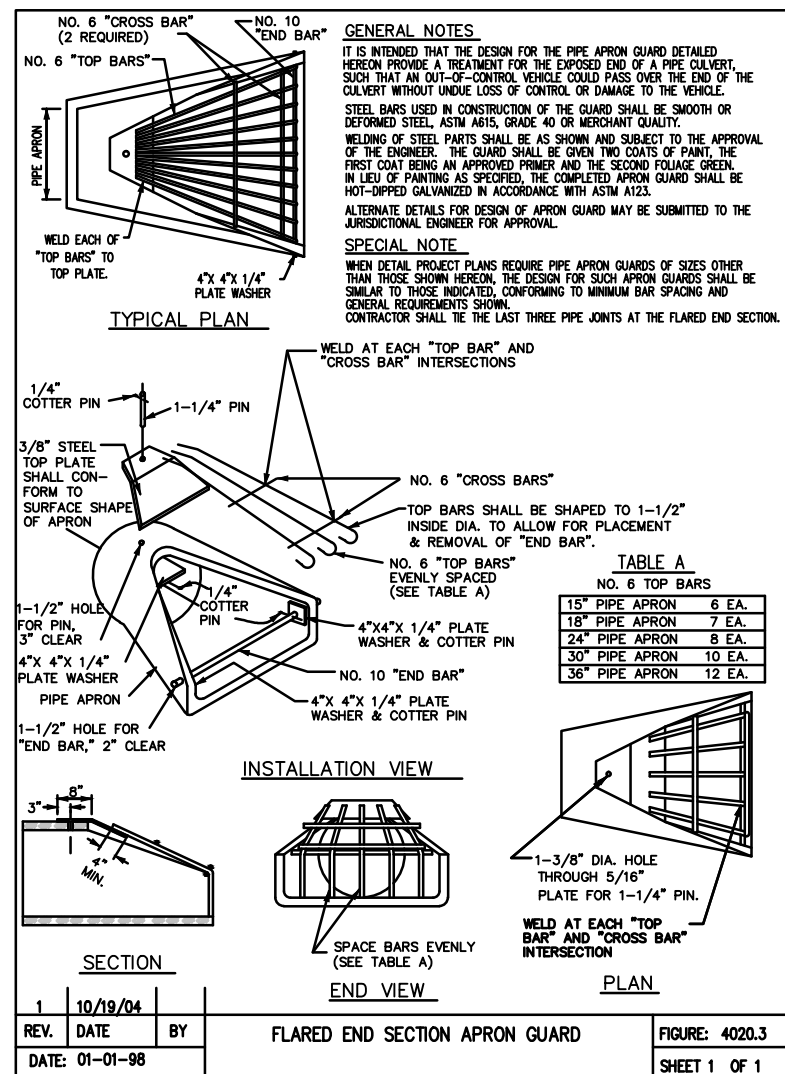

 Q:\E-FILES\E-6000\E6853\ASBULTS\ASBULT-PAVING-RAMPS.dwg, 8/3/2015 9:44:20 AM, cmc:cam

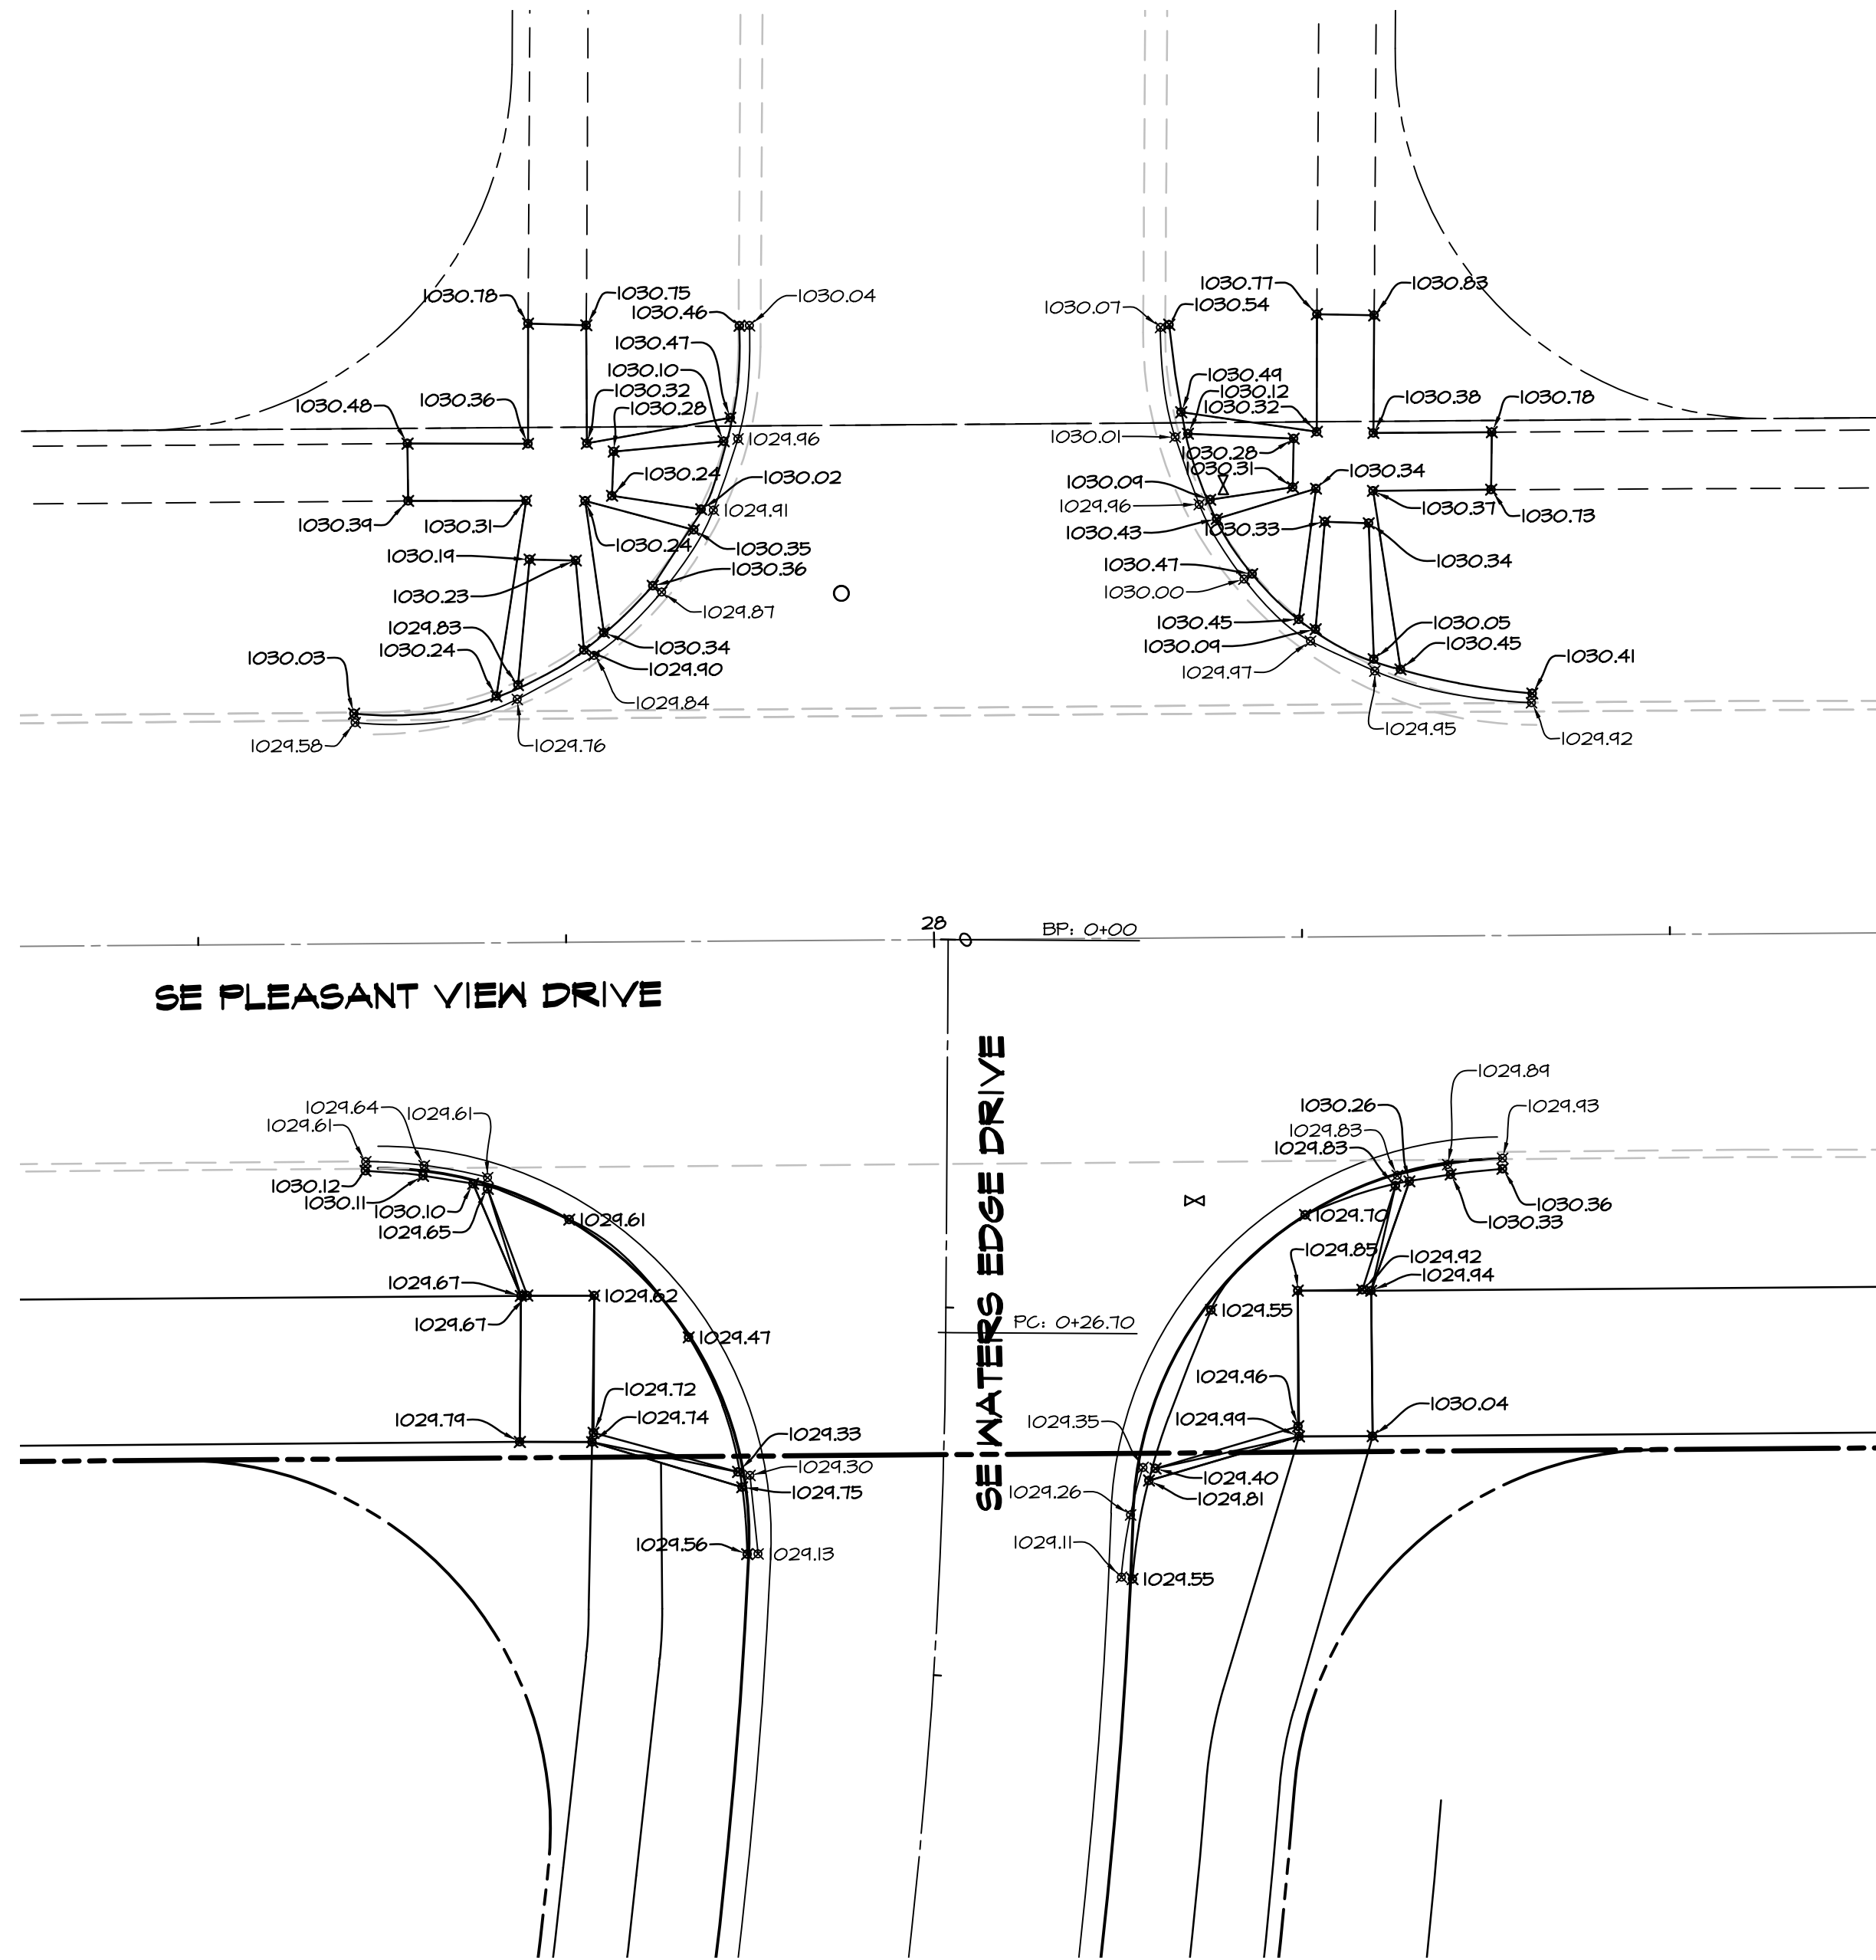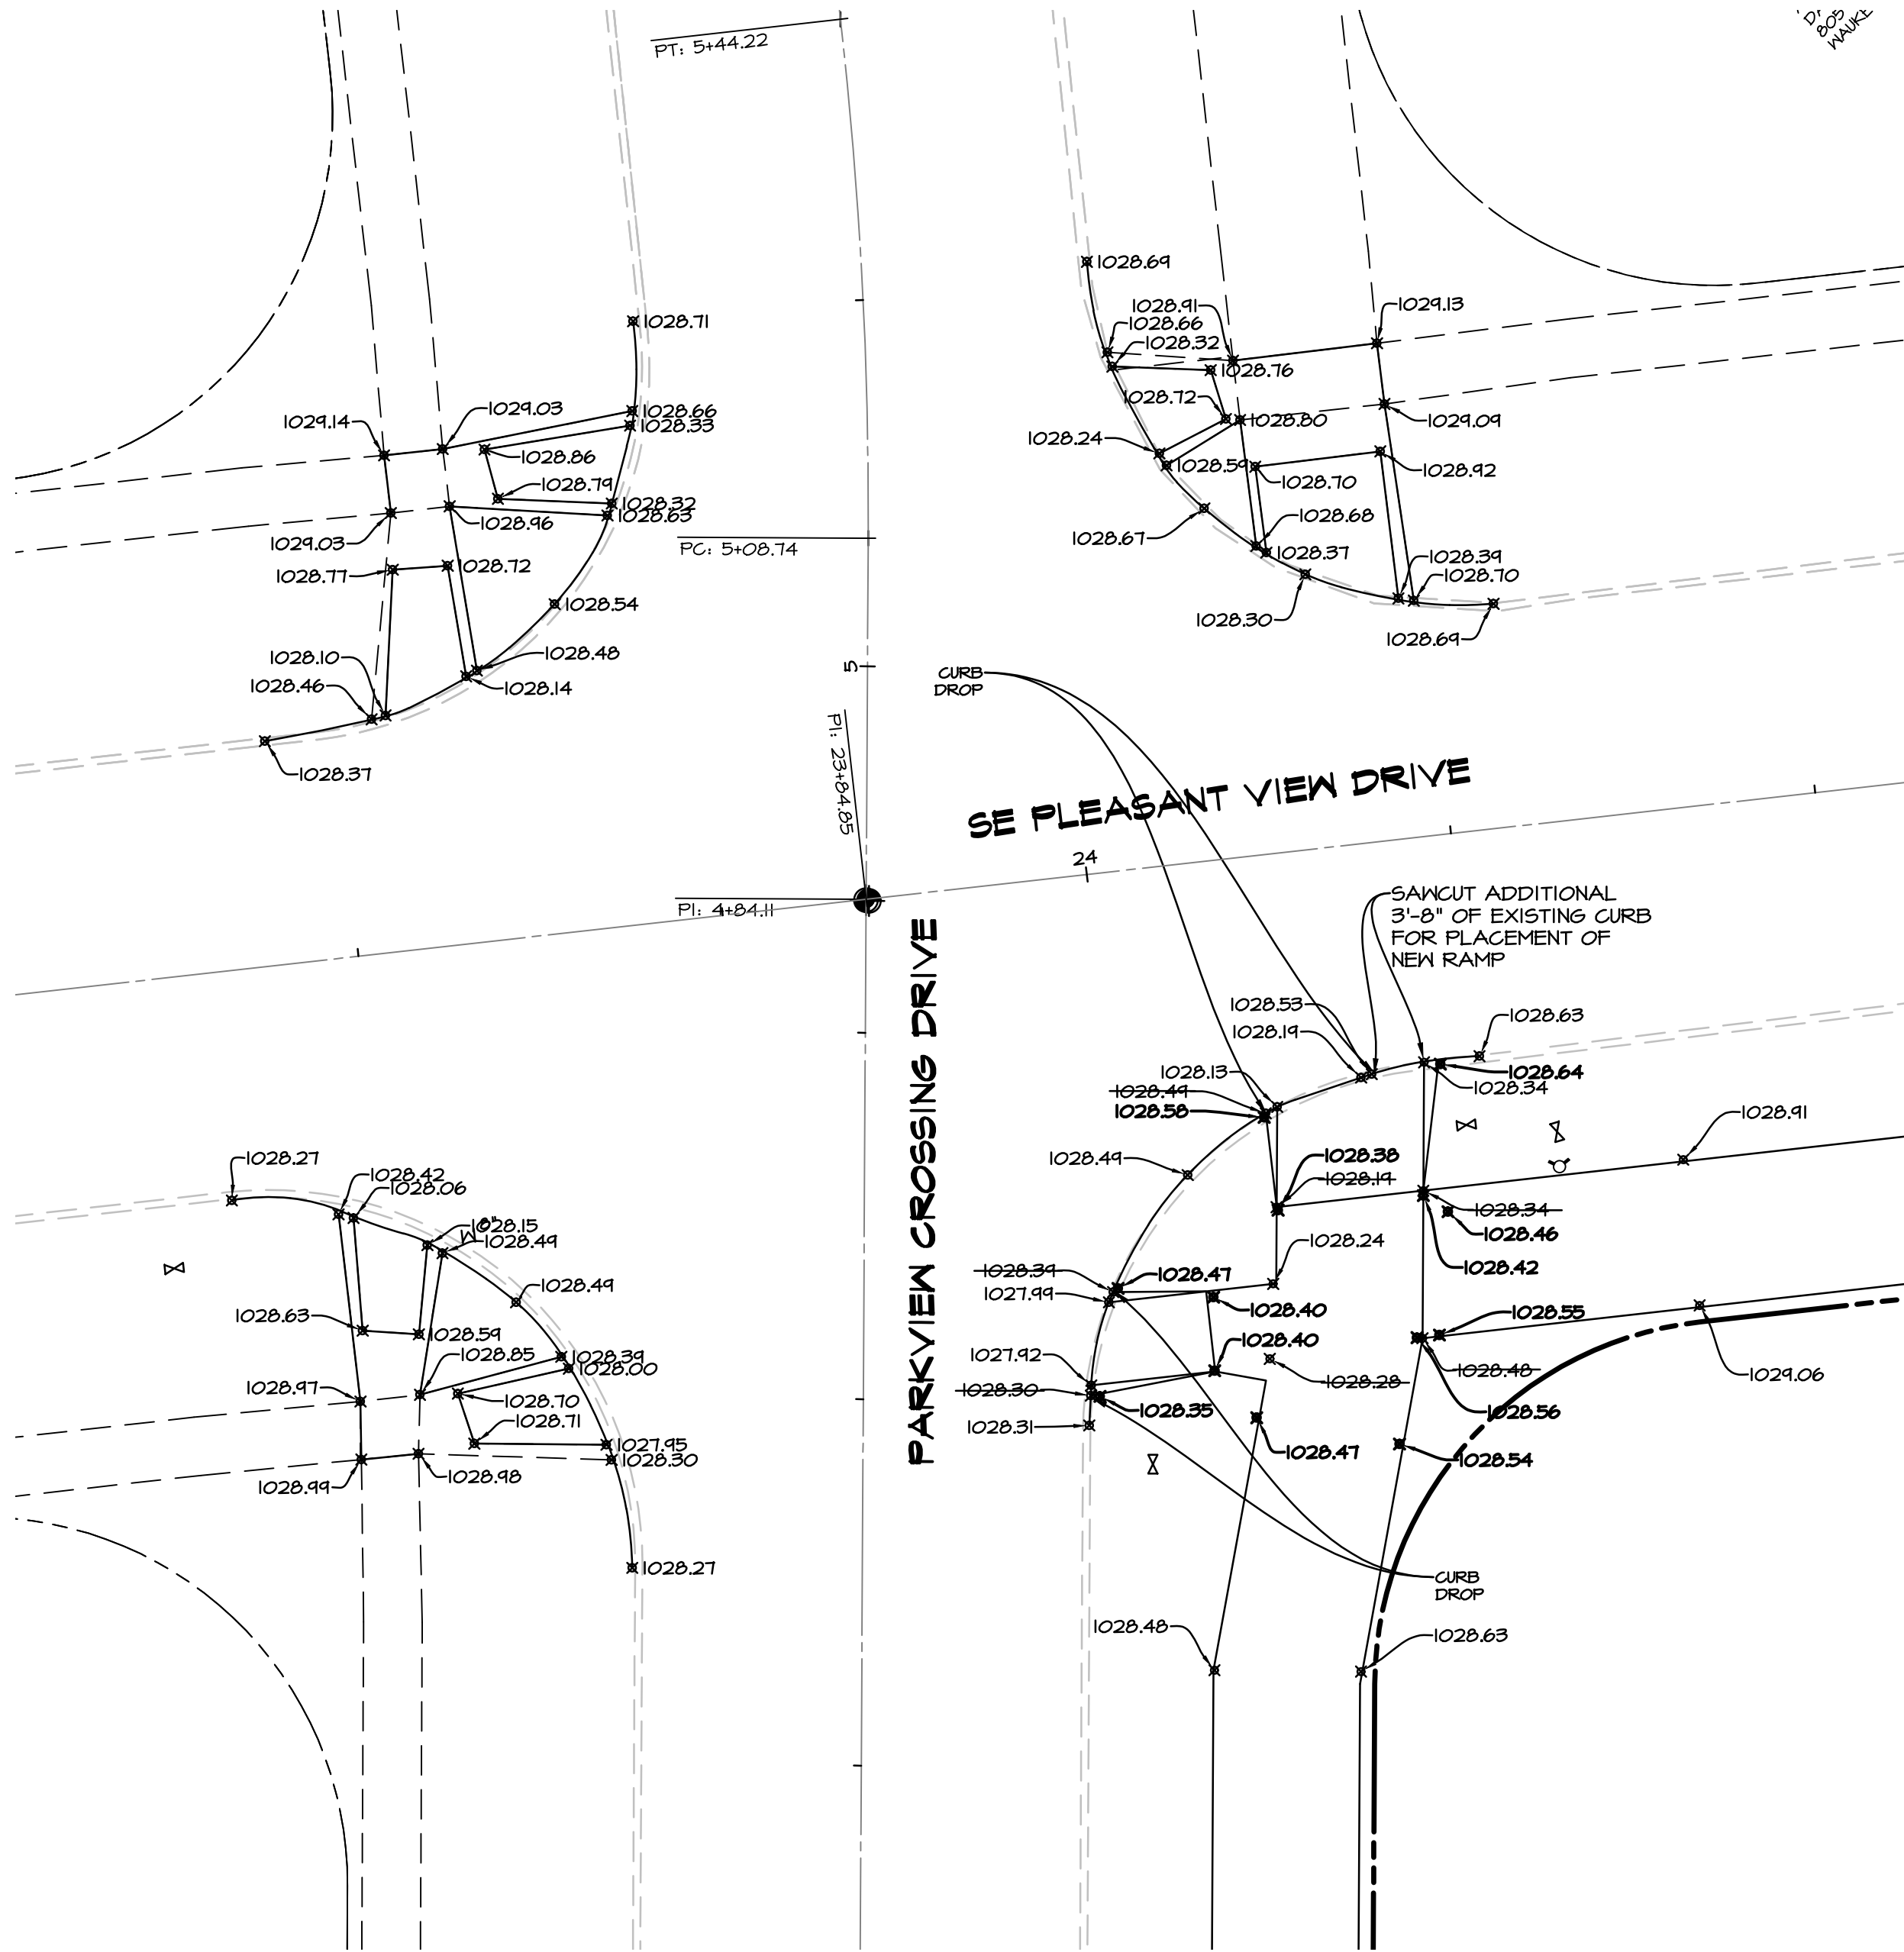

PARKVIEW CROSSING PLAT II
WAUKEE, IA
ASBULT PAVING RAMPS

SHEET
10
OF 10

E-6853

DATE:	07-10-2015	REVISIONS	COMMENTS
		1	
		2	
		3	
		4	
		5	MMH
		6	MMH

DATE OF SURVEY:
DESIGNED BY:
DRAWN BY:

Civil Engineering Consultants, Inc.
2400 86th Street, Unit 12, Des Moines, Iowa 50322
515.276.4884, Fax: 515.276.7084, mail@ceclac.com

